
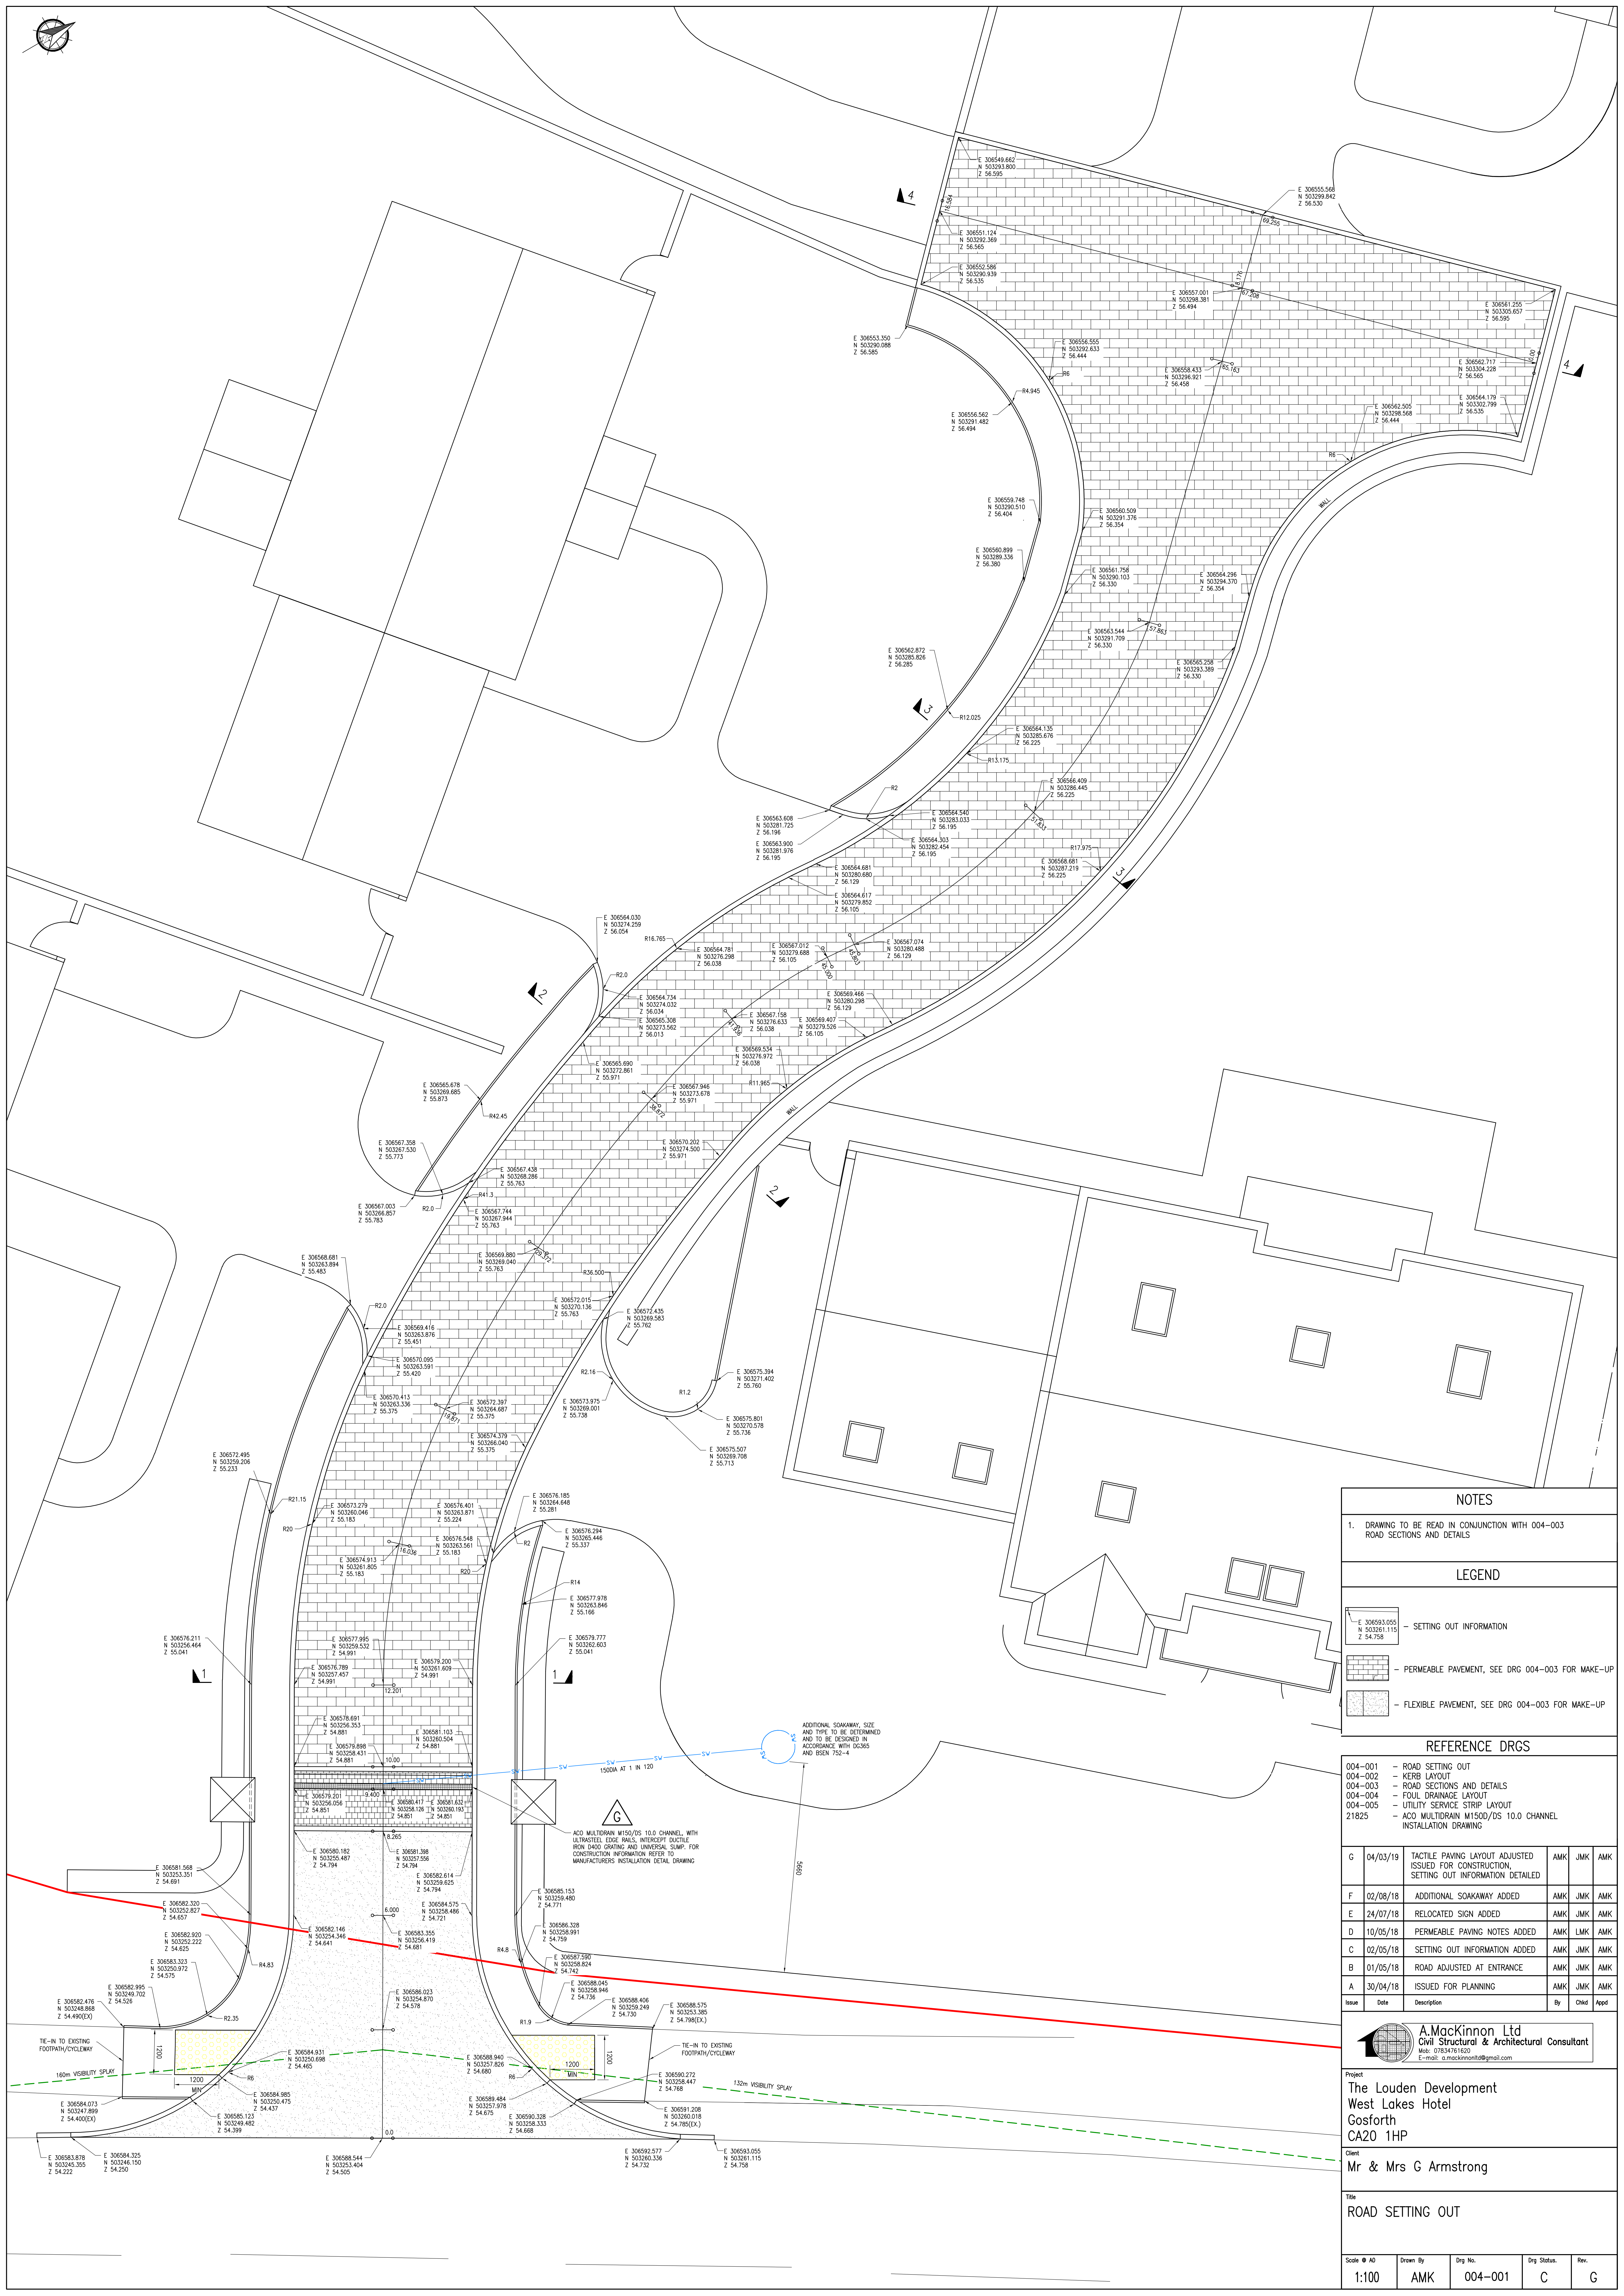


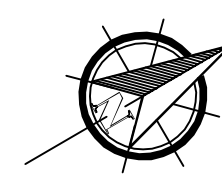

NOTES

1. DRAWING TO BE READ IN CONJUNCTION WITH 004-003 ROAD SECTIONS AND DETAILS

LEGEND

E 306593.055
N 503261.115
Z 54.738

— SETTING OUT INFORMATION

— PERMEABLE PAVEMENT, SEE DRG 004-003 FOR MAKE-UP

— FLEXIBLE PAVEMENT, SEE DRG 004-003 FOR MAKE-UP

REFERENCE DRGS

004-001 — ROAD SETTING OUT

004-002 — KERB LAYOUT

004-003 — ROAD SECTIONS AND DETAILS

004-004 — FOUL DRAINAGE LAYOUT

004-005 — UTILITY SERVICE STRIP LAYOUT

21825 — ACC MULTIDRAIN M150/DS 10.0 CHANNEL INSTALLATION DRAWING

G	04/03/19	TACTILE PAVING LAYOUT ADJUSTED ISSUED FOR CONSTRUCTION, SETTING OUT INFORMATION DETAILED	AMK	JMK	AMK
F	02/08/18	ADDITIONAL SOAKAWAY ADDED	AMK	JMK	AMK
E	24/07/18	RELOCATED SIGN ADDED	AMK	JMK	AMK
D	10/05/18	PERMEABLE PAVING NOTES ADDED	AMK	LMK	AMK
C	02/05/18	SETTING OUT INFORMATION ADDED	AMK	JMK	AMK
B	01/05/18	ROAD ADJUSTED AT ENTRANCE	AMK	JMK	AMK
A	30/04/18	ISSUED FOR PLANNING	AMK	JMK	AMK
Issue	Date	Description	By	Chkd	Appd

A.MacKinnon Ltd

Civil Structural & Architectural Consultant

Mob: 07834761820

E-mail: a.mackinnon12@gmail.com

Project

The Loudon Development

West Lakes Hotel

Gosforth

CA20 1HP

Client

Mr & Mrs G Armstrong

Title

ROAD SETTING OUT

Scale

1:100

Drawn By

AMK

Dwg No.

004-001

Dwg Status.

C

Rev.

G