
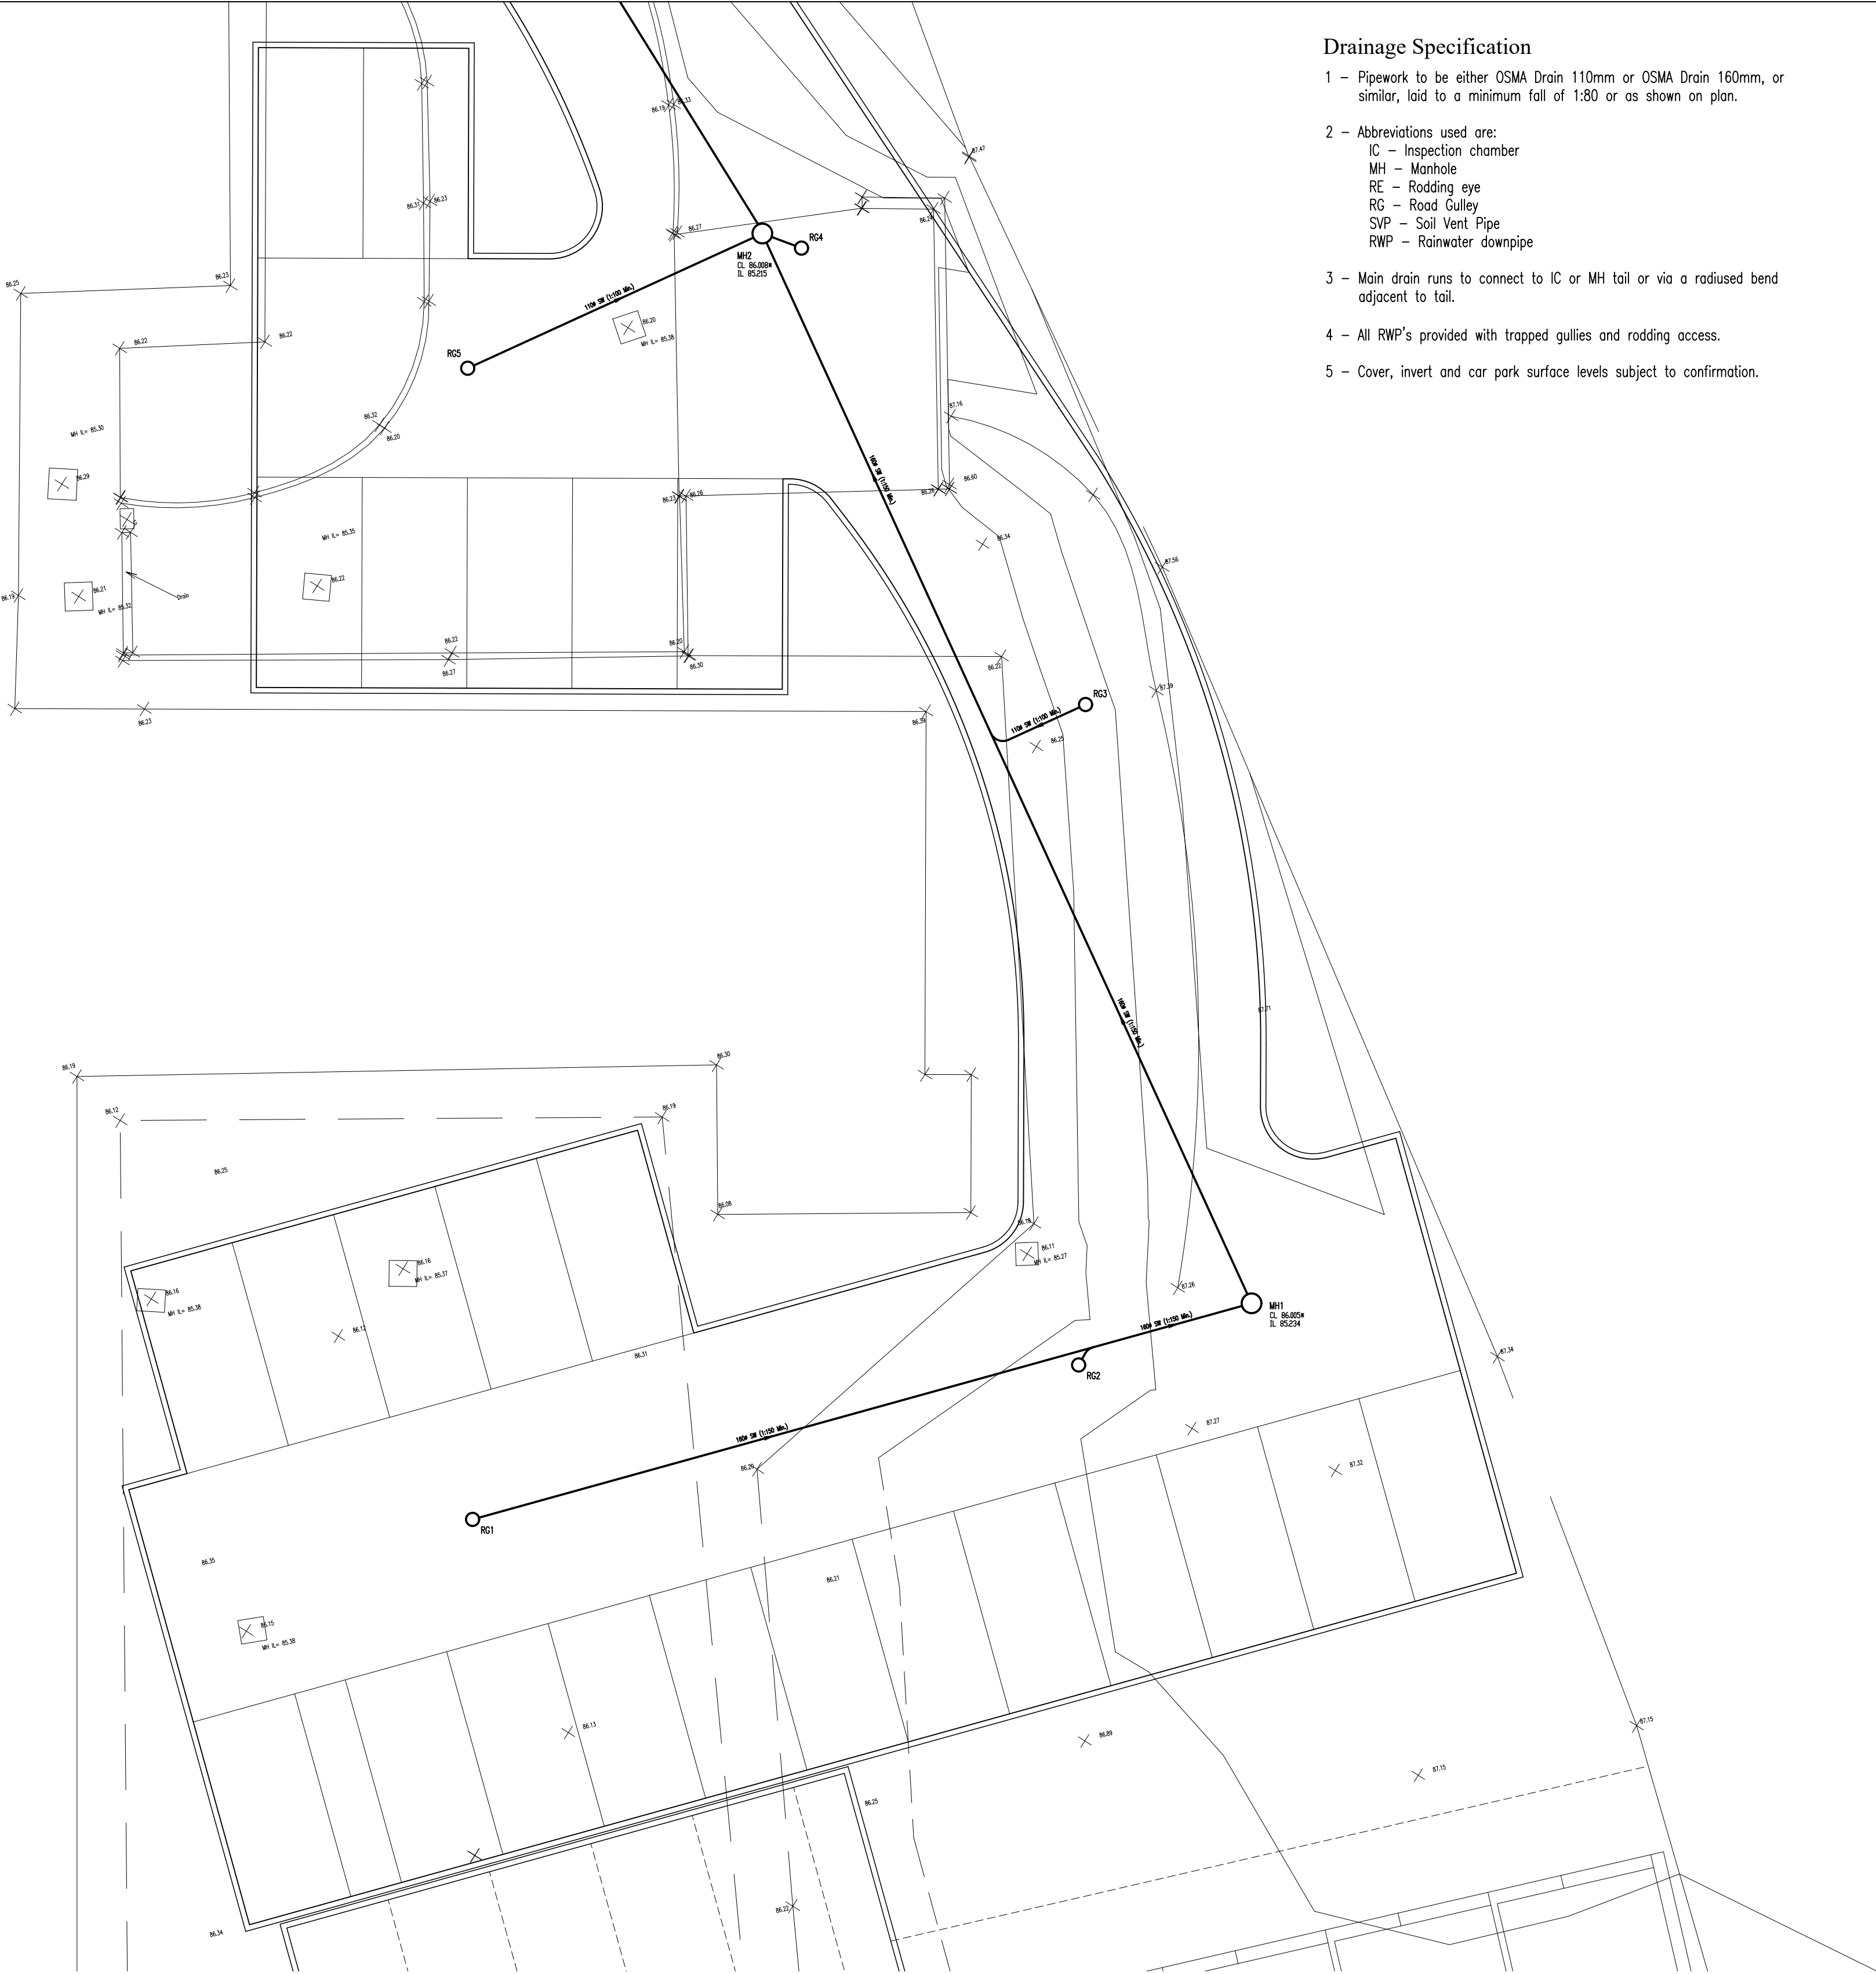


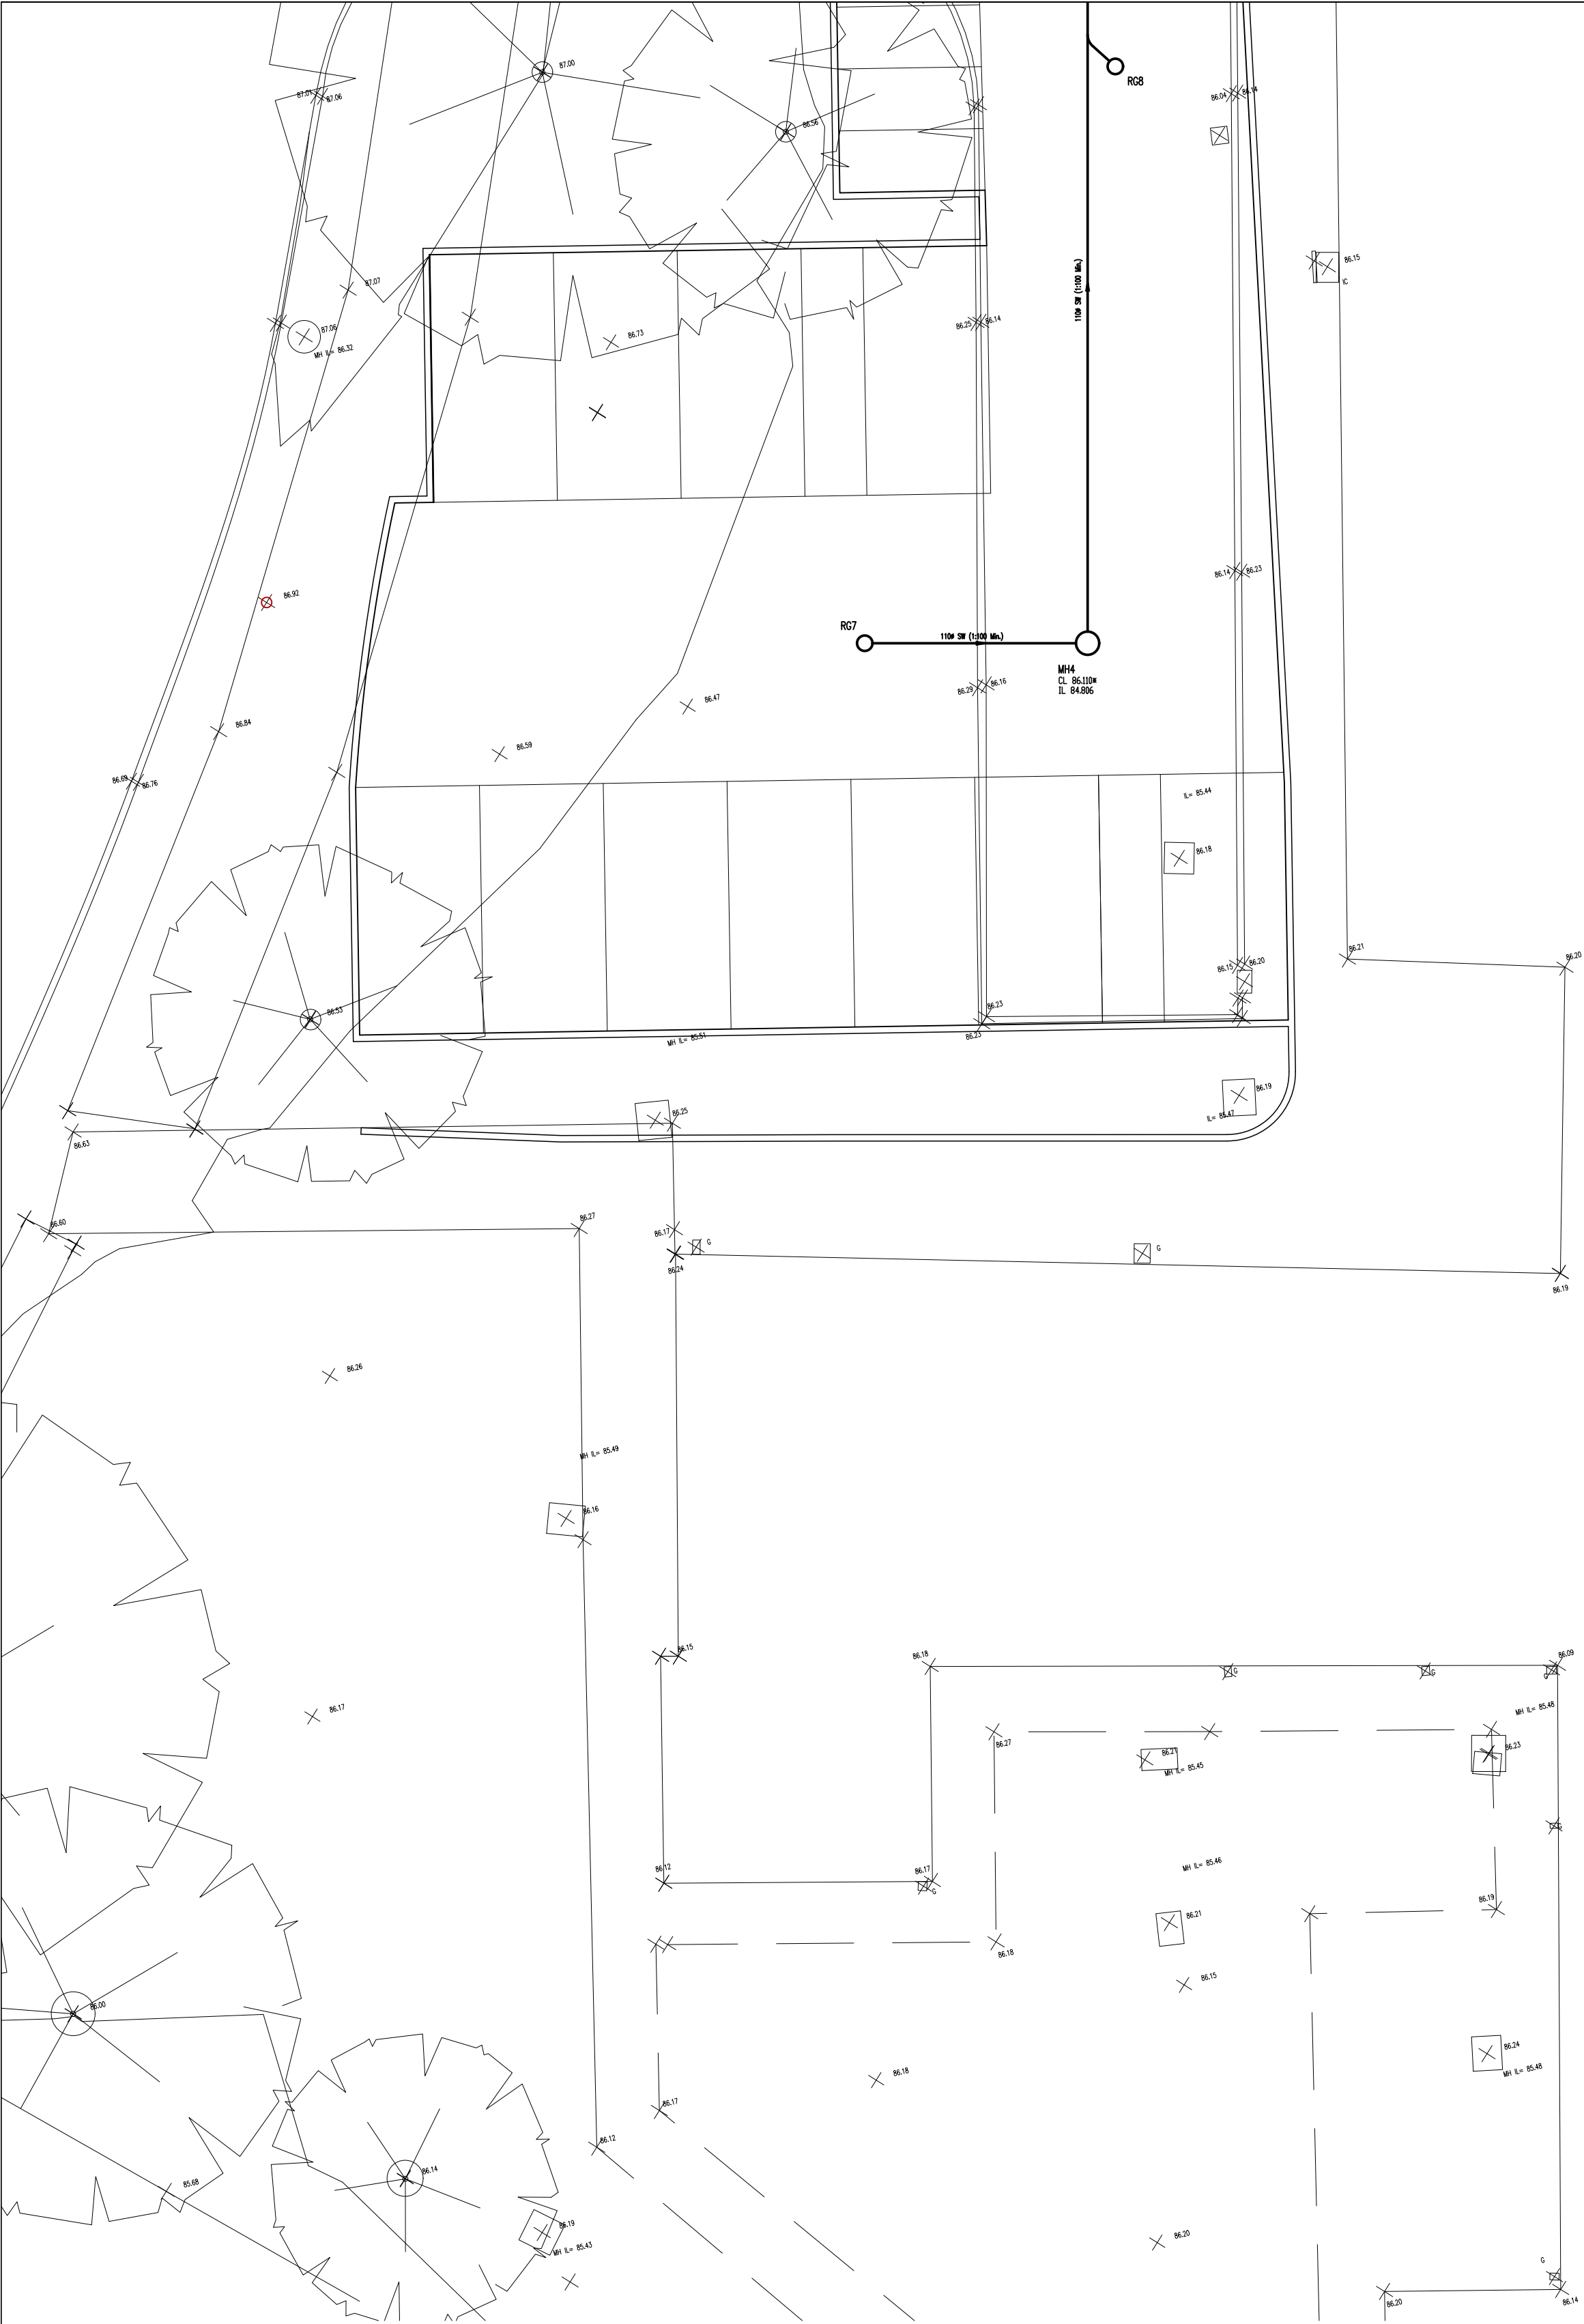

- Drainage Specification**
- 1 – Pipework to be either OSMA Drain 110mm or OSMA Drain 160mm, or similar, laid to a minimum fall of 1:80 or as shown on plan.
  - 2 – Abbreviations used are:  
IC – Inspection chamber  
MH – Manhole  
RE – Rodding eye  
RG – Road Gully  
SVP – Soil Vent Pipe  
RWP – Rainwater downpipe
  - 3 – Main drain runs to connect to IC or MH tail or via a radiused bend adjacent to tail.
  - 4 – All RWP's provided with trapped gullies and rodding access.
  - 5 – Cover, invert and car park surface levels subject to confirmation.

Proposed Drainage Layout - Sheet No. 1 of 2  
Scale 1:100

NOTES

Copyright of this drawing remains with MBC Designs.  
Do not scale from this drawing.  
Dimensions marked "\*" shall be checked on site by the Contractor prior to the commencement of work on site.  
Dimensional discrepancies shall be notified to MBC Designs.

|                                                                   |      |                |                                                                                                                                                                      |         |                                                                                                                                  |            |  |  |
|-------------------------------------------------------------------|------|----------------|----------------------------------------------------------------------------------------------------------------------------------------------------------------------|---------|----------------------------------------------------------------------------------------------------------------------------------|------------|--|--|
| Rev                                                               | Date | Description    | <div><div></div><div><b>MBC Designs</b><br/>Building Design Service</div></div> |         | 26 Gloucester Road, Wyton-On-The-Hill,<br>Huntingdon, Cambs. PE28 2HF<br>Tel. No. - 07986 115913<br>E-mail - mrvandem@btol.co.uk |            |  |  |
|                                                                   |      |                |                                                                                                                                                                      |         |                                                                                                                                  |            |  |  |
| Dentholme, Cragg Road, Cleator Moor, CA25 5PR<br>Hotel Conversion |      |                |                                                                                                                                                                      |         |                                                                                                                                  |            |  |  |
| Drainage Layout – Sheet No. 1 Of 2                                |      |                |                                                                                                                                                                      |         |                                                                                                                                  |            |  |  |
| DRAWN <b>MRV</b>                                                  |      | CHECKED        |                                                                                                                                                                      | DRG No. |                                                                                                                                  | 0010121-20 |  |  |
| SCALES 1:100                                                      |      | DATE June 2023 |                                                                                                                                                                      |         |                                                                                                                                  |            |  |  |
| ACAD FILE No. 0010121                                             |      |                |                                                                                                                                                                      |         |                                                                                                                                  |            |  |  |
|                                                                   |      |                |                                                                                                                                                                      |         |                                                                                                                                  | REV        |  |  |
|                                                                   |      |                |                                                                                                                                                                      |         |                                                                                                                                  | ©copyright |  |  |