


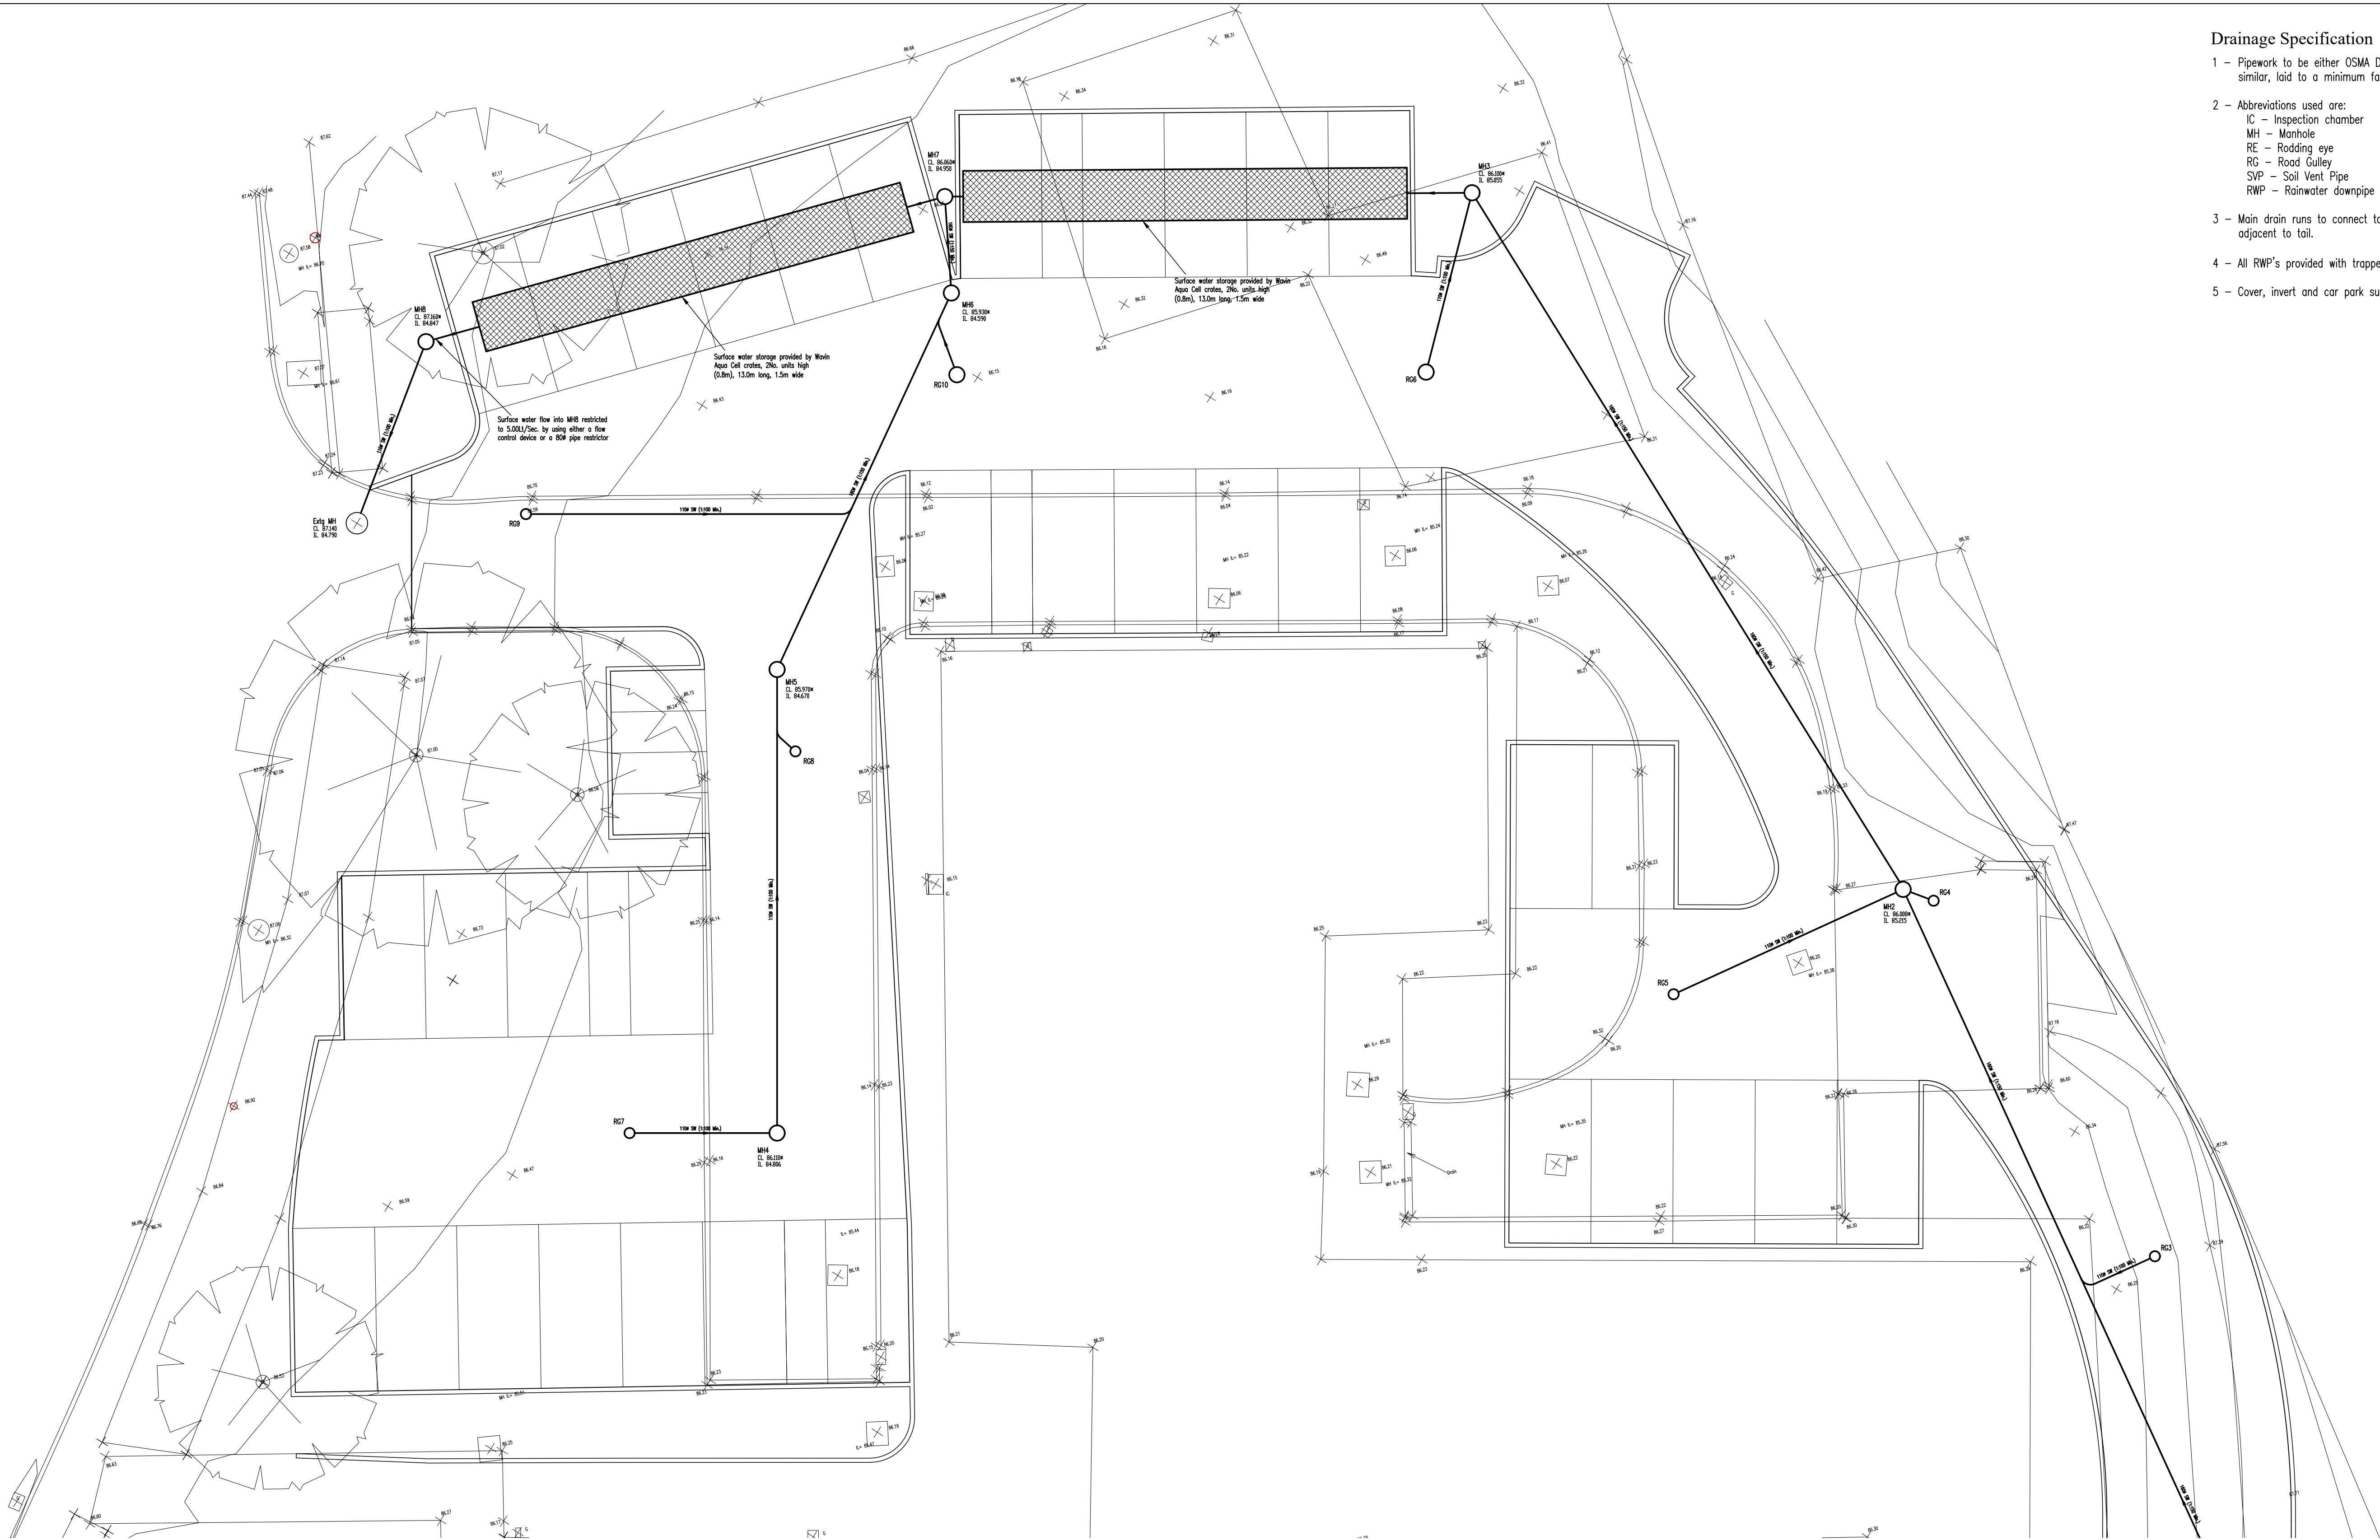

Proposed Drainage Layout - Sheet No. 2 of 2
Scale 1:100

Drainage Specification

- 1 - Pipework to be either OSMA Drain 110mm or OSMA Drain 160mm, or similar, laid to a minimum fall of 1:80 or as shown on plan.
- 2 - Abbreviations used are:
IC - Inspection chamber
MH - Manhole
RE - Rodding eye
RG - Road Gully
SVP - Soil Vent Pipe
RWP - Rainwater downpipe
- 3 - Main drain runs to connect to IC or MH tail or via a radiused bend adjacent to tail.
- 4 - All RWP's provided with trapped gullies and rodding access.
- 5 - Cover, invert and car park surface levels subject to confirmation.

NOTES

Copyright of this drawing remains with MBC Designs.
Do not scale from this drawing.
Dimensions marked "*" shall be checked on site by the Contractor prior to the commencement of work on site.
Dimensional discrepancies shall be notified to MBC Designs.

Rev	Date	Description	MBC Designs Building Design Service 26 Gloucester Road, Wyton-On-The-Hill, Huntingdon, Cambs. PE28 2HF Tel. No. :- 07986 115913 E-mail - mrvandem@aol.co.uk	
Dentholme, Cragg Road, Cleator Moor, CA25 5PR Hotel Conversion			Drainage Layout – Sheet No. 2 Of 2	
DRAWN MRV		CHECKED	DRG No.	REV
SCALES 1:100		DATE June 2023	0010121-21	©Copyright
ACAD FILE No. 0010121				