


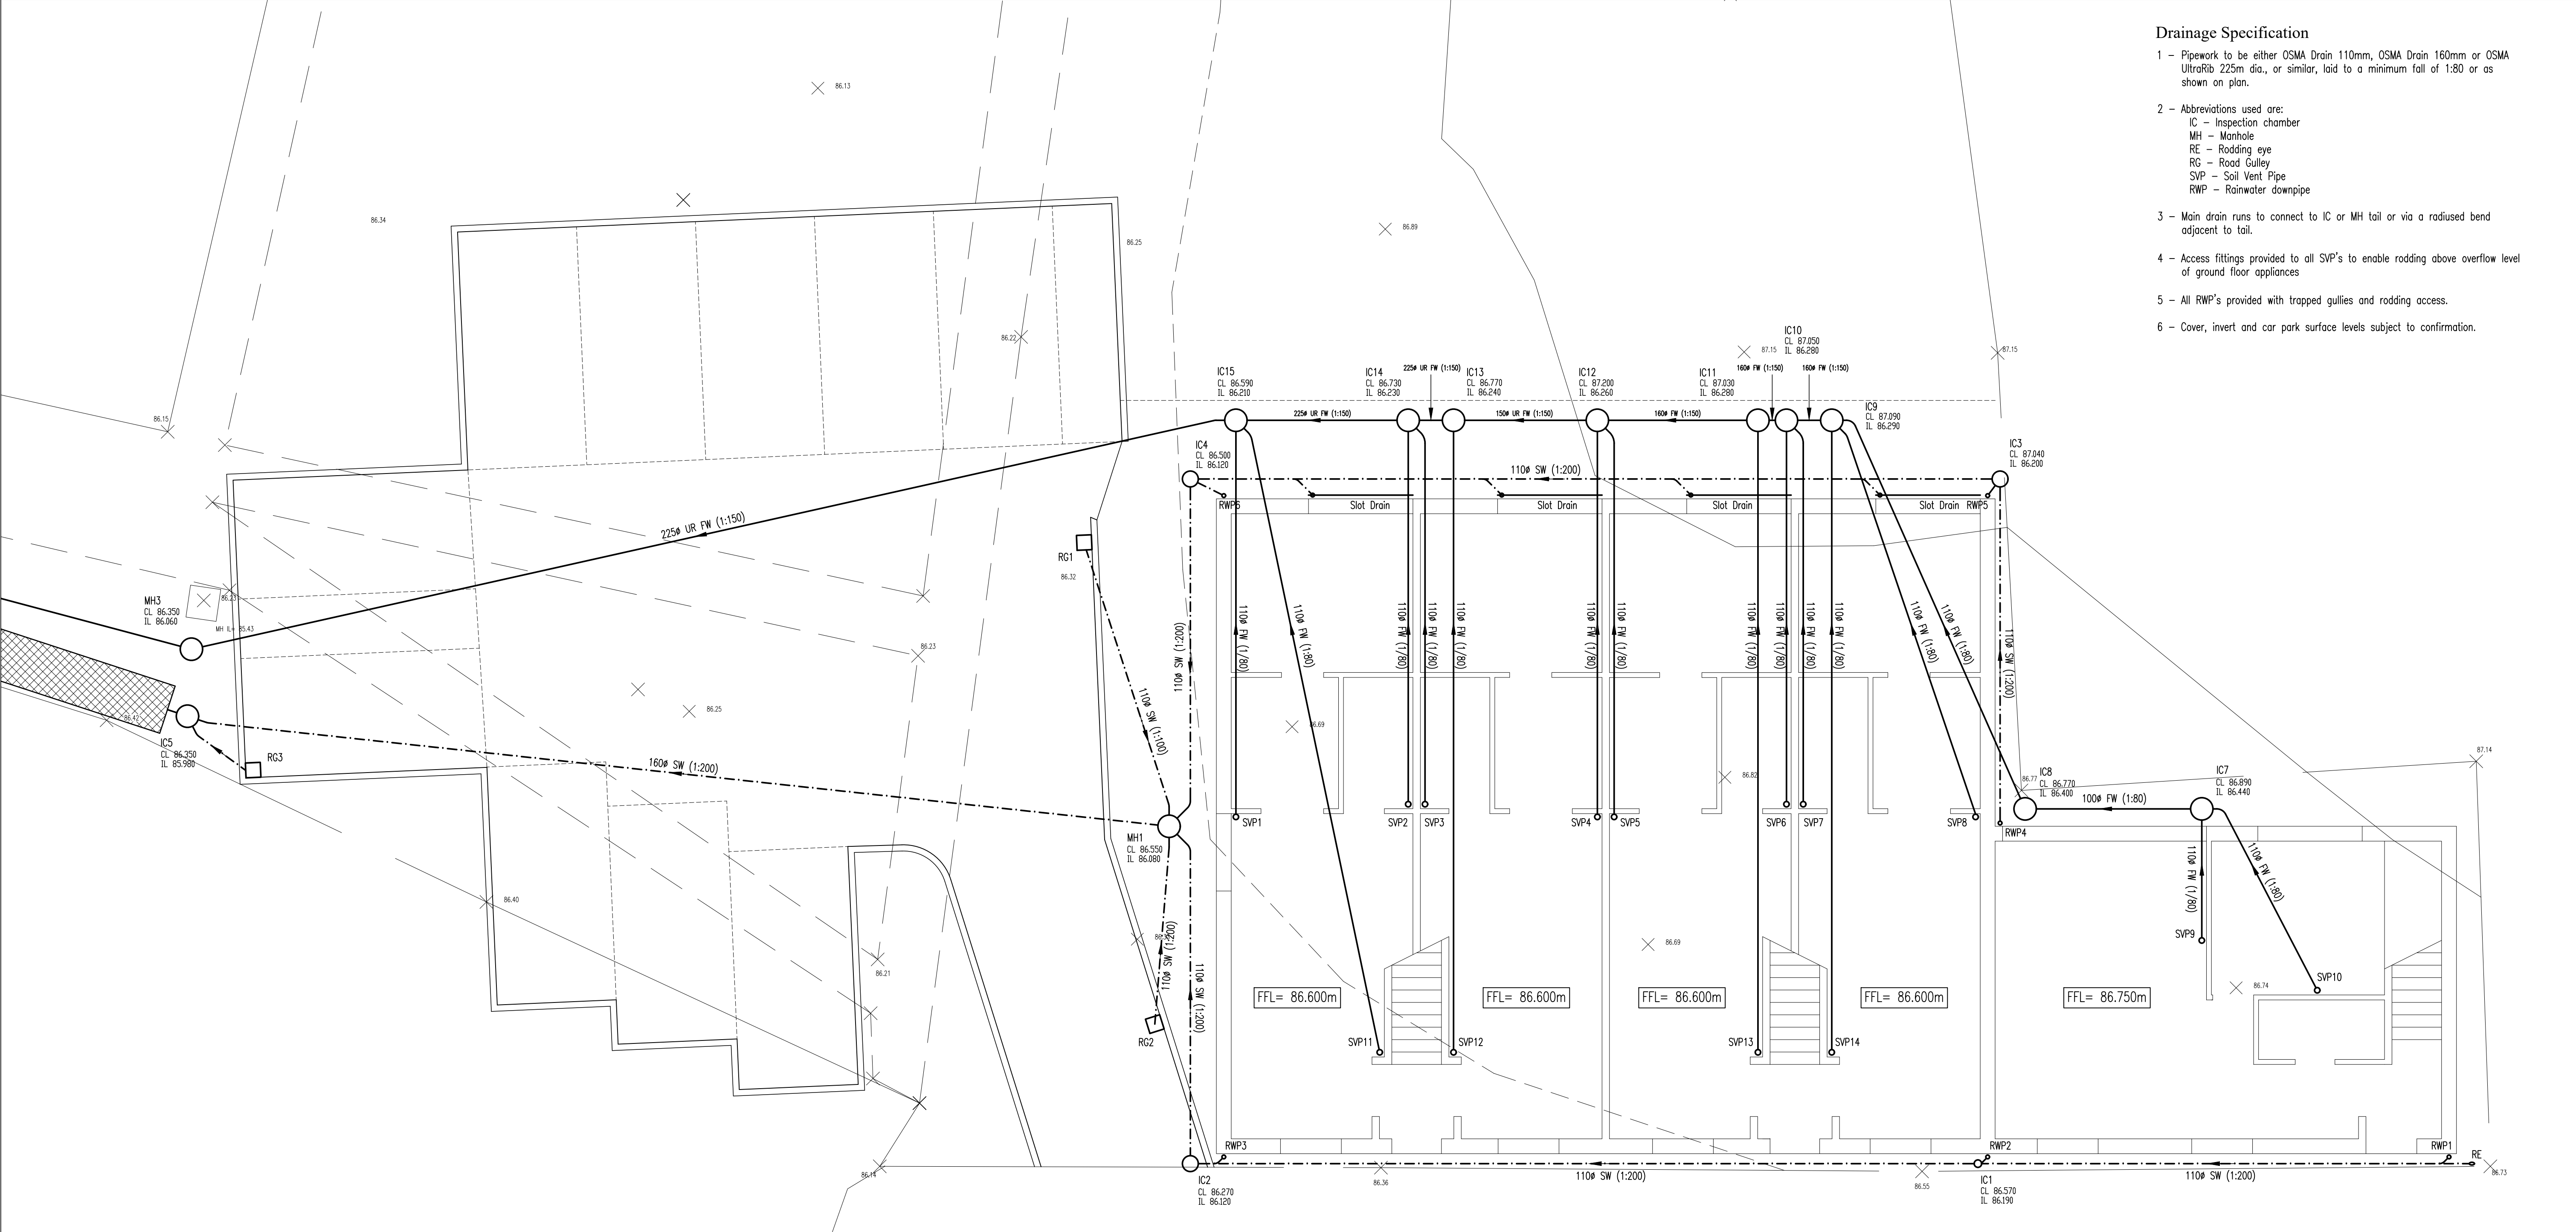

Foul And Surface Water Layout - Sheet No. 2
Scale - NTS

Drainage Specification

- 1 - Pipework to be either OSMA Drain 110mm, OSMA Drain 160mm or OSMA UltraRib 225m dia., or similar, laid to a minimum fall of 1:80 or as shown on plan.
- 2 - Abbreviations used are:
 - IC - Inspection chamber
 - MH - Manhole
 - RE - Rodding eye
 - RG - Road Gully
 - SVP - Soil Vent Pipe
 - RWP - Rainwater downpipe
- 3 - Main drain runs to connect to IC or MH tail or via a radiused bend adjacent to tail.
- 4 - Access fittings provided to all SVP's to enable rodding above overflow level of ground floor appliances
- 5 - All RWP's provided with trapped gullies and rodding access.
- 6 - Cover, invert and car park surface levels subject to confirmation.

NOTES

Copyright of this drawing remains with MBC Designs.

Do not scale from this drawing.

Dimensions marked "*" shall be checked on site by the Contractor prior to the commencement of work on site.

Dimensional discrepancies shall be notified to MBC Designs.

C	9/6/23	Layout redrawn	
B	4/2/22	Surface water drainage updated to suit United Utility requirements	
A	3/2/22	Drainage to car park area and finished floor levels amended	
Rev	Date	Description	
 MBC Designs Building Design Service			26 Gloucester Road, Wyton-On-The-Hill, Huntingdon, Cambs. PE28 2HF Tel. No. - 07986 115913 E-mail - mrvandena@aol.co.uk
Dentholme, Cragg Road, Cleator Moor, CA25 5PR New Dwellings			
Drainage Layout			
DRAWN	MRV	CHECKED	DRG No.
SCALES	NTS	DATE	Jan. 2022
ACAD FILE No.	0010121		0010121-11
			REV C
			©Copyright