
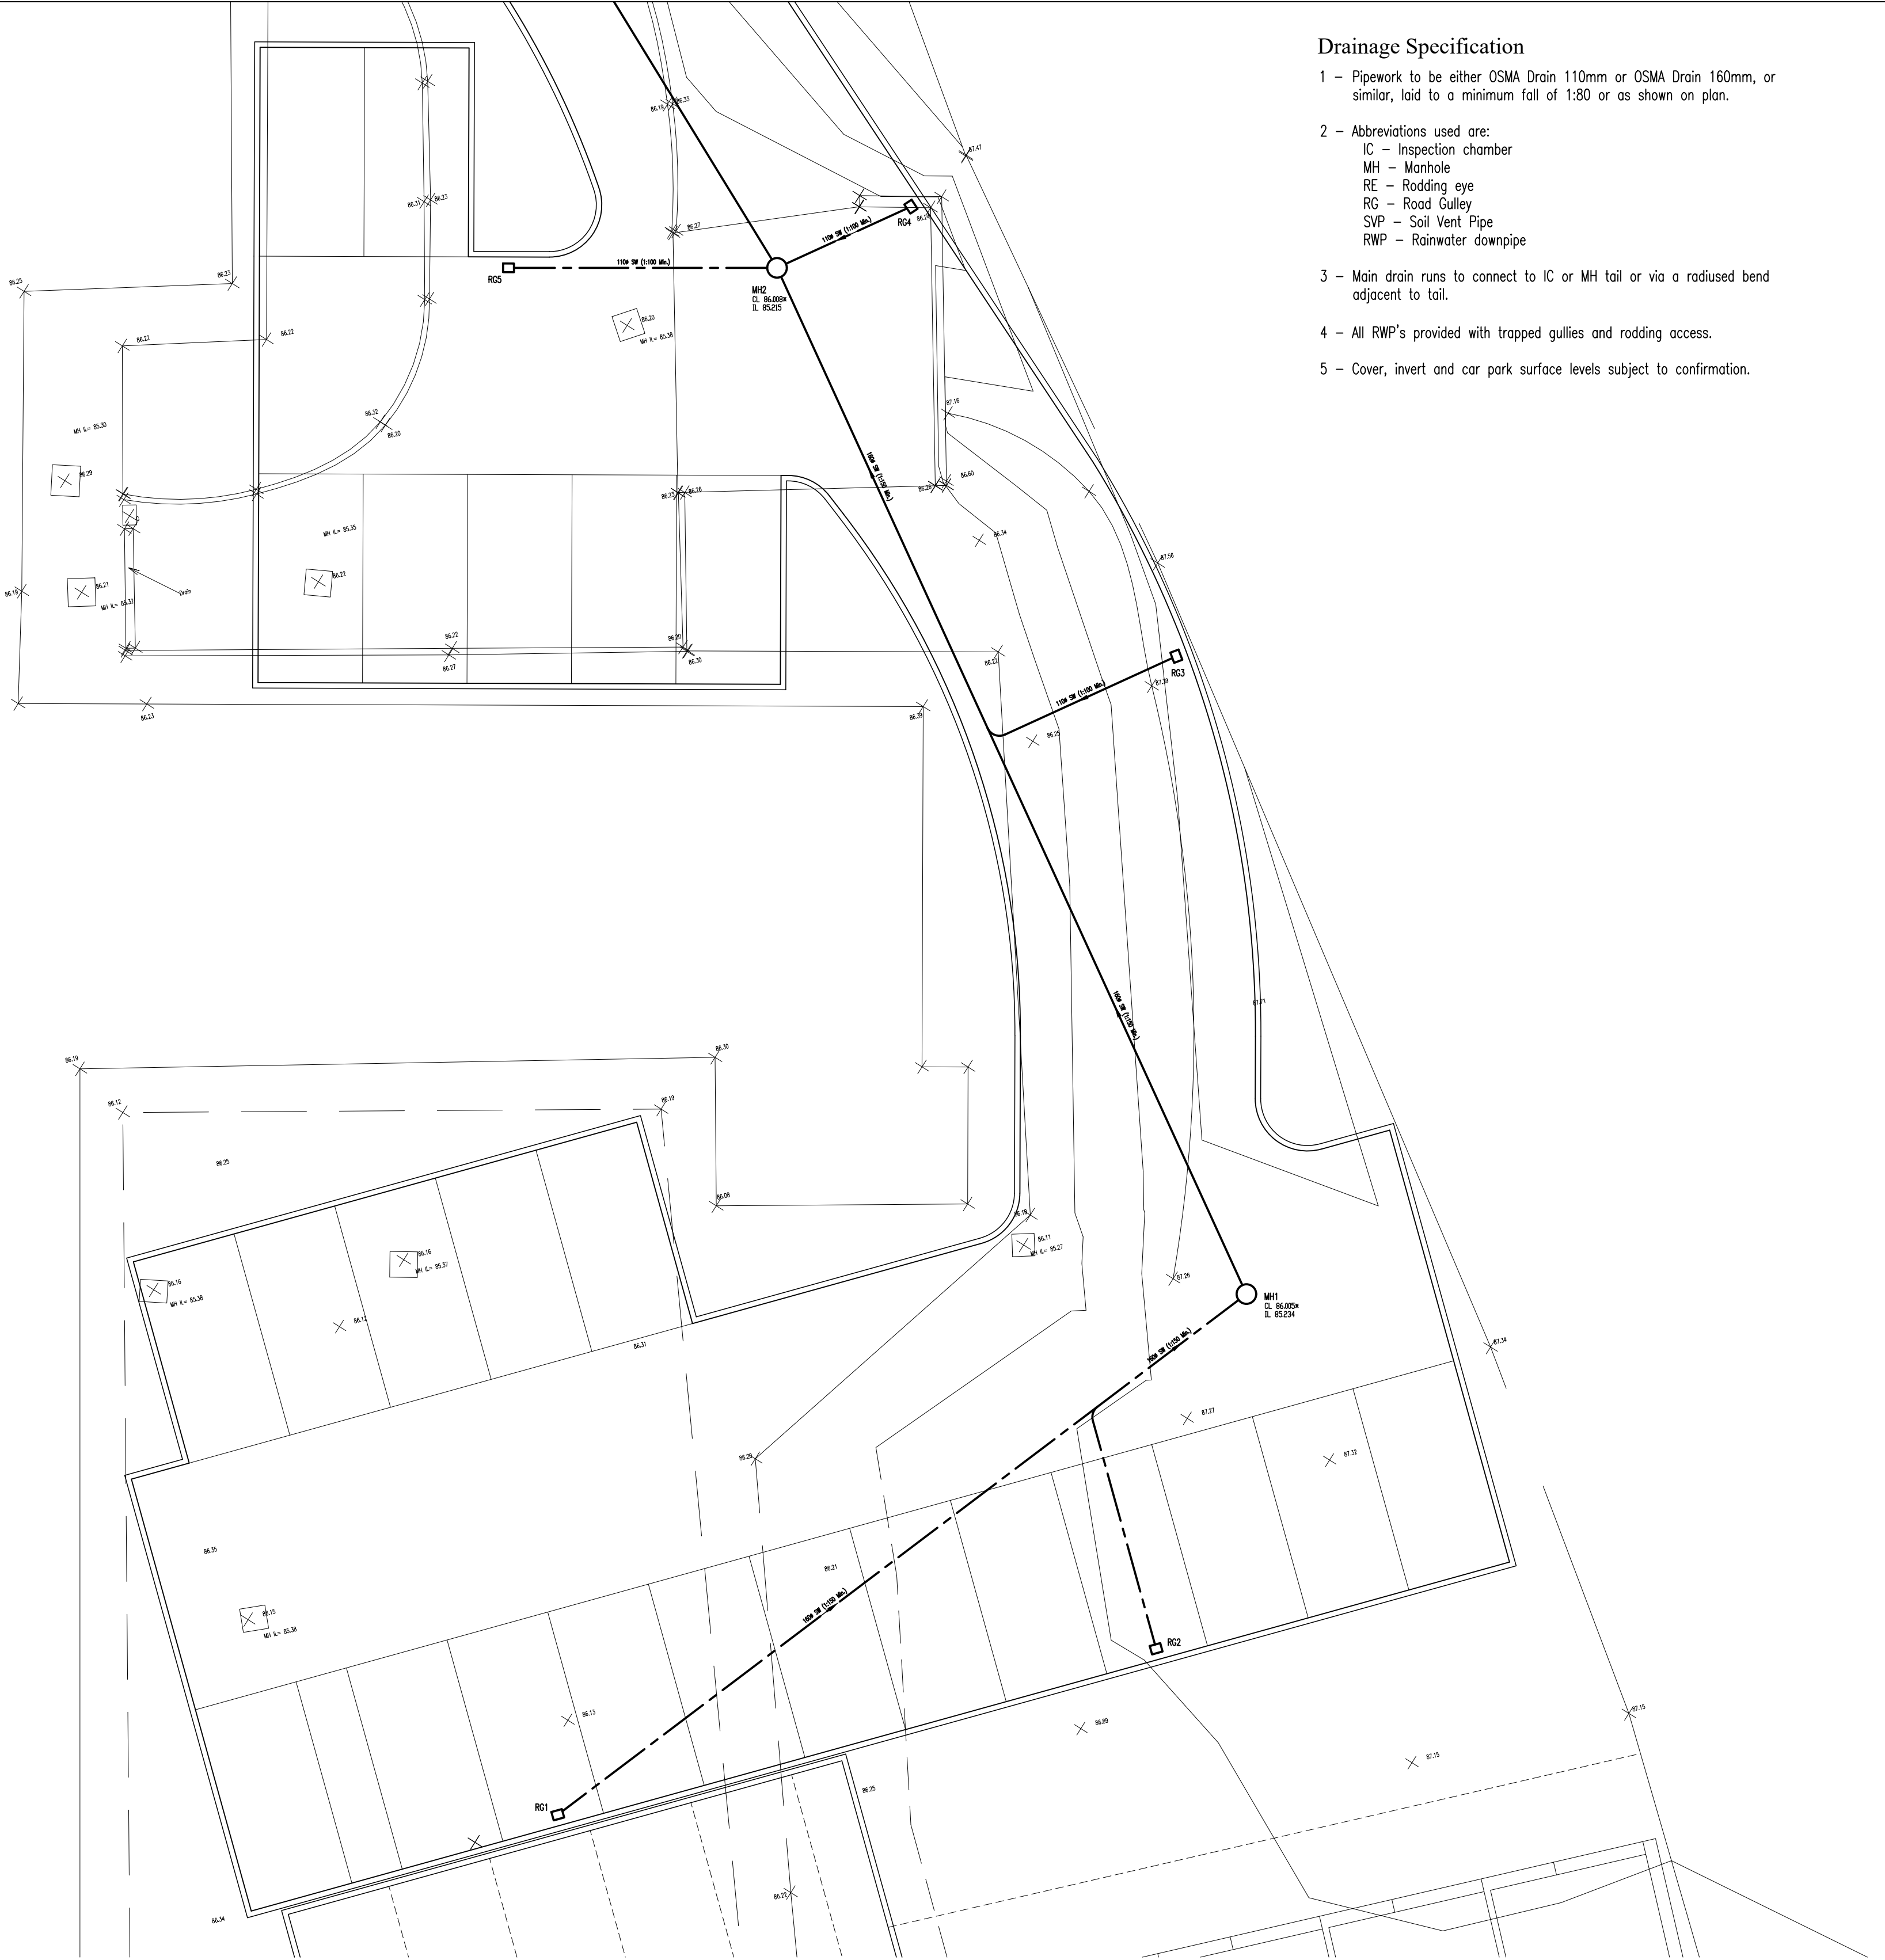


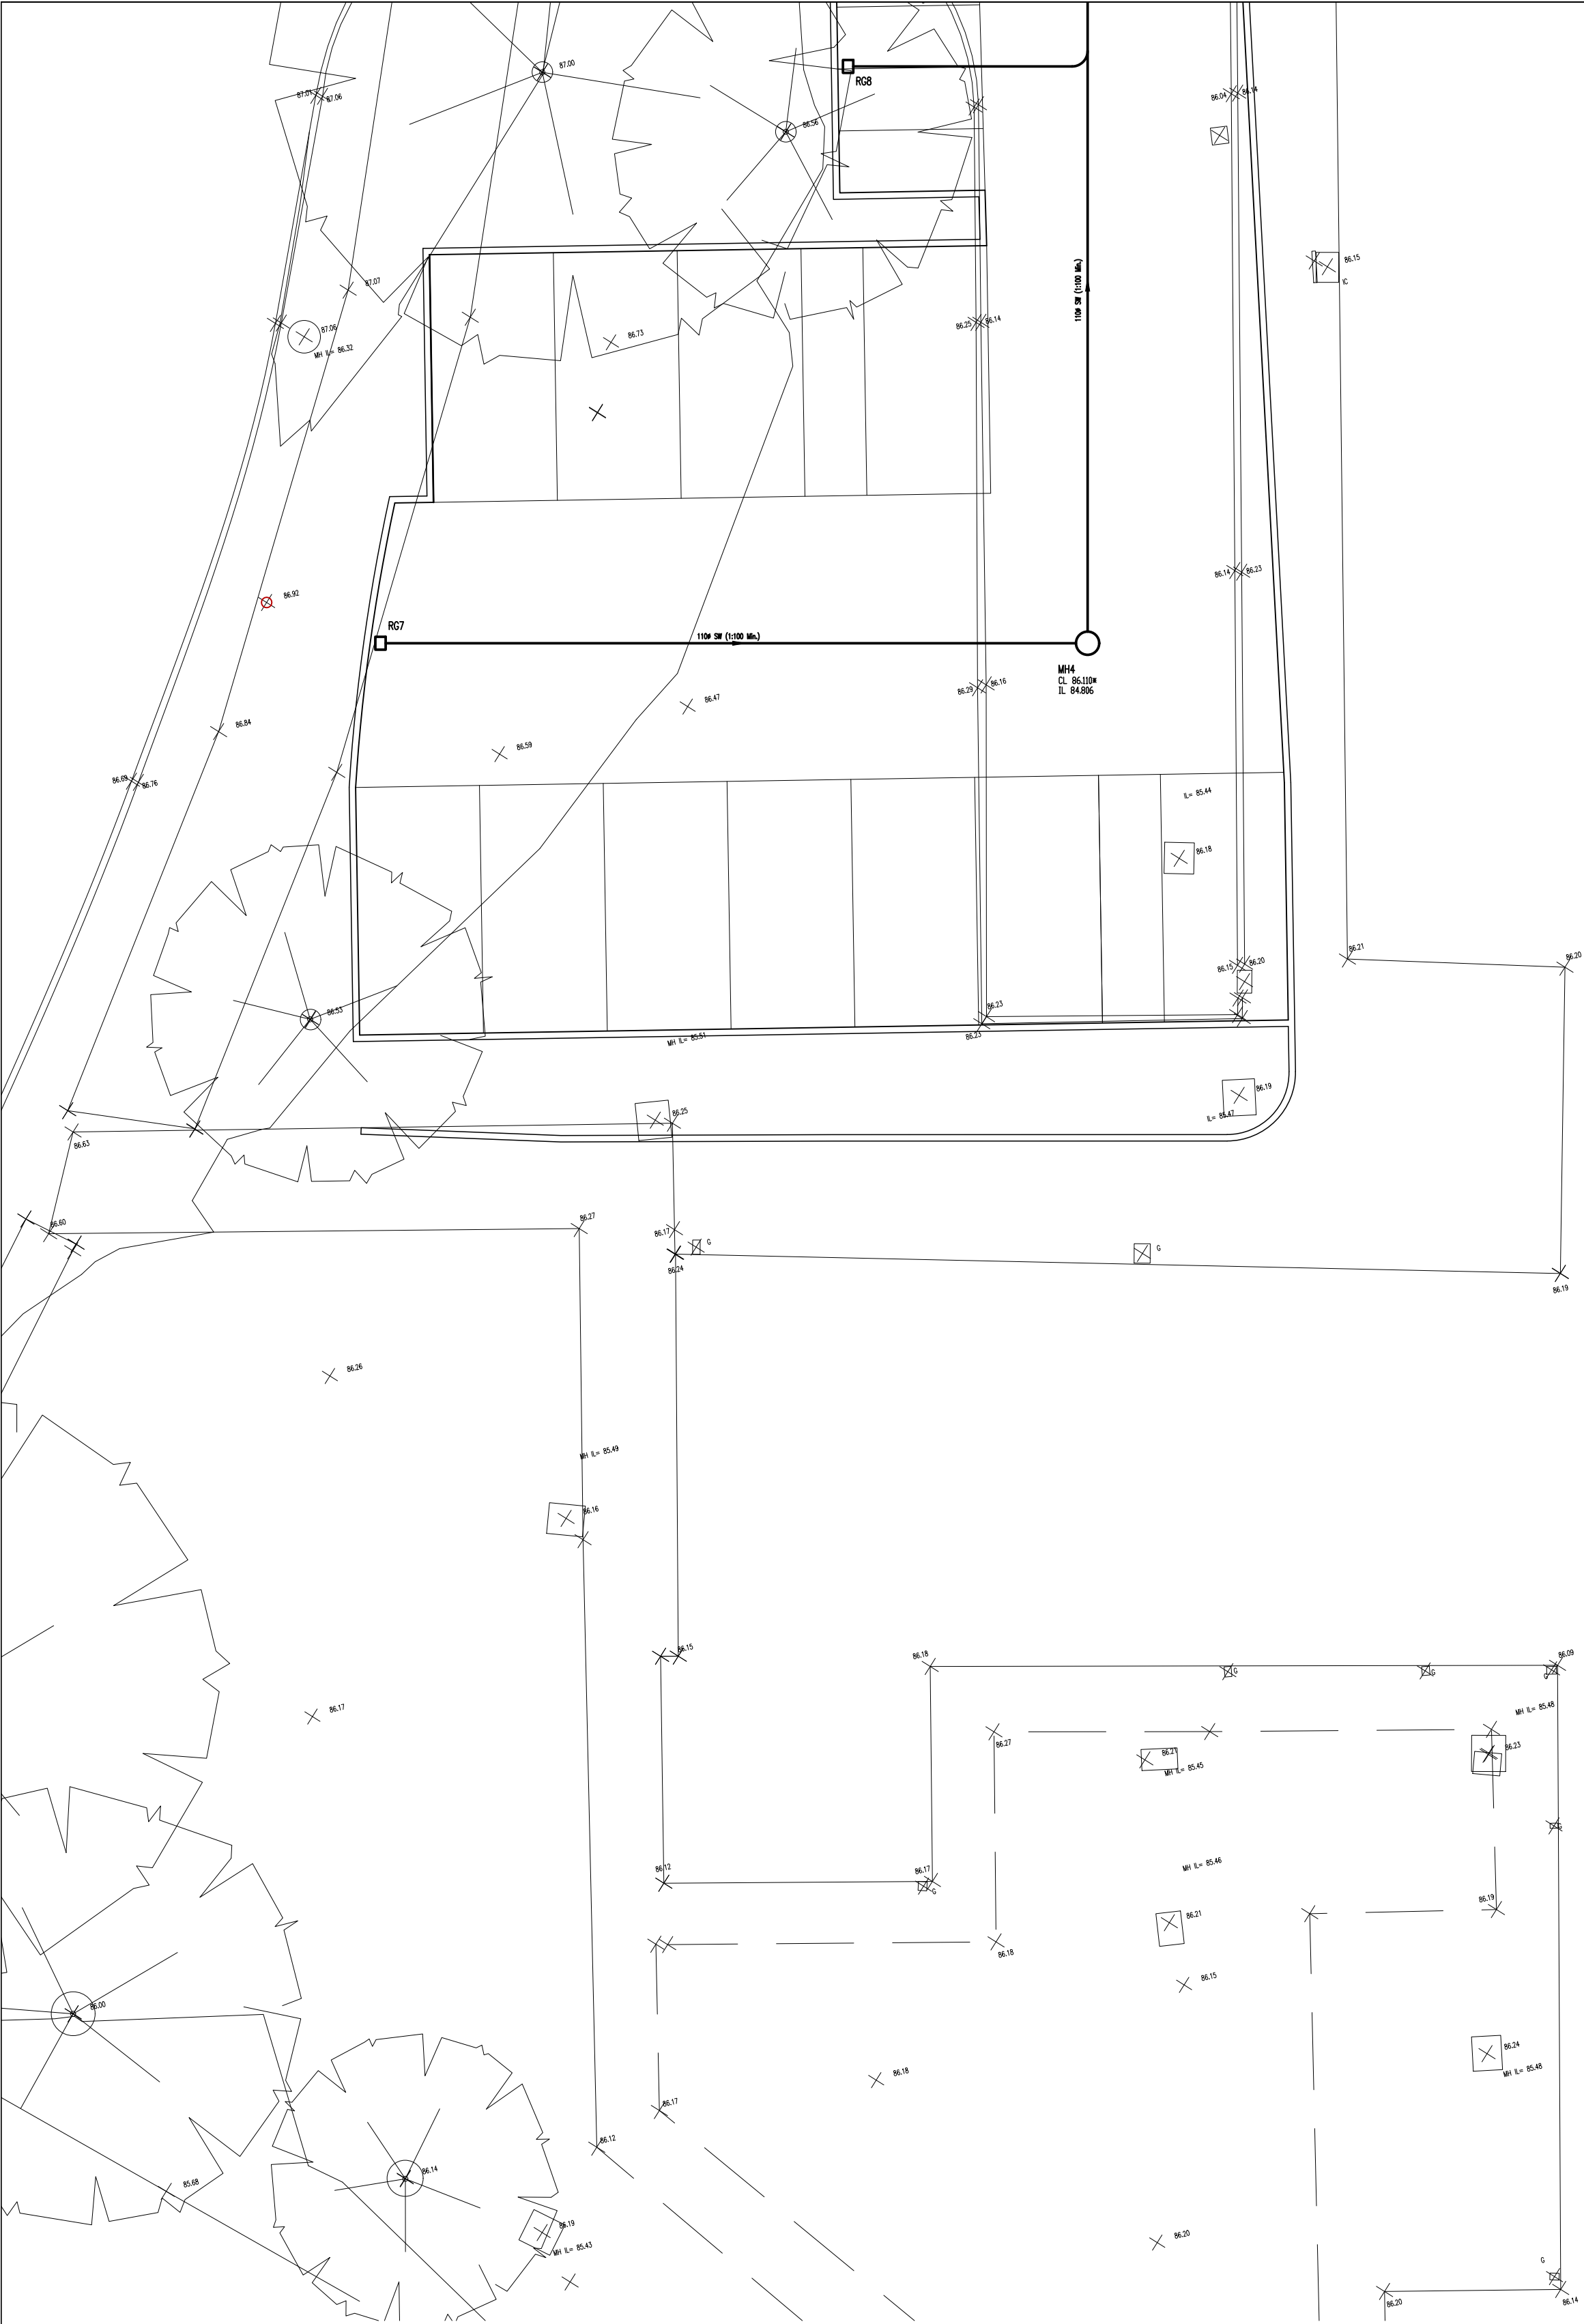

Drainage Specification

- 1 - Pipework to be either OSMA Drain 110mm or OSMA Drain 160mm, or similar, laid to a minimum fall of 1:80 or as shown on plan.
- 2 - Abbreviations used are:
IC - Inspection chamber
MH - Manhole
RE - Rodding eye
RG - Road Gully
SVP - Soil Vent Pipe
RWP - Rainwater downpipe
- 3 - Main drain runs to connect to IC or MH tail or via a radiused bend adjacent to tail.
- 4 - All RWP's provided with trapped gullies and rodding access.
- 5 - Cover, invert and car park surface levels subject to confirmation.

Proposed Drainage Layout - Sheet No. 1 of 2
Scale 1:100

NOTES

Copyright of this drawing remains with MBC Designs.
Do not scale from this drawing.
Dimensions marked "*" shall be checked on site by the Contractor prior to the commencement of work on site.
Dimensional discrepancies shall be notified to MBC Designs.

02/24		Gully locations adjusted	
Rev	Date	Description	
		MBC Designs Building Design Service 26 Gloucester Road, Wyton-On-The-Hill, Huntingdon, Cambs. PE28 2HF Tel. No. - 07986 115913 E-mail - mrvandem@btol.co.uk	
Dentholme, Cragg Road, Cleator Moor, CA25 5PR Hotel Conversion			
Drainage Layout – Sheet No. 1 Of 2			
DRAWN MRV		CHECKED	DRG No.
SCALES 1:100		DATE June 2023	0010121-20
ACAD FILE No. 0010121			
			REV A
			©Copyright