


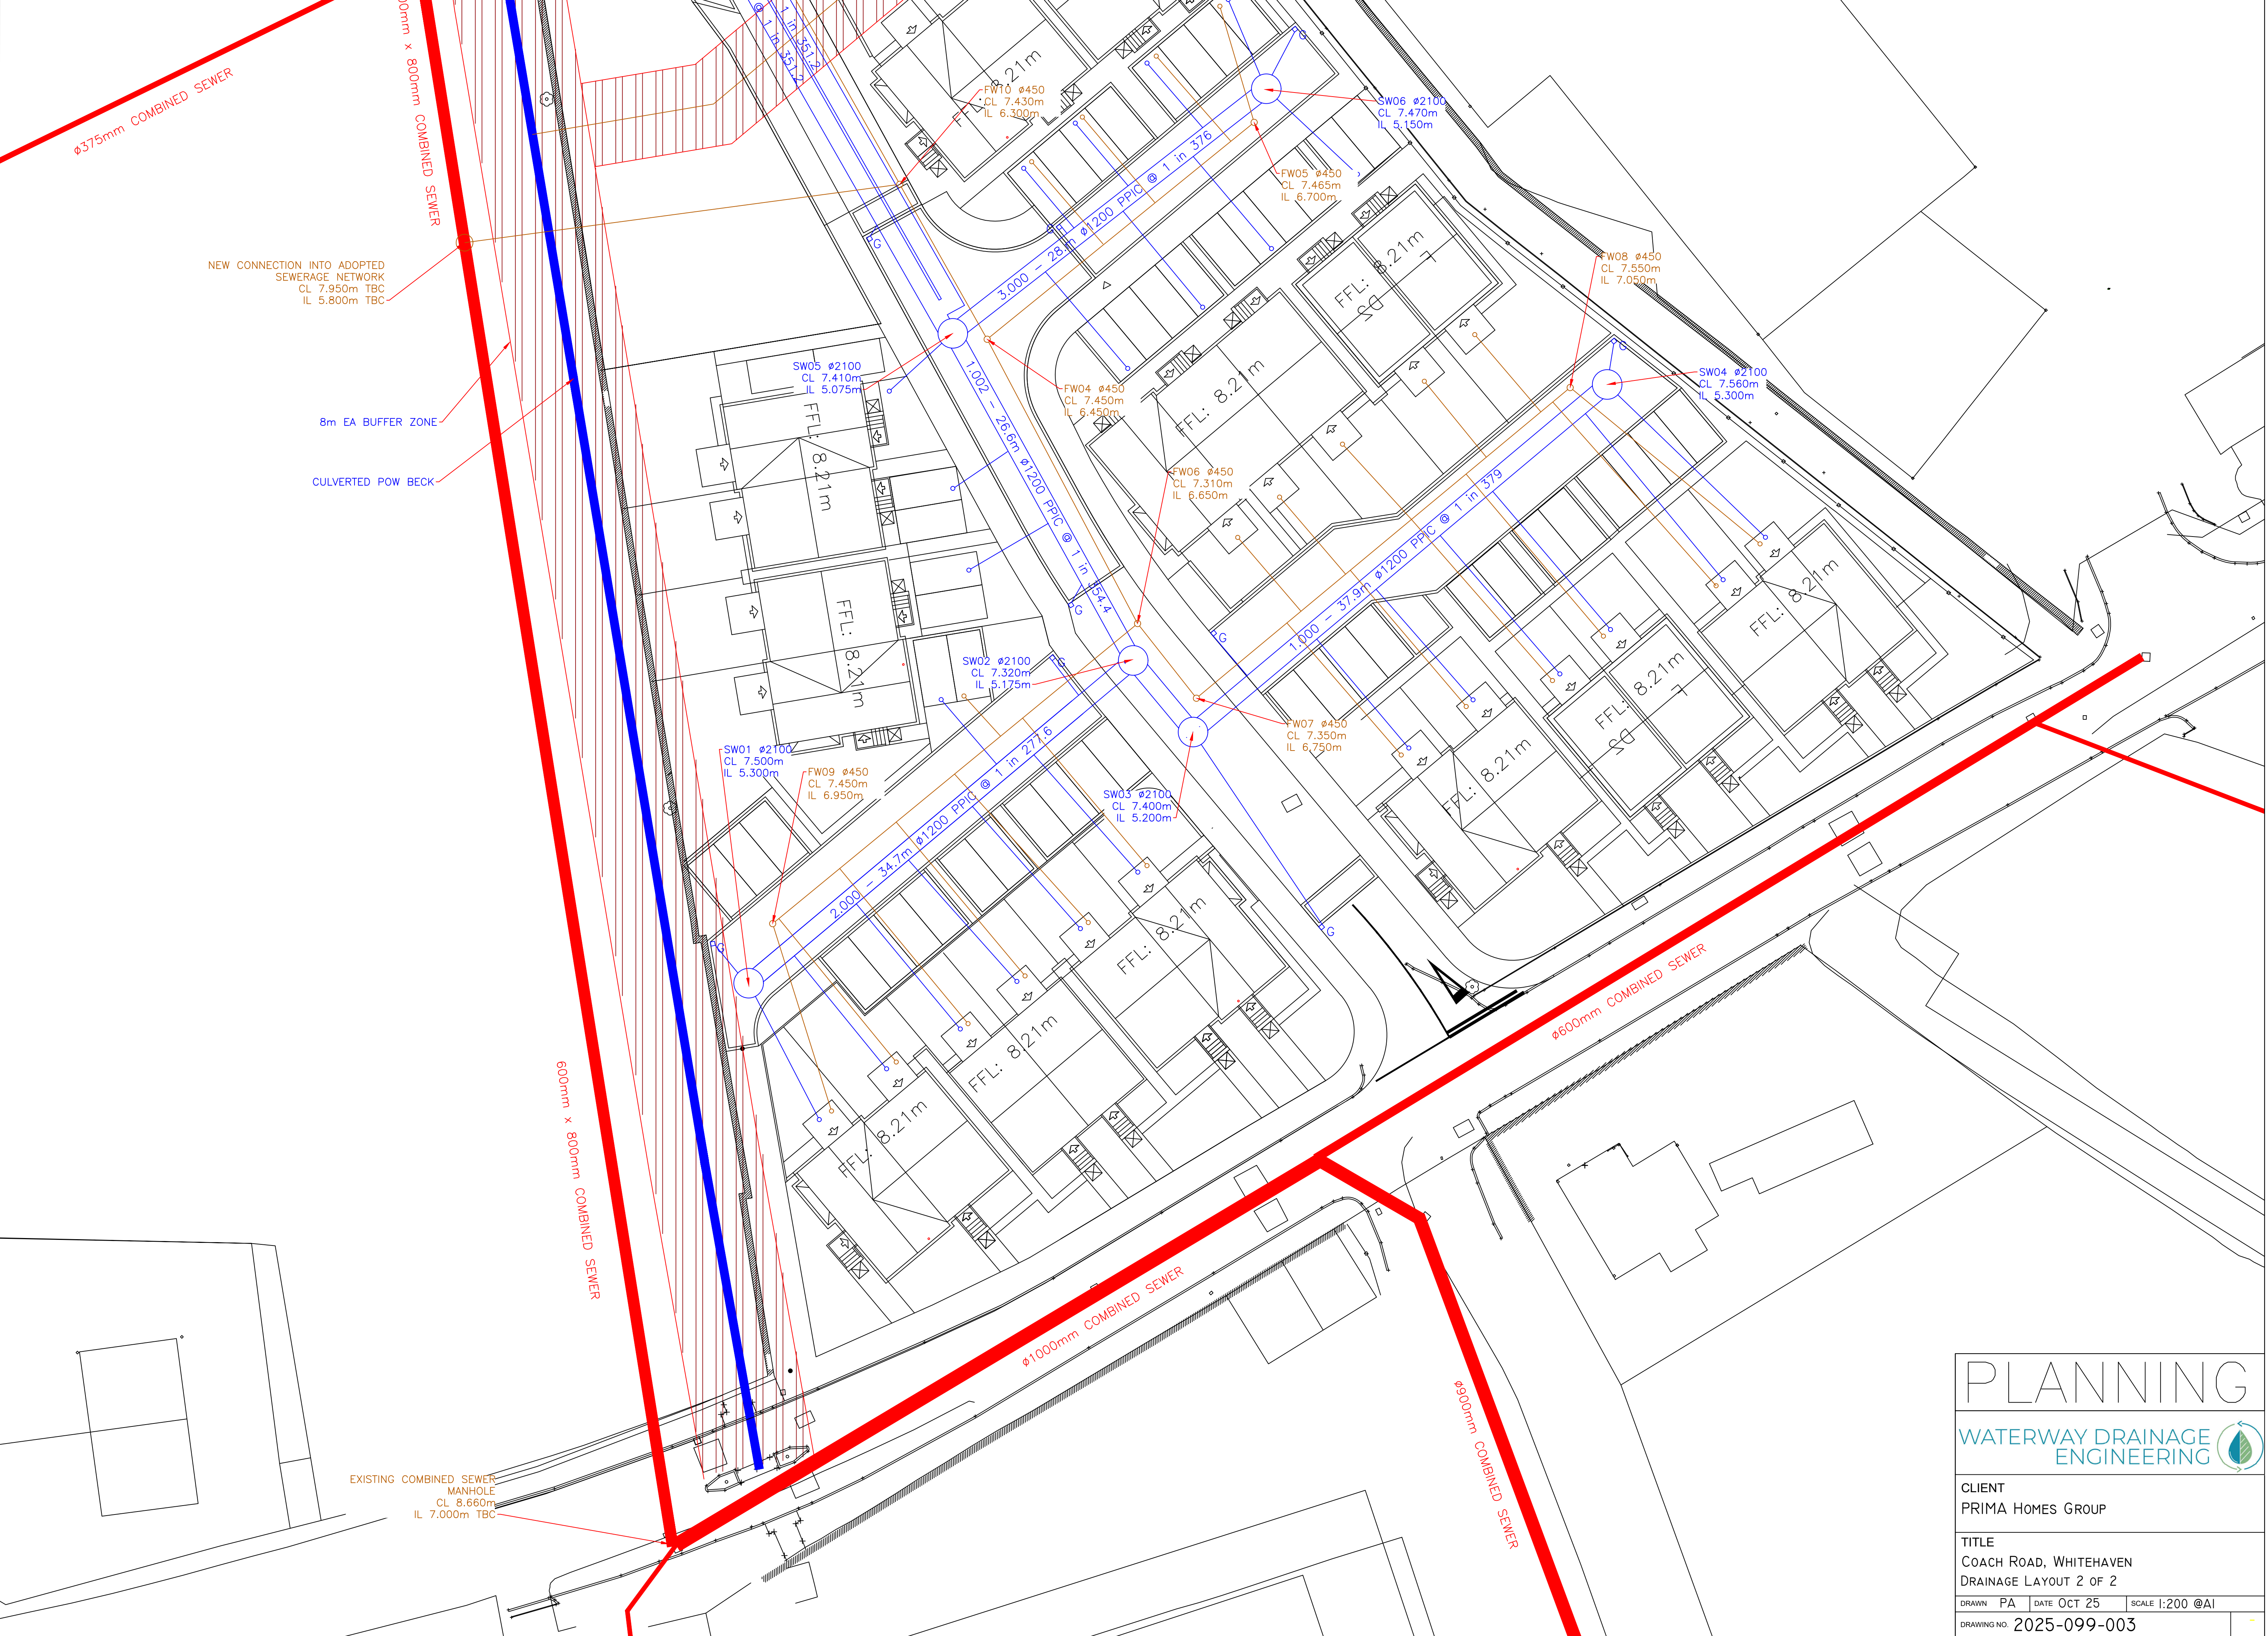

# PLANNING

WATERWAY DRAINAGE  
ENGINEERING

CLIENT  
PRIMA HOMES GROUP

TITLE  
COACH ROAD, WHITEHAVEN  
DRAINAGE LAYOUT 2 OF 2

DRAWN PA DATE OCT 25 SCALE 1:200 @A1  
DRAWING NO. 2025-099-003