


UPVC PIPE  
BEDDING CLASS 'E'

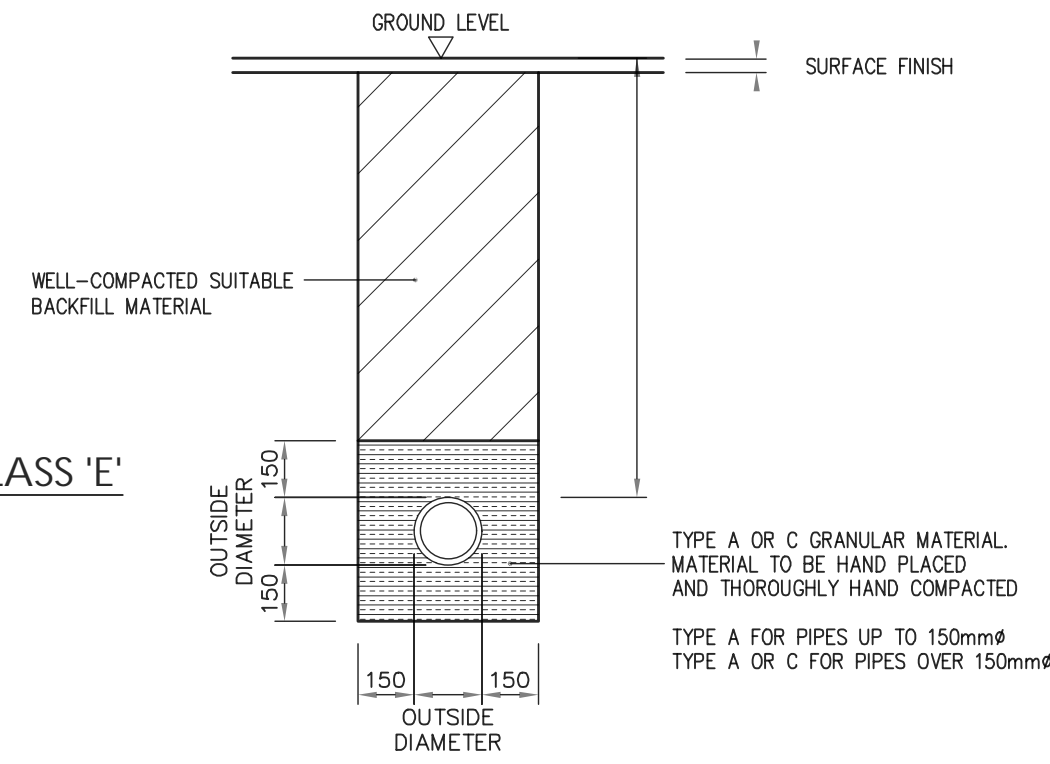

SCALE 1:20

- All works to be carried out in accordance with the following:-
1. UK water industry research Ltd. 'Civil Engineering Specification for the water Industry, 5th Edition.
  2. Building Regulations Section 'H'
  3. BE EN 752 Drain and Sewers Systems outside buildings.

- Foul Water: Falls in runs - 1:10 max - 1:60 min.
- All new drainage branches to be swept in direction of flow.
- All new drainage branches to be fitted with a RE.

SUDS

- All parking areas are to be constructed with a porous build up on free draining stone.
- All pods to have a 250mm wide by a min 200mm deep gravel border to both draining sides.

GLAMPitect

W: WWW.GLAMPITECT.CO.UK  
E: CONTACT@GLAMPITECT.CO.UK  
T: 0131 202 9002


KEY TO SYMBOLS

- DRAINAGE RUN
- IC INSPECTION CHAMBER
- SC SAMPLE CHAMBER
- ▨ WATER TREATMENT PLANT

Date	Description	Rev	By
21/11/22	Existing & Finishing floor levels.	B	TA
12/10/22	Amended location of drainage per comments.	A	TA

Revision Description

LOCATION PLAN 1:7500

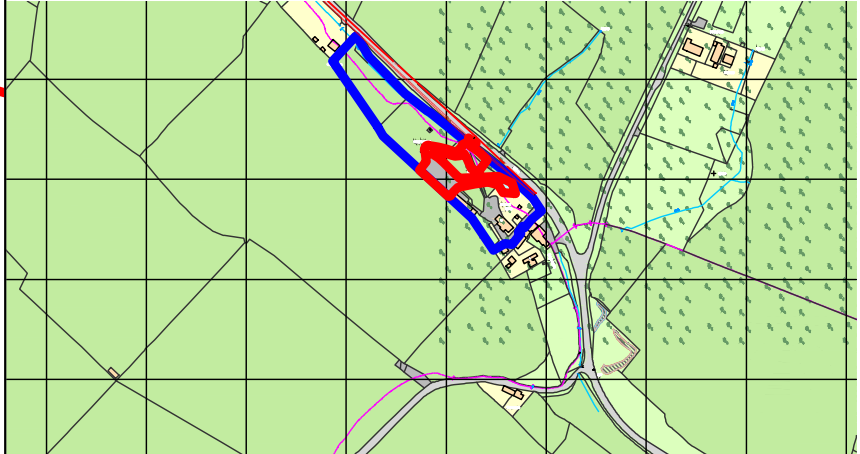

Project:  
Proposed Glamping Site For Gemma Waghorn  
5 Ellerbeck Barns, Egremont Road, Egremont Cumbria  
CA222UA

Drawing Title:  
PROPOSED DRAINAGE PLAN

Drawing Number:  
210825-01-04

Revision: B  
Date: 11-10-21  
Scale: 1:100 @ A1  
Drawn By: -  
CAD Dwg File: TA  
Checked By:

Issue Status:  
Full Planning Application

NORTH

