
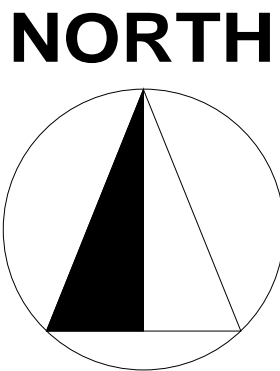


OWNERSHIP BOUNDARY

SITE BOUNDARY

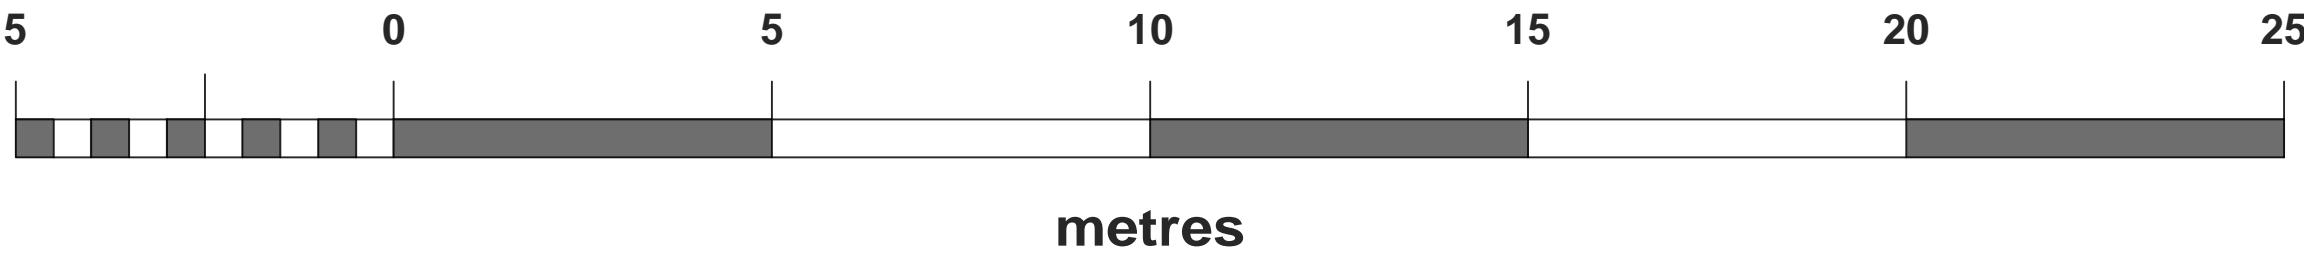

Low Level Path Lighting

Lanea Path Lighting Bollard with PIR sensor.

Benefits :

- LED mains wired.
- Low level height, only 40cm high.
- LED bulbs installed into this pillar lamp are in such a manner that they shine downwards onto cascading reflectors, keeping all light at low level.
- Integrated PIR sensor, keeping light levels low and only on when required.
- Range 2-8metres, set at 5m as shown.
- Lighting duration (5 seconds to 6 minutes) are configurable.
- Detects movement at an angle of 90 degrees .



KEY TO SYMBOLS

LOW LEVEL LIGHTING BOLLARD
10no. TO BE INSTALLED
LIGHTING SPREAD SHOWN AS 5m

Date	Description	Rev	By
Revision Description			

LOCATION PLAN 1:7500

Project:
Proposed Glamping Site For Gemma Waghorn
5 Ellerbeck Barns, Egremont Road, Egremont Cumbria
CA222UA

Drawing Title:
LIGHTING PLAN

Drawing Number:
210825-01-08

Revision:
Date: 11-10-21
Scale: 1:100 @ A1
Drawn By: TA
CAD Dwg File: -
Arch. Base Dwg:

Issue Status:
Full Planning Application