

 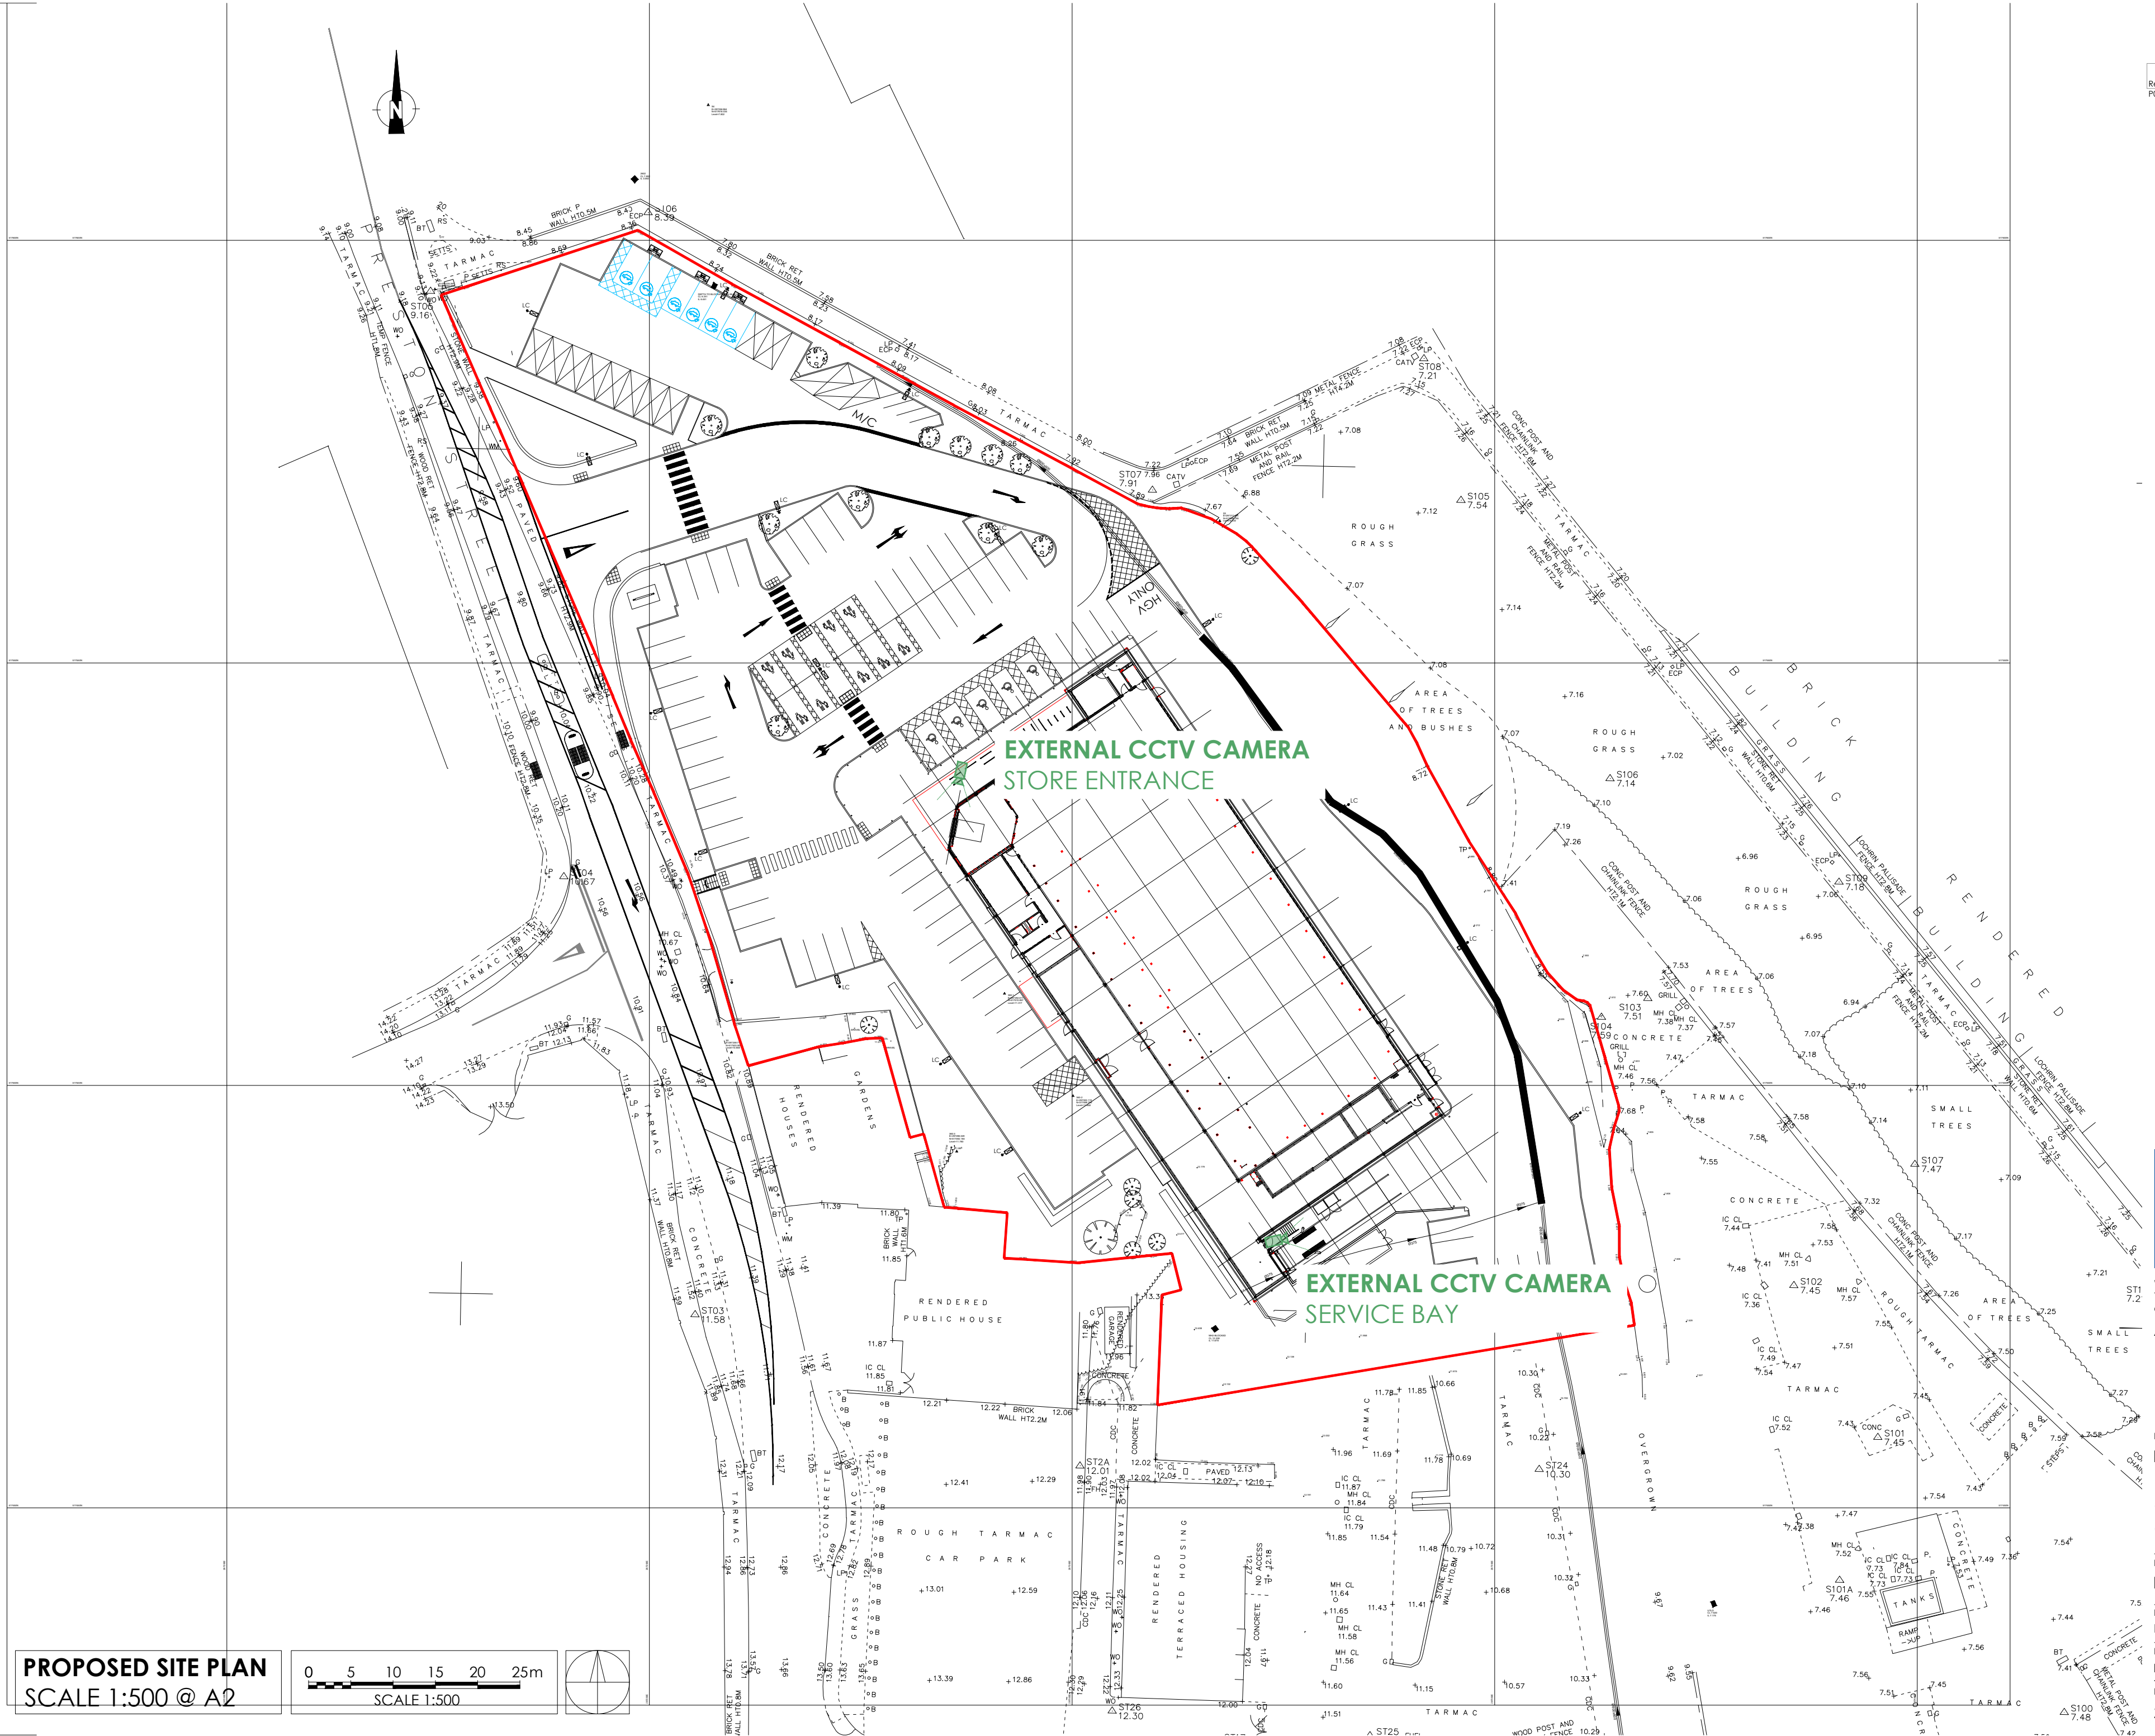


Rev	Date	Description	Drawn	Chk'd
P01	21.01.25	FIRST ISSUE	RG	RM

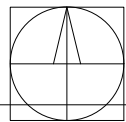

PROPOSED SITE PLAN
SCALE 1:500 @ A2



Architecture
Masterplanning
Interior Design

www.harrispartnership.com

Wakefield Manchester Milton Keynes Reading London Harrogate Edinburgh

Client
ALDI STORES LTD

Project Title
PROPOSED ALDI FOODSTORE

**PRESTON STREET
WHITEHAVEN
CA28 9BS**

Drawing Title
EXTERNAL CCTV LAYOUT

Drawn	Checked	Scale @A2	BIM Status	Date
RG	RM	1:500	NA	01.26

Drawing Status	Rev.	THP Project No
PLANNING	P01	21340

Project No.	Originator	Volume	Level	Type	Role	Number
21340	THPW	XX	XX	DR	A	1100