


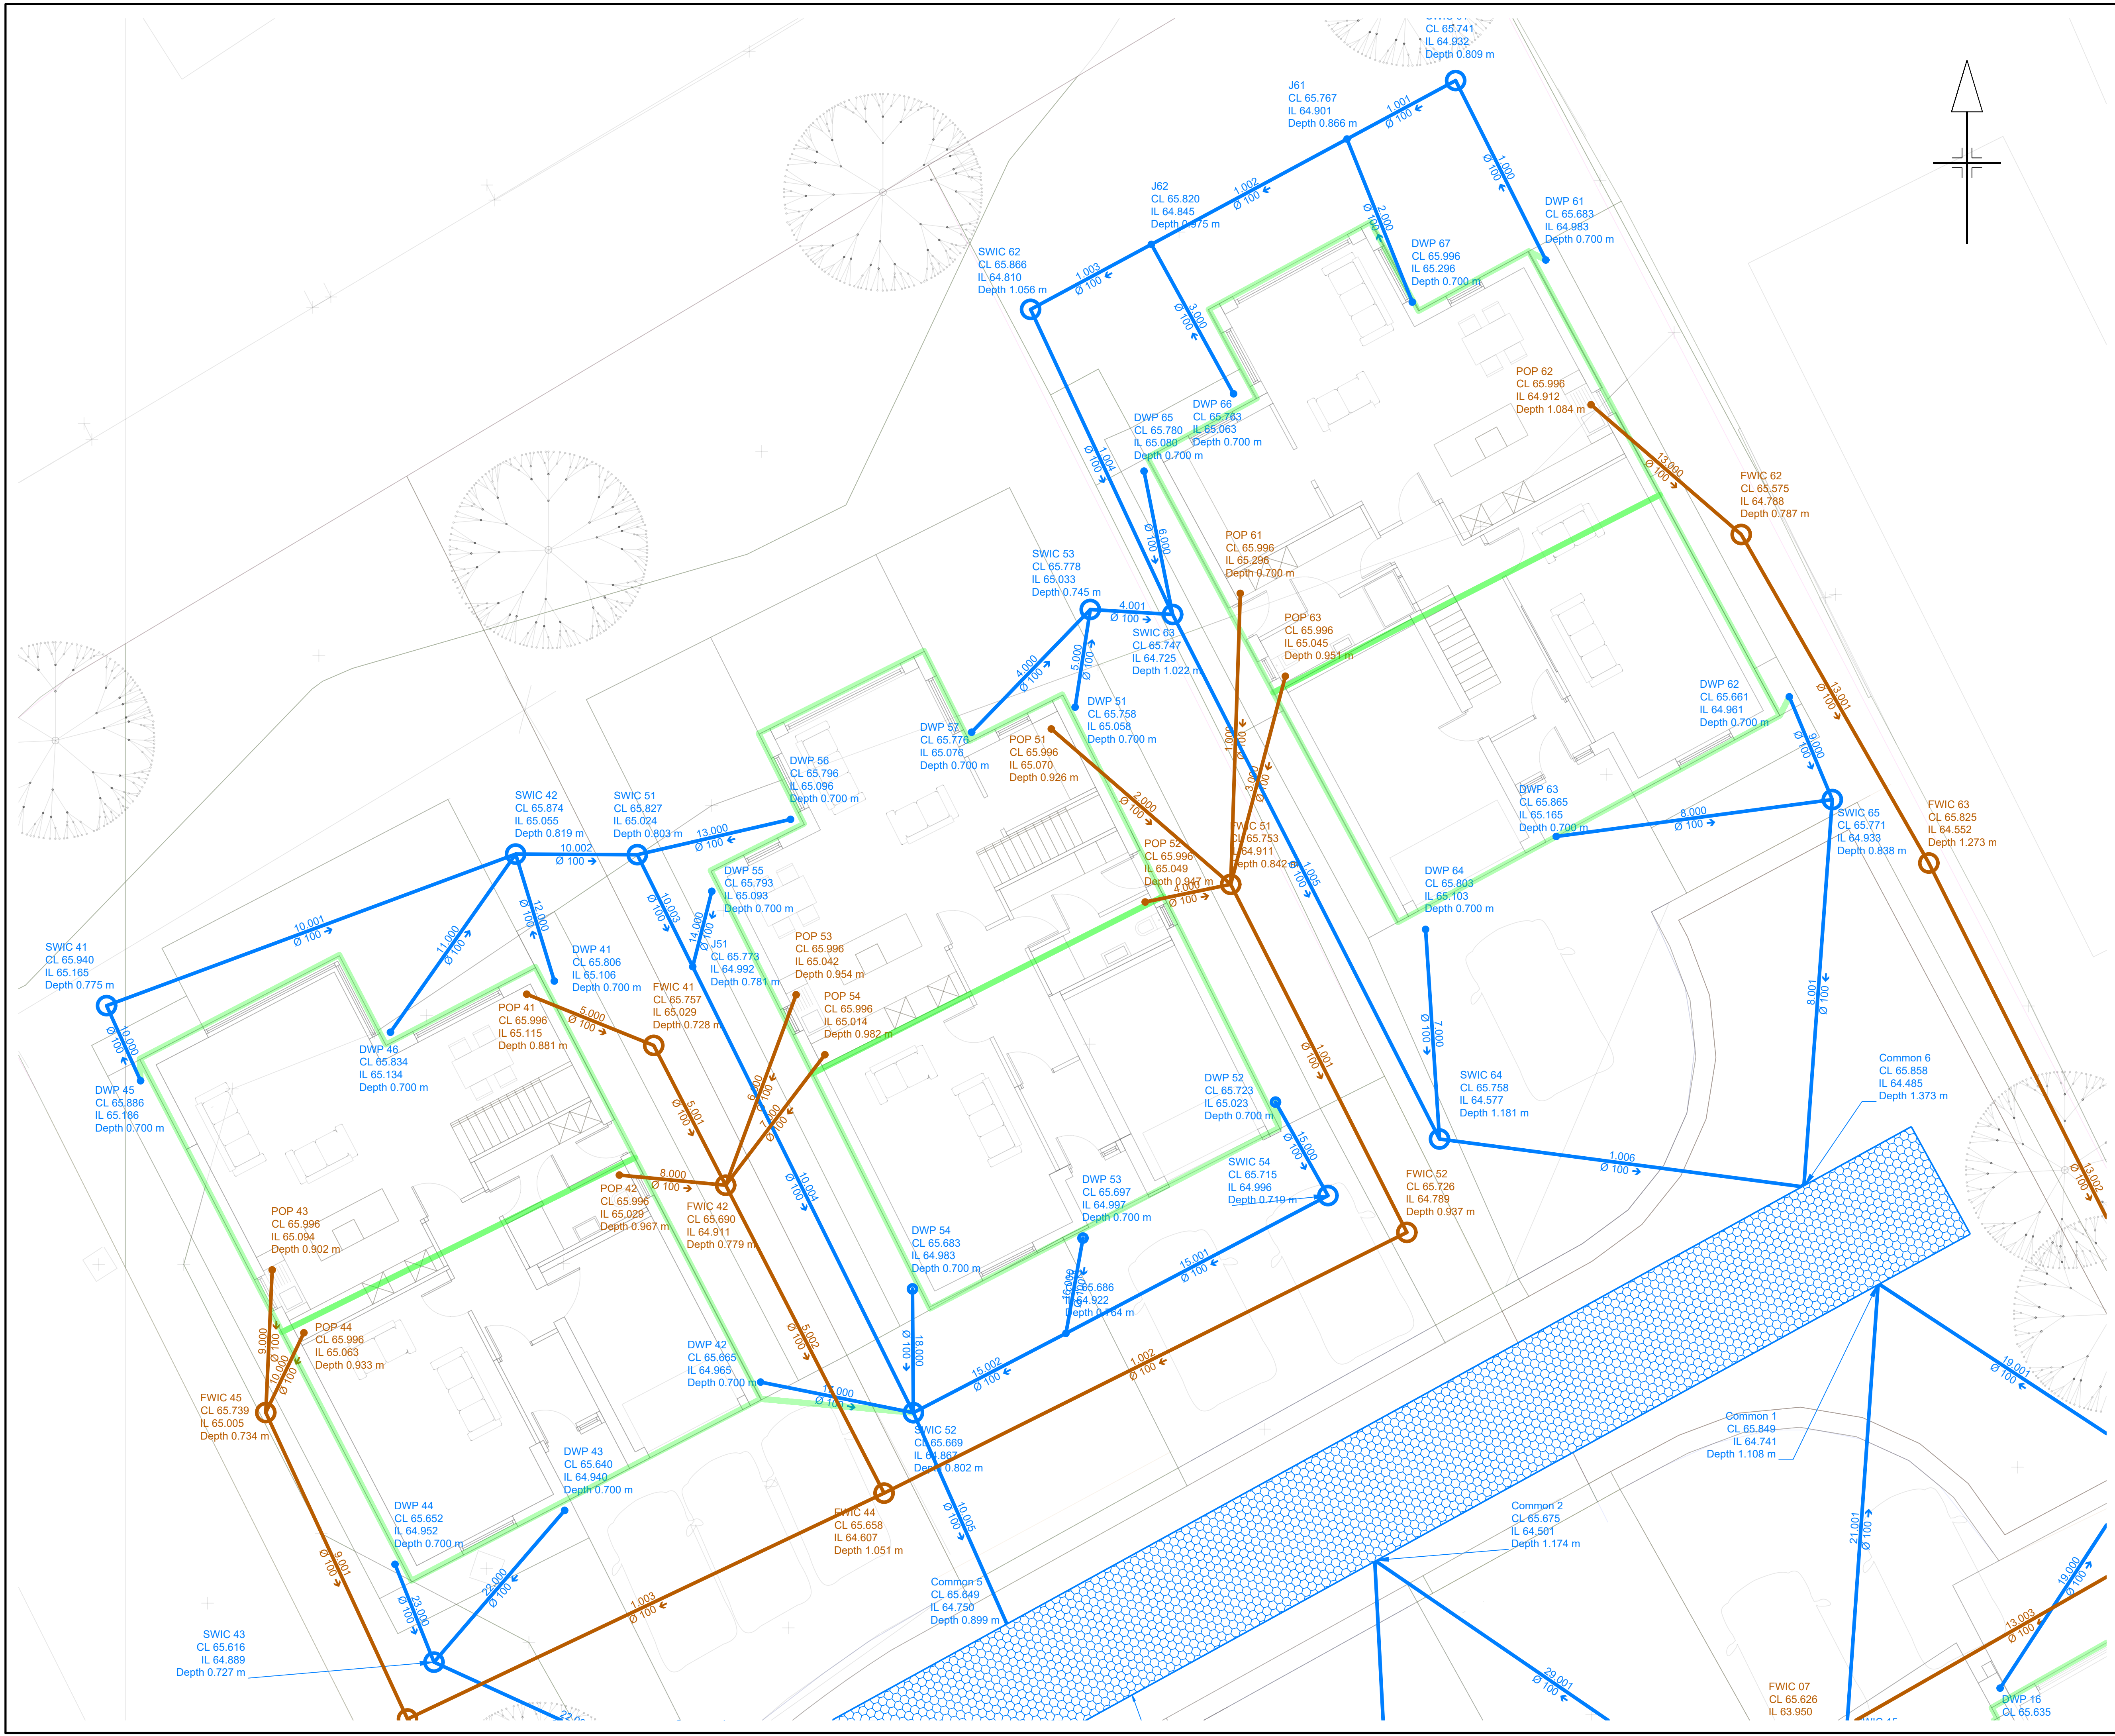

LEGEND

- Proposed Surface water drainage
- Proposed Foul drainage
- Proposed combined drain
- Existing combined sewer
- Impermeable catchment areas

03	27-06-25	Redesign with new site layout	PE	MTY	MTY
02	13-06-25	REDESIGN WITH ATTENUATION	PE	MTY	MTY
01	05-02-25	FIRST ISSUE	PE	MTY	MTY
Rev.	Date	Description	By	Chkd	Appd

The Drainage Designers

90 Coronation Street, Sunderland, SR1 2HE

Drawing Status	FOR CONSTRUCTION	Suitability	C4
----------------	------------------	-------------	----

Project Title

CROSS GROVE

Drawing Title

PROPOSED DRAINAGE LAYOUT 1 of 3

Scale	1:75	Designed	PE	Drawn	PE	Checked	MTY	Authorised	MTY	
Original Size	A1	Date	06-02-25	Date	06-02-25	Date	06-02-25	Date	06-02-25	
Drawing Number	5075-DD-XX-XX-DR-D-0001								Revision	03