


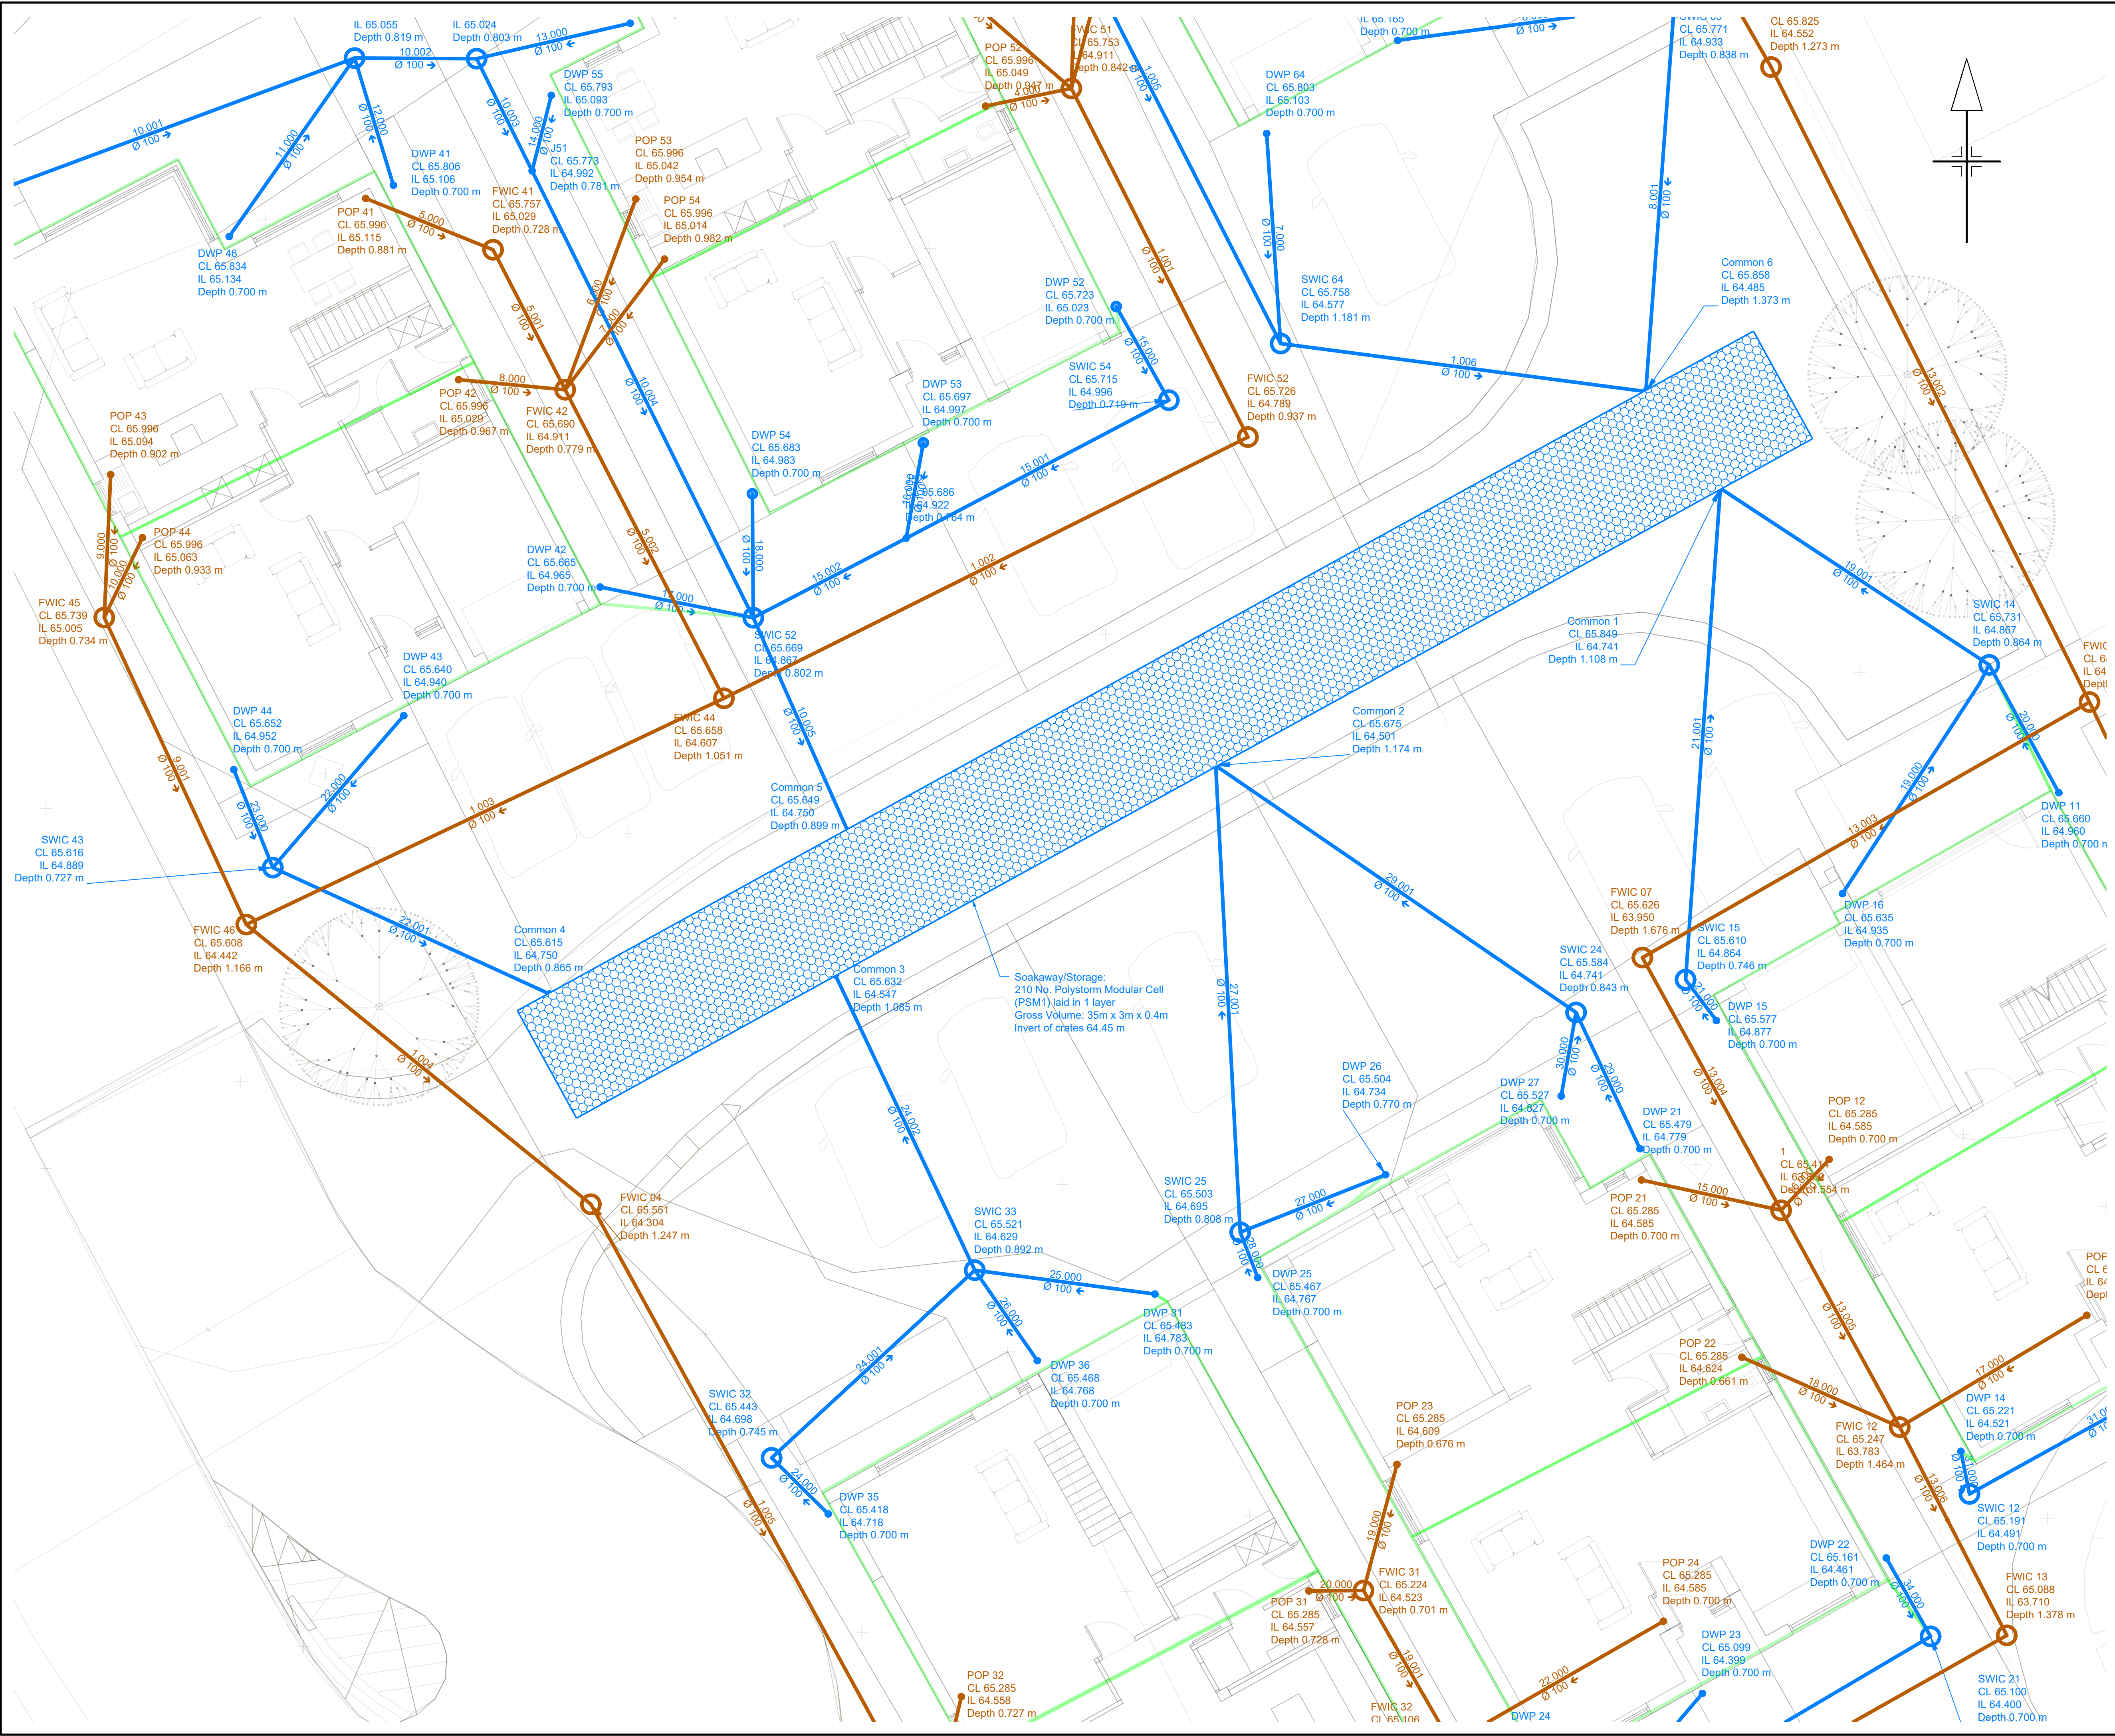

LEGEND

- Proposed Surface water drainage
- Proposed Foul drainage
- Proposed combined drain
- Existing combined sewer
- Impermeable catchment areas

03	27-06-25	Redesign with new site layout	PE	MTY	MTY
02	13-06-25	REDESIGN WITH ATTENUATION	PE	MTY	MTY
01	05-02-25	FIRST ISSUE	PE	MTY	MTY
Rev.	Date	Description	By	Chkd	Appd

The Drainage Designers

90 Coronation Street, Sunderland, SR1 2HE

Drawing Status	FOR CONSTRUCTION	Suitability	C4							
Project Title	CROSS GROVE									
Drawing Title	PROPOSED DRAINAGE LAYOUT 2 of 3									
Scale	1:75	Designed	PE	Drawn	PE	Checked	MTY	Authorised	MTY	
Original Size	A1	Date	06-02-25	Date	06-02-25	Date	06-02-25	Date	06-02-25	
Drawing Number	5075-DD-XX-XX-DR-D-0002								Revision	03