


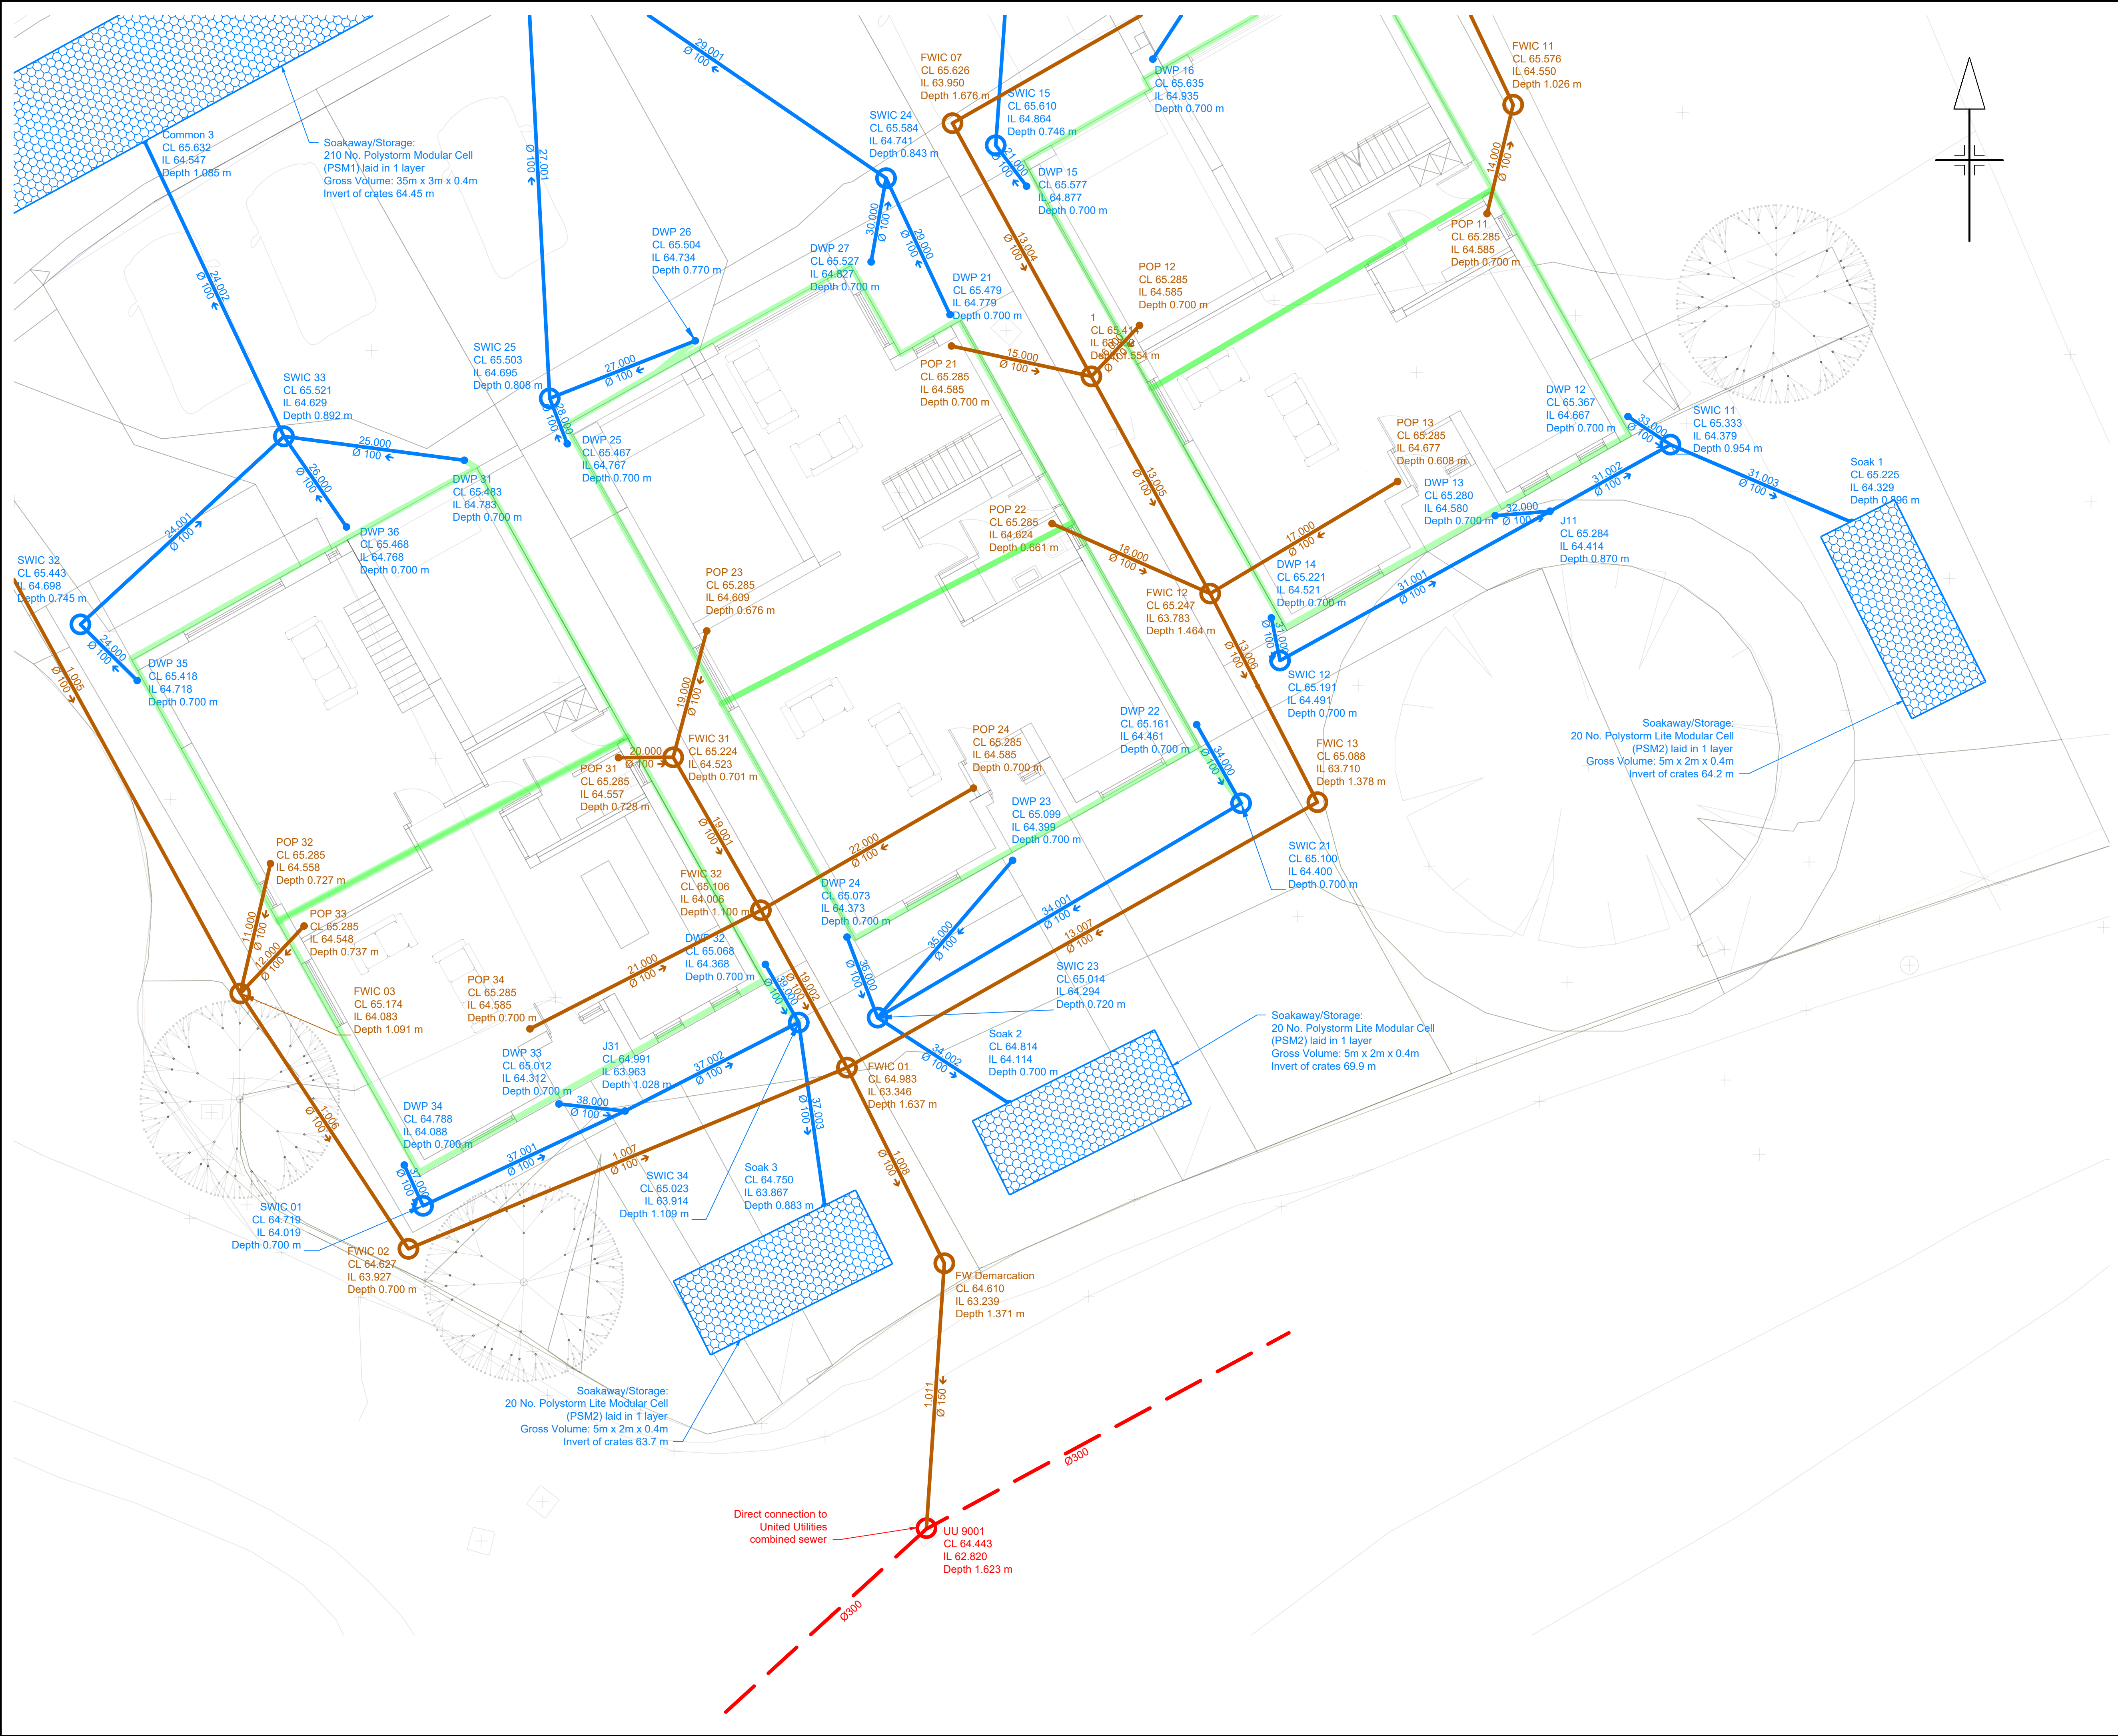

- LEGEND
- Proposed Surface water drainage
  - Proposed Foul drainage
  - Proposed combined drain
  - Existing combined sewer
  - Impermeable catchment areas

|      |          |                               |    |      |       |
|------|----------|-------------------------------|----|------|-------|
| 03   | 27-06-25 | Redesign with new site layout | PE | MTY  | MTY   |
| 02   | 13-06-25 | REDESIGN WITH ATTENUATION     | PE | MTY  | MTY   |
| 01   | 05-02-25 | FIRST ISSUE                   | PE | MTY  | MTY   |
| Rev. | Date     | Description                   | By | Chkd | App'd |

### The Drainage Designers

90 Coronation Street, Sunderland, SR1 2HE

|                |                  |             |    |
|----------------|------------------|-------------|----|
| Drawing Status | FOR CONSTRUCTION | Suitability | C4 |
|----------------|------------------|-------------|----|

|               |             |
|---------------|-------------|
| Project Title | CROSS GROVE |
|---------------|-------------|

|               |                                 |
|---------------|---------------------------------|
| Drawing Title | PROPOSED DRAINAGE LAYOUT 3 of 3 |
|---------------|---------------------------------|

|               |      |          |          |       |          |         |          |            |          |
|---------------|------|----------|----------|-------|----------|---------|----------|------------|----------|
| Scale         | 1:75 | Designed | PE       | Drawn | PE       | Checked | MTY      | Authorised | MTY      |
| Original Size | A1   | Date     | 06-02-25 | Date  | 06-02-25 | Date    | 06-02-25 | Date       | 06-02-25 |

|                |                         |          |    |
|----------------|-------------------------|----------|----|
| Drawing Number | 5075-DD-XX-XX-DR-D-0003 | Revision | 03 |
|----------------|-------------------------|----------|----|