


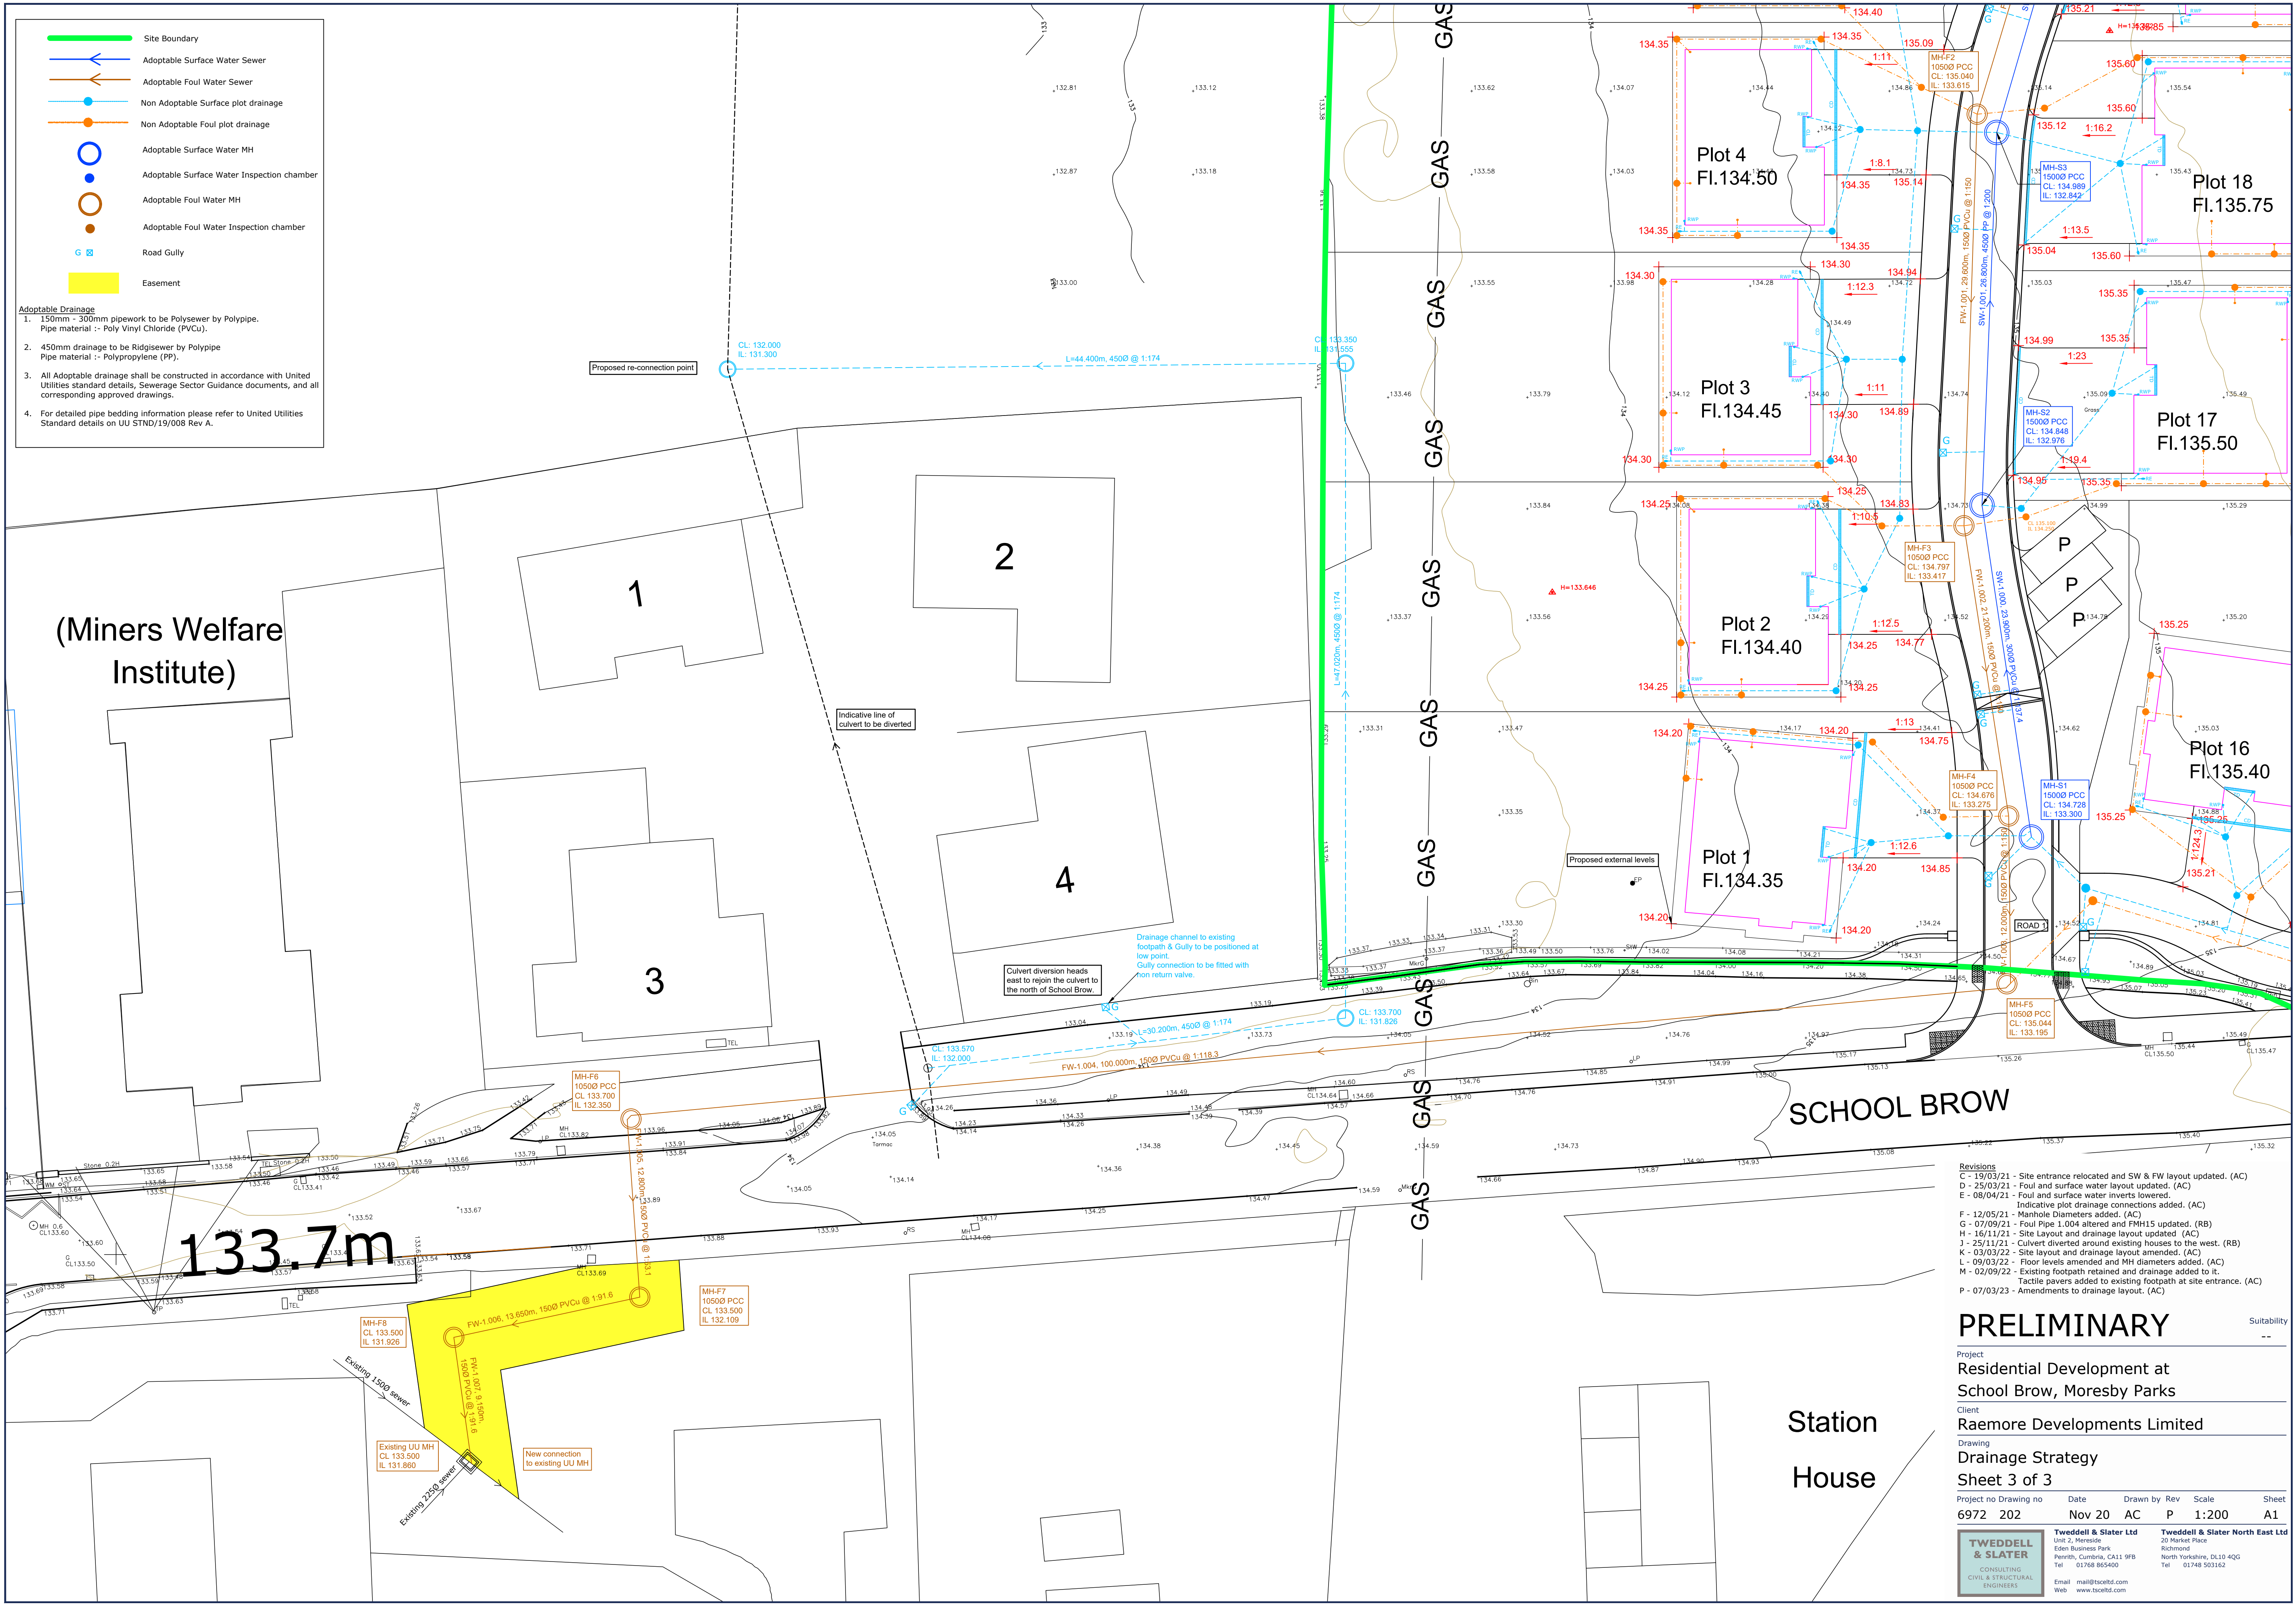

Revisions	
C - 19/03/21	- Site entrance relocated and SW & FW layout updated. (AC)
D - 25/03/21	- Foul and surface water layout updated. (AC)
E - 08/04/21	- Indicative plot drainage connections added. (AC)
F - 12/05/21	- Manhole Diameters added. (AC)
G - 07/09/21	- Foul Pipe 1.004 altered and FMH15 updated. (RB)
H - 16/11/21	- Site Layout and drainage layout updated. (AC)
J - 25/11/21	- Culvert diverted around existing houses to the west. (RB)
K - 03/03/22	- Site layout and drainage layout amended. (AC)
L - 09/03/22	- Floor levels amended and MH diameters added. (AC)
M - 02/09/22	- Existing footpath retained and drainage added to it. Tactile pavers added to existing footpath at site entrance. (AC)
P - 07/03/23	- Amendments to drainage layout. (AC)

PRELIMINARY

Project	
Residential Development at School Brow, Moresby Parks	
Client	
Raemore Developments Limited	
Drawing	
Drainage Strategy	
Sheet 3 of 3	
Project no	Drawing no
6972	202
Date	Nov 20
Drawn by	AC
Rev	P
Scale	1:200
Sheet	A1

TWEDDELL & SLATER CONSULTING CIVIL & STRUCTURAL ENGINEERS	Tweddell & Slater Ltd Unit 2, Mereside Eden Business Park Penrith, Cumbria, CA11 9FB Tel 01768 865400 Email mail@tscedtld.com Web www.tscedtld.com	Tweddell & Slater North East Ltd 20 Market Place Richmond North Yorkshire, DL10 4QG Tel 01748 503162
	Suitability --	