


DO NOT SCALE

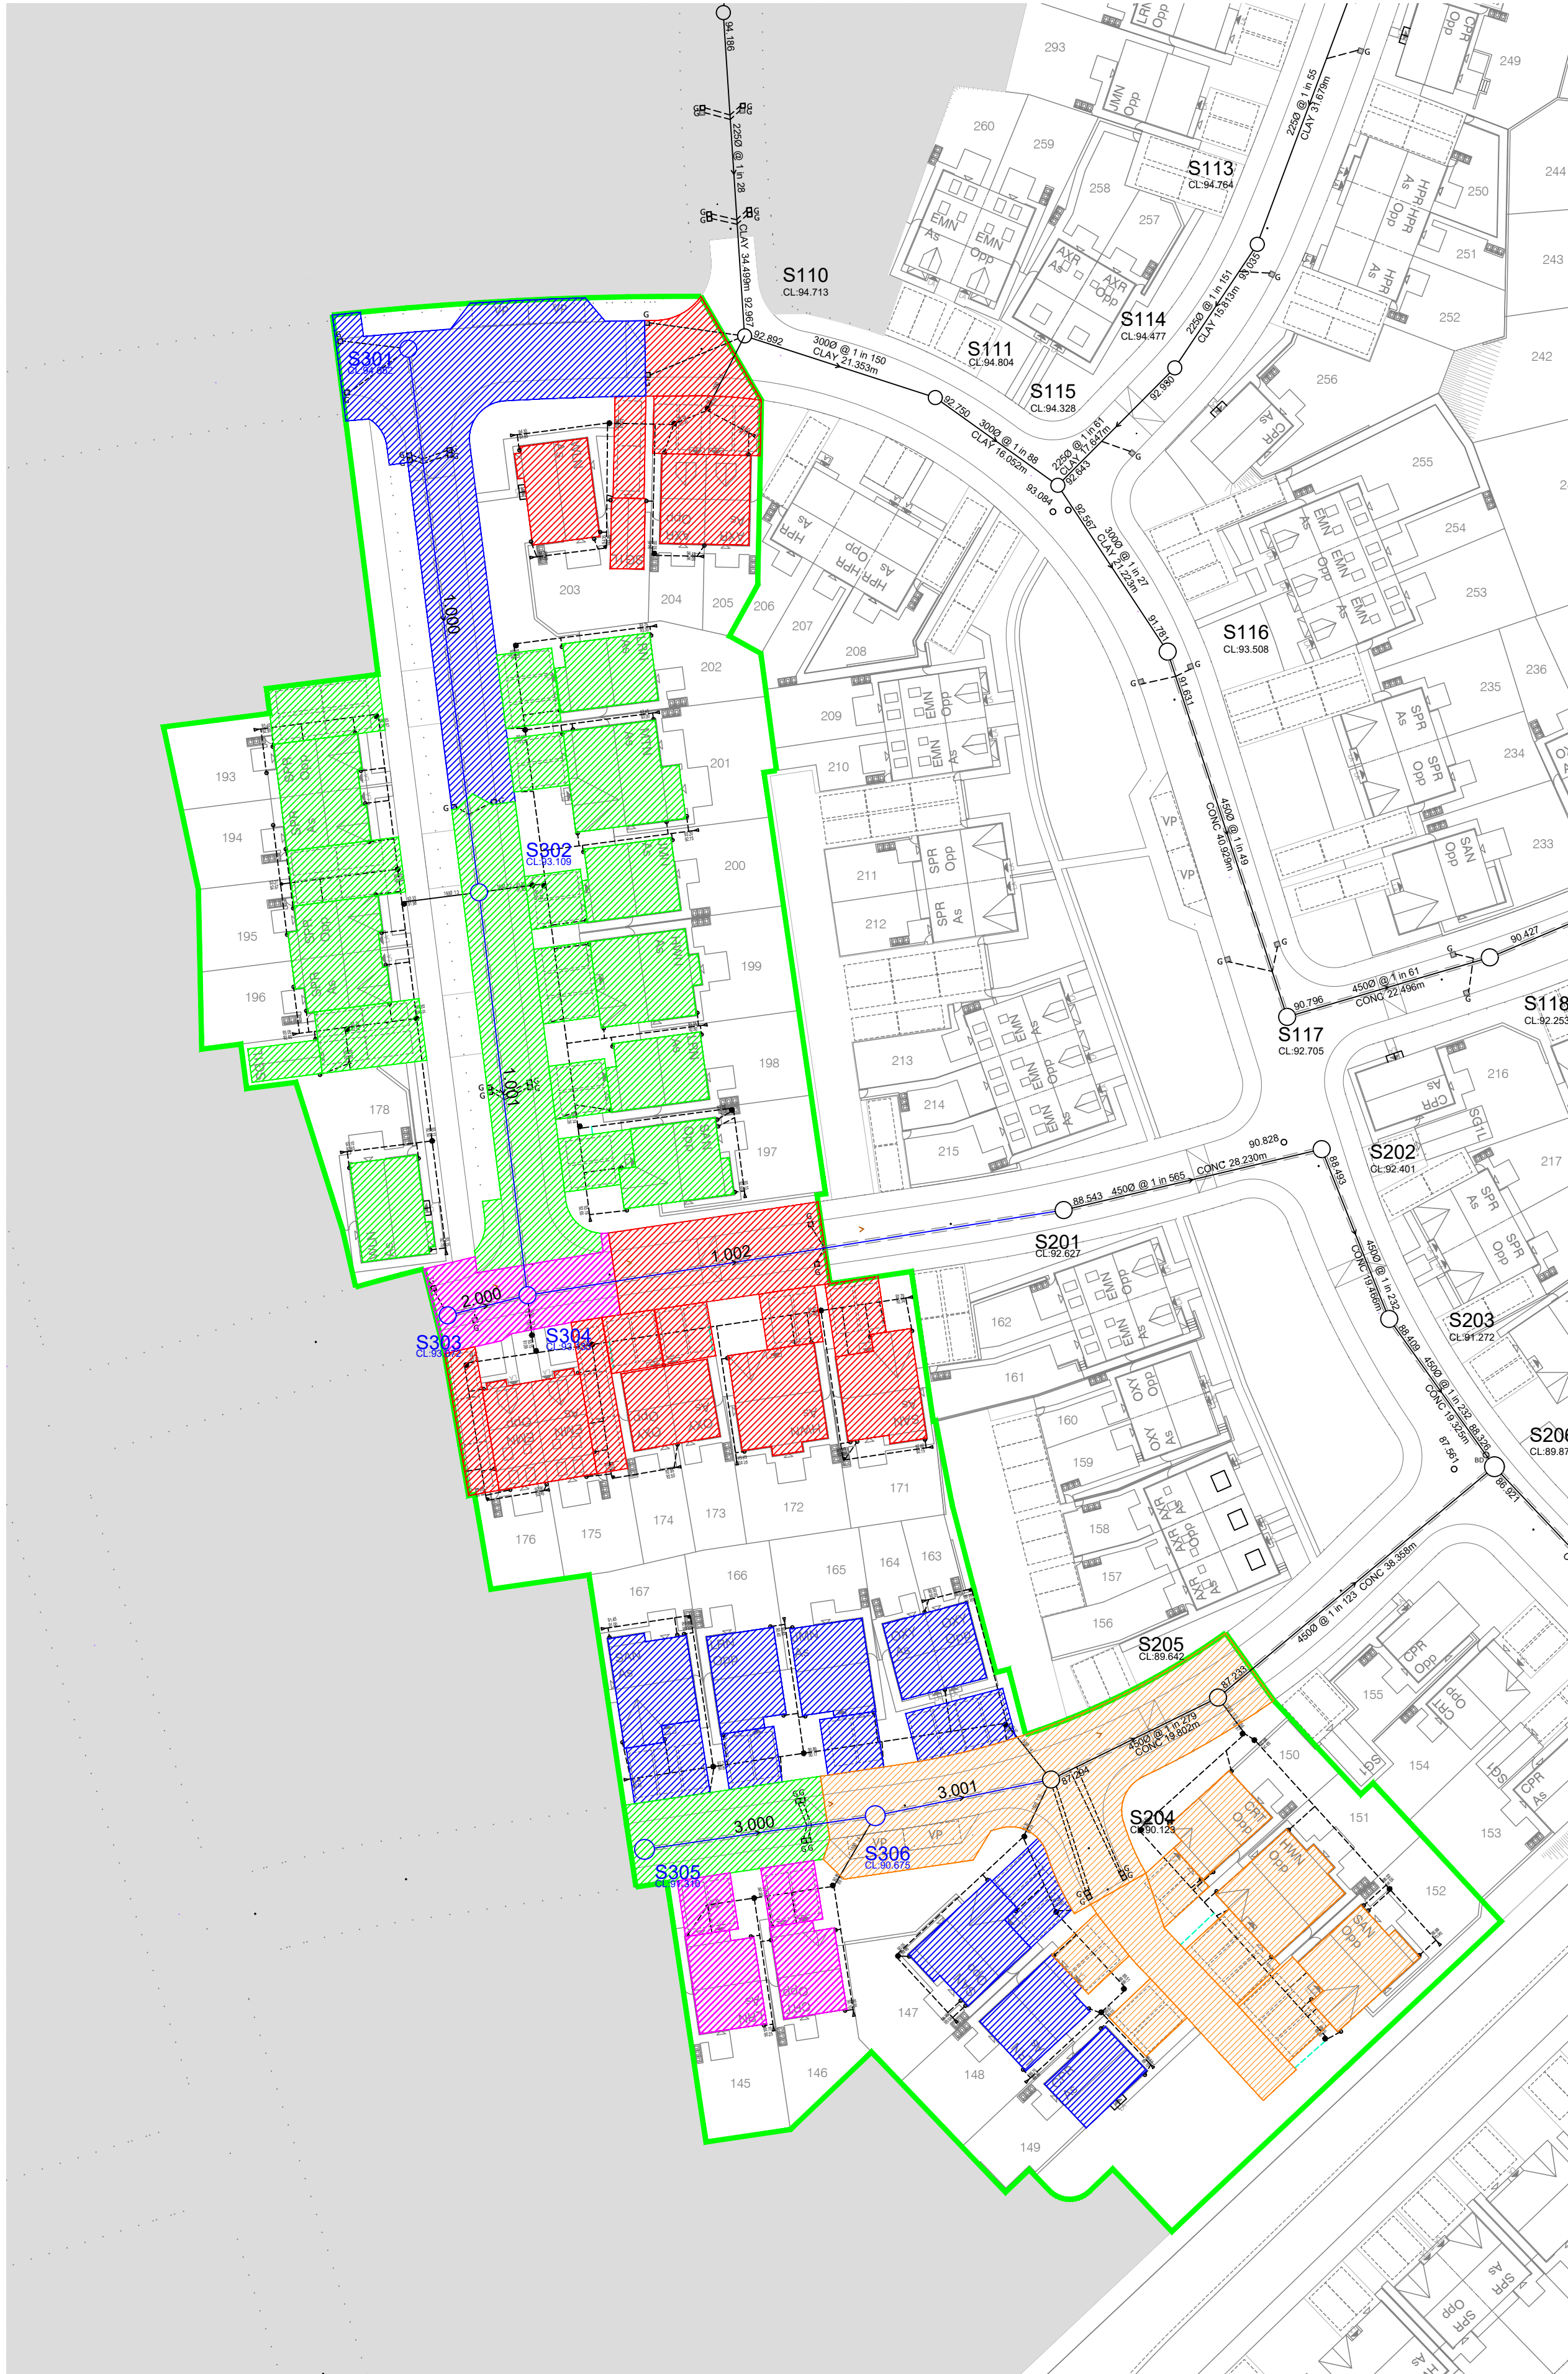

PIPE REF.	UIS MH REF.	IMPERMEABLE AREA	IMPERMEABLE AREA (+10%)
-	S110	390	430
-	S204	760	840
-	S205	1150	1270
1.000	S301	620	680
1.001	S302	1660	1830
2.000	S303	150	170
1.002	S304	830	910
3.000	S305	180	200
3.001	S306	210	230
TOTAL AREA		= 5.950m ²	= 6.560m ²

Design based on Layout:
Edgehill Park, Whitehaven Site Layout
Plan, 3b Master dated 24.08.22

Grid/Level datum based on Topo:
230720-EHP-SH-TOPO-001, Edgehill Park
Topographic Survey, dated 23.07.20
Rev: -

Coopers Drawing List:

- 7503-3B / 01 Proposed Drainage Layout
- 7503-3B / 02 Proposed Highway Setting Out
- 7503-3B / 03 Proposed Highway Layout
- 7503-3B / 04 Proposed Highway Longsections
- 7503-3B / 05 Highway Construction Details
- 7503-3B / 06 S38 Agreement Plan
- 7503-3B / 07 External Works Layout
- 7503-3B / 08 Private Drainage Layout
- 7503-3B / 09 Drainage Construction Details.
- 7503-3B / 10 Manhole Schedules
- 7503-3B / 11 Surface Water Manhole Details
- 7503-3B / 12 Surface Water Catchment Areas
- 7503-3B / 13 Proposed Cut and Fill Earthworks
- 7503-3B / 14 Surface Finishes

APPROVAL

coopers
chartered consulting engineers

Tel: 01244 684910
Email: admin@coopers.co.uk
Web: http://coopers.co.uk

Park House
Sandpiper Court
Chester Business Park
Chester
CH4 9QU

Client

Story
HOMES

Project

EDGEHILL PARK, CUMBRIA,
PHASE 3B

Title

Surface Water Catchment Areas

DRAWING NUMBER

7503-3B / 12

SCALE at A1 1:500

DATE	30.08.22	REVISION
DRAWN	PW	-
CHECKED	AJ	-

0 5 10 15 20 25 30 35 40 45 50
SCALE BAR (m)

© Copyright The original of this drawing contained coloured symbols and/or features.
Any black and white reproduction should not be relied upon.