


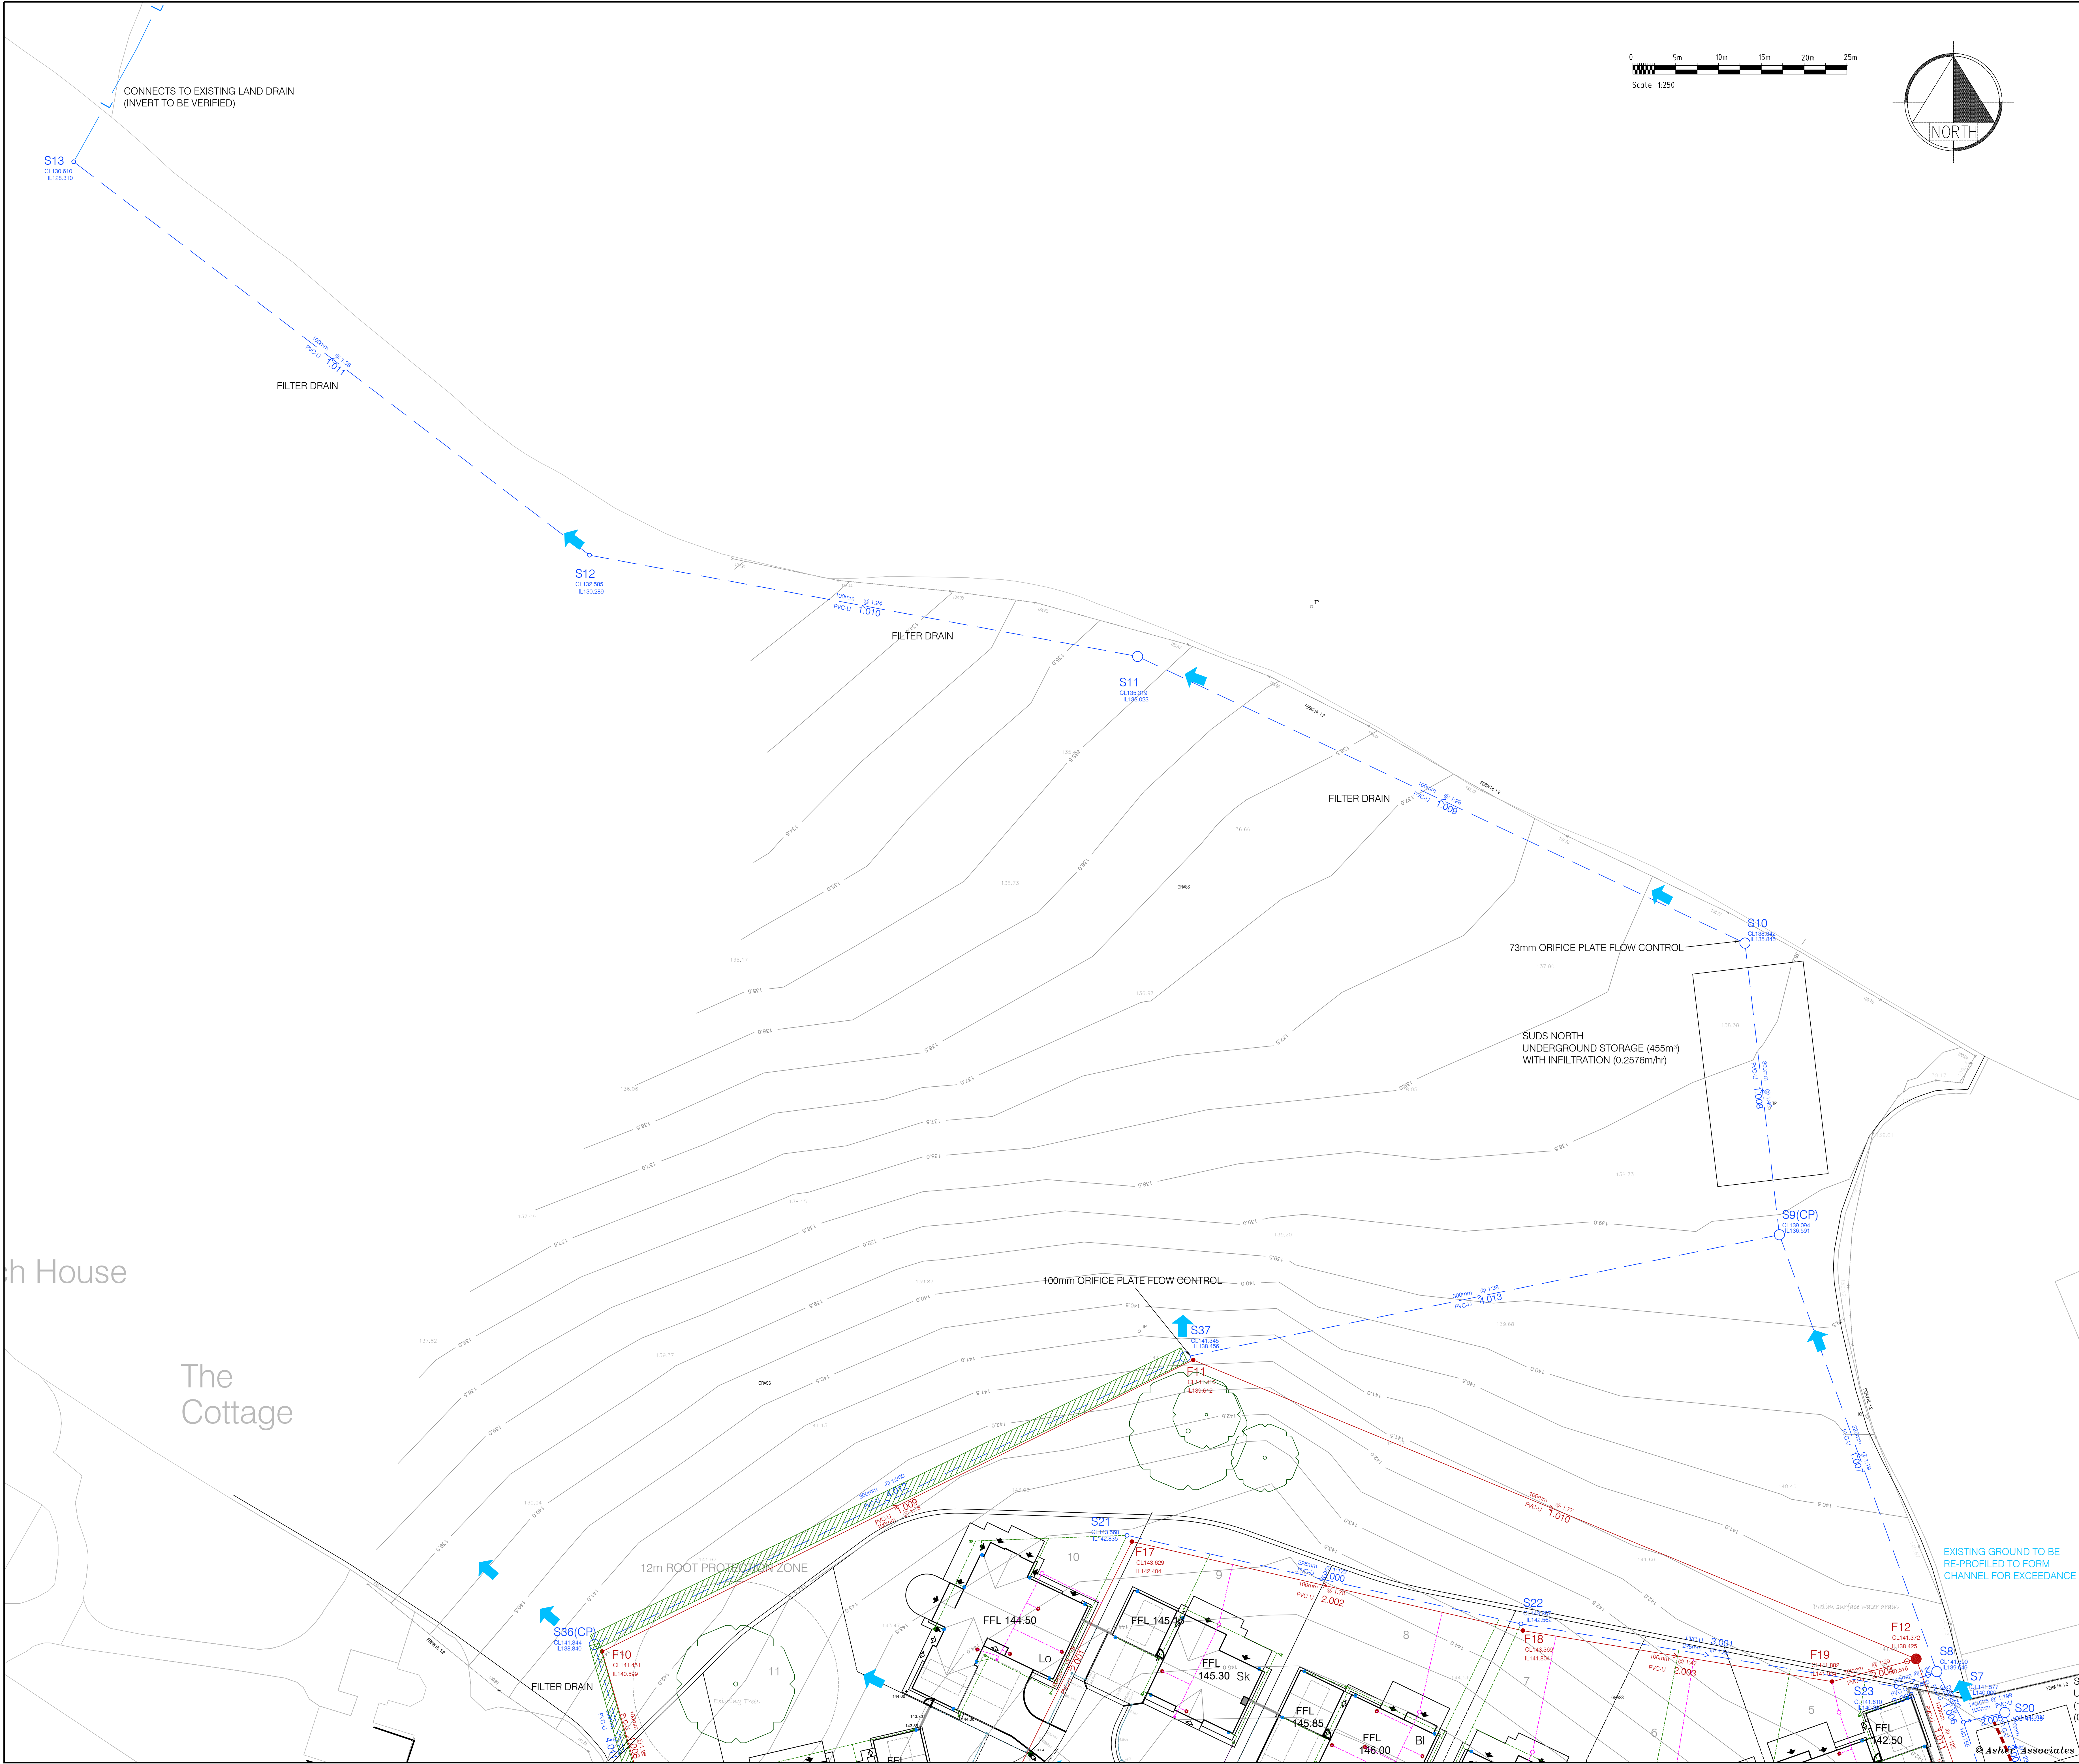

NOTES.

1. DO NOT SCALE FROM THIS DRAWING.

2. ALL DIMENSIONS ARE IN METRES UNLESS OTHERWISE STATED.

KEY: PROPOSED DRAINAGE

ADOPTABLE HIGHWAY DRAIN

PRIVATE SURFACE WATER DRAIN

PRIVATE FOUL SEWER

MANHOLE

MANHOLE WITH BACKDROP

CATCHPIT

HEADWALL

GULLY

CHANNEL DRAIN

SURFACE WATER INSPECTION CHAMBER

FOUL INSPECTION CHAMBER

RODDING EYE

RIISING MAIN

DRAINAGE EXCEEDANCE ROUTE

INFILTRATION TRENCH

KEY:

4A STREETLIGHT

P4 PRIVATE STREETLIGHT

Rev.

Amendment

By

Checked

Approved

Date

PLANNING APPLICATION

Status

Appd.

Date

Client

KCS AGRICULTURAL LTD

Project

NORTH PARK RHEDA, PHASE 2

Title

DRAINAGE LAYOUT 2/3

Drawn	ROM	Date	23.05.24	Checked	WAM	Date	23.05.24	Approved	WAM	Date	23.05.24
-------	-----	------	----------	---------	-----	------	----------	----------	-----	------	----------

Scales

1:250 @ A0

asher ASSOCIATES

CIVIL ENGINEERS
STRUCTURAL ENGINEERS
PROJECT MANAGERS

32 Garage Street, Durness, DS1 1EH
01287 250644 www.asherassociates.co.uk

Job No.

AA7281

Client Drawing No.

Drawing No.

AA7281/EW/05

Rev.

C