


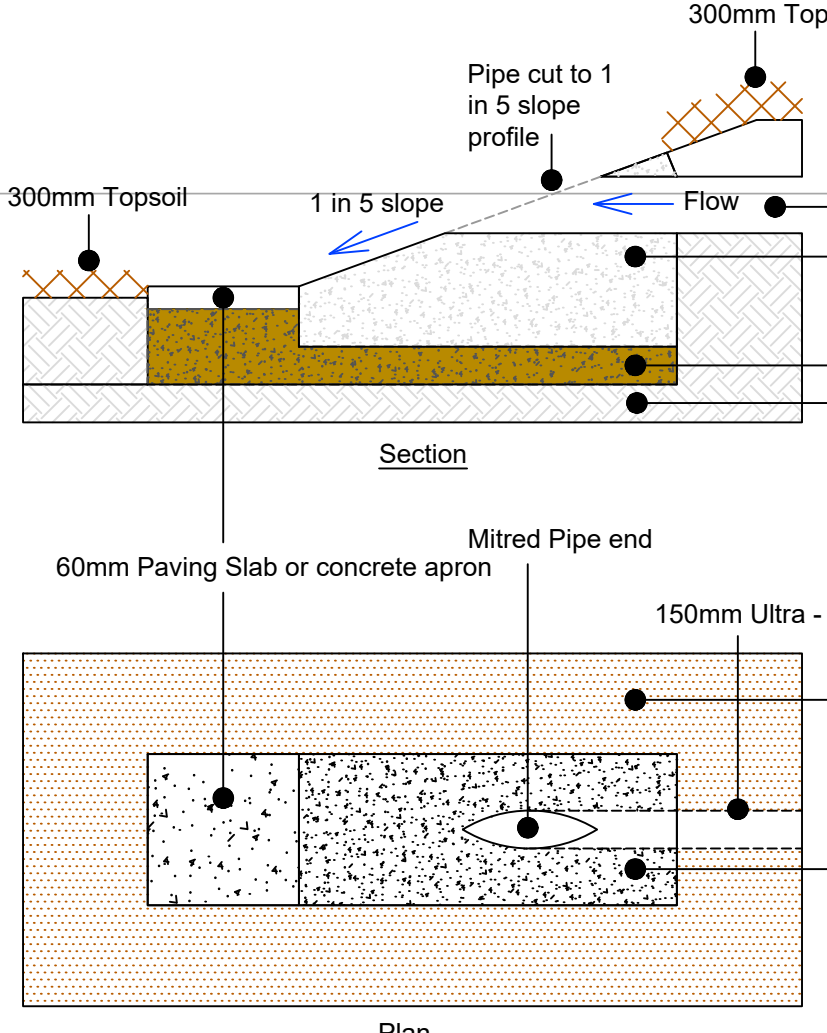


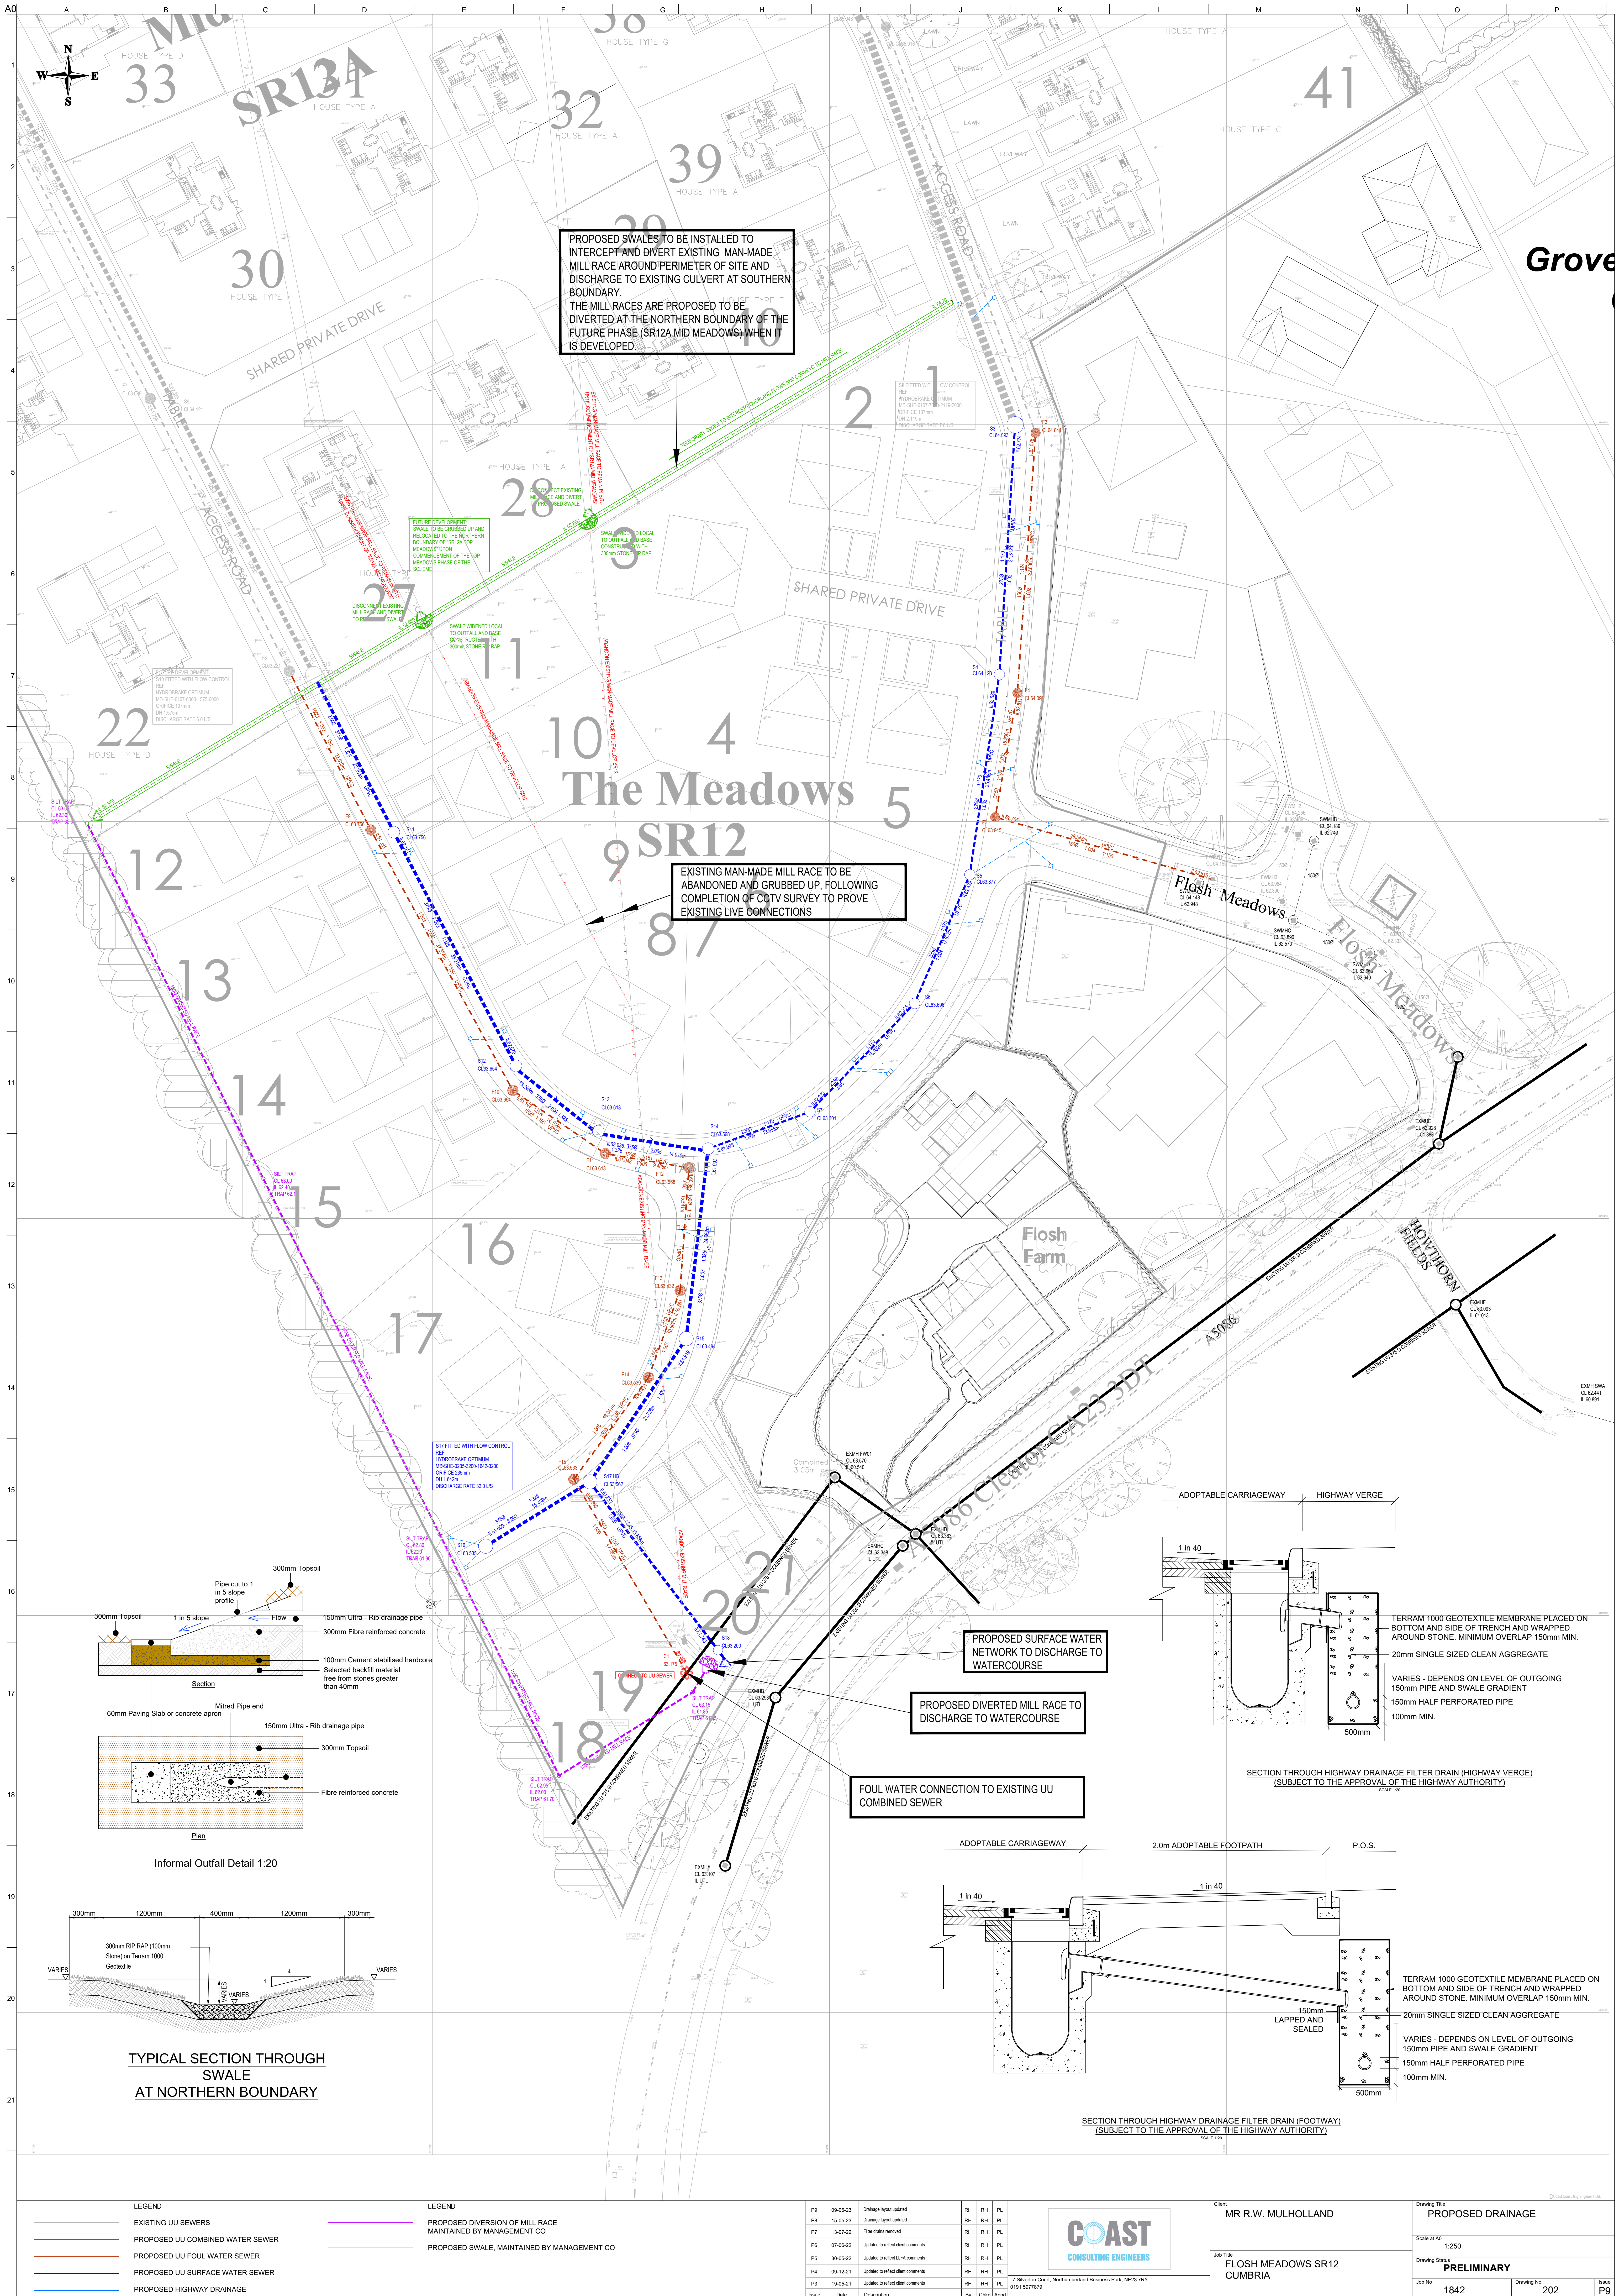

 
TYPICAL SECTION THROUGH SWALE AT NORTHERN BOUNDARY

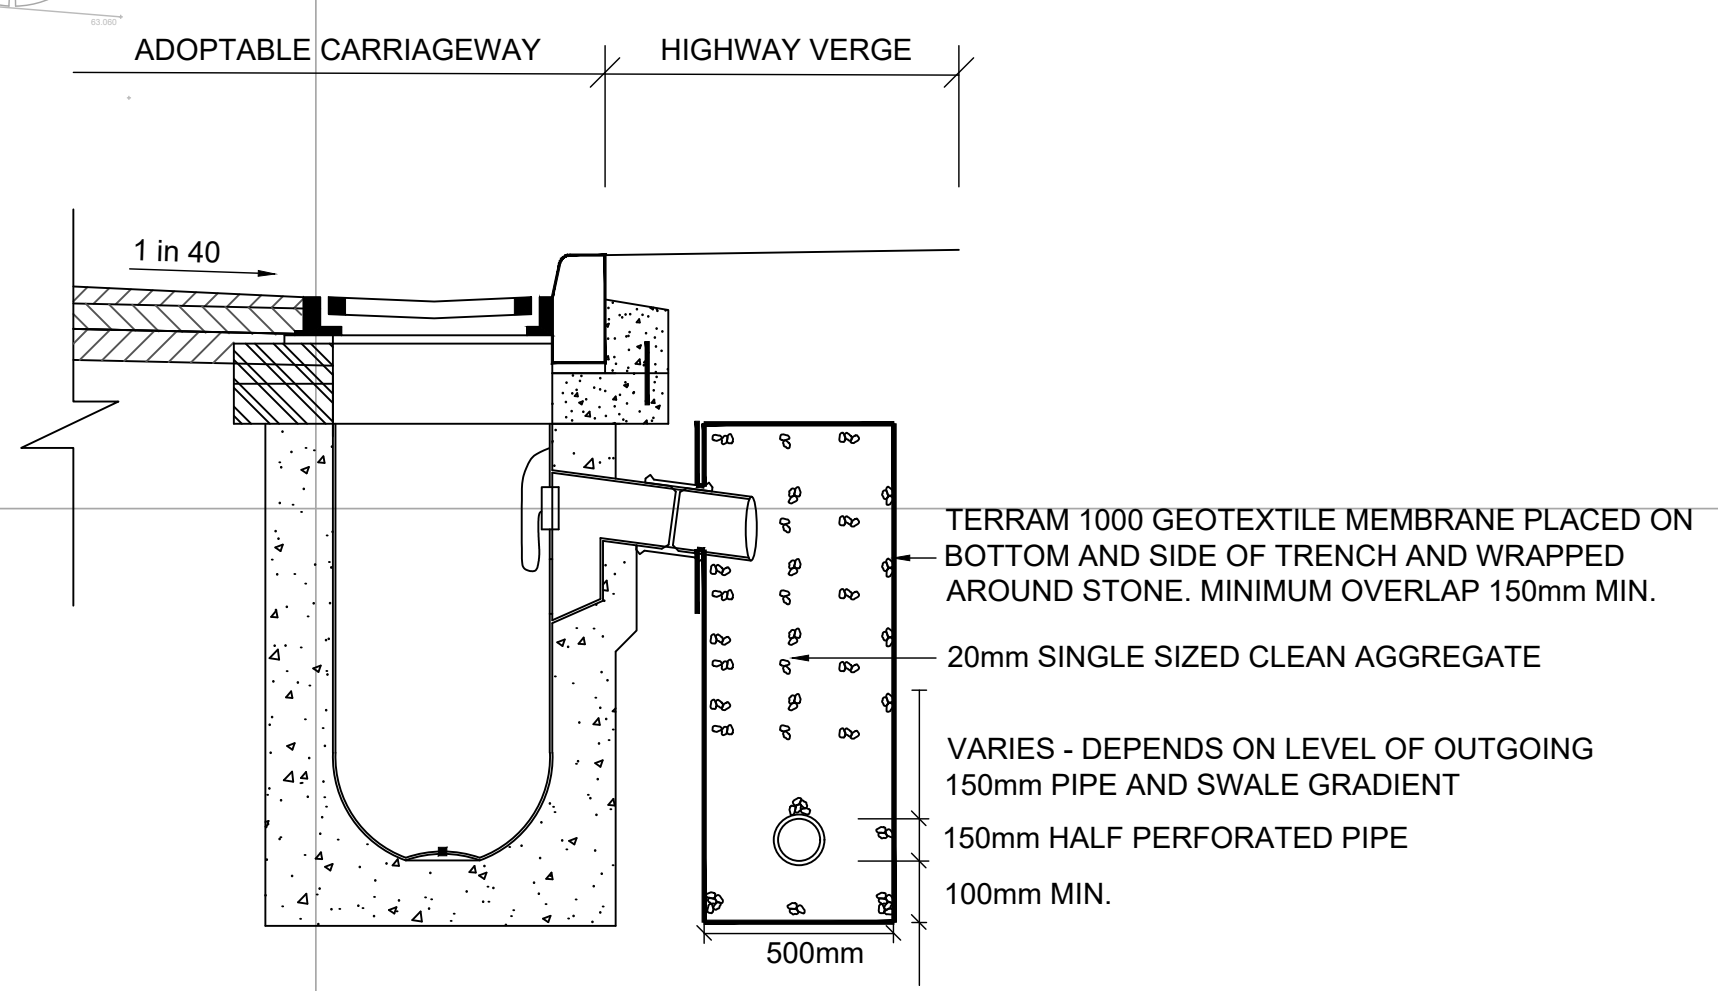

SECTION THROUGH HIGHWAY DRAINAGE FILTER DRAIN (HIGHWAY VERGE) (SUBJECT TO THE APPROVAL OF THE HIGHWAY AUTHORITY)

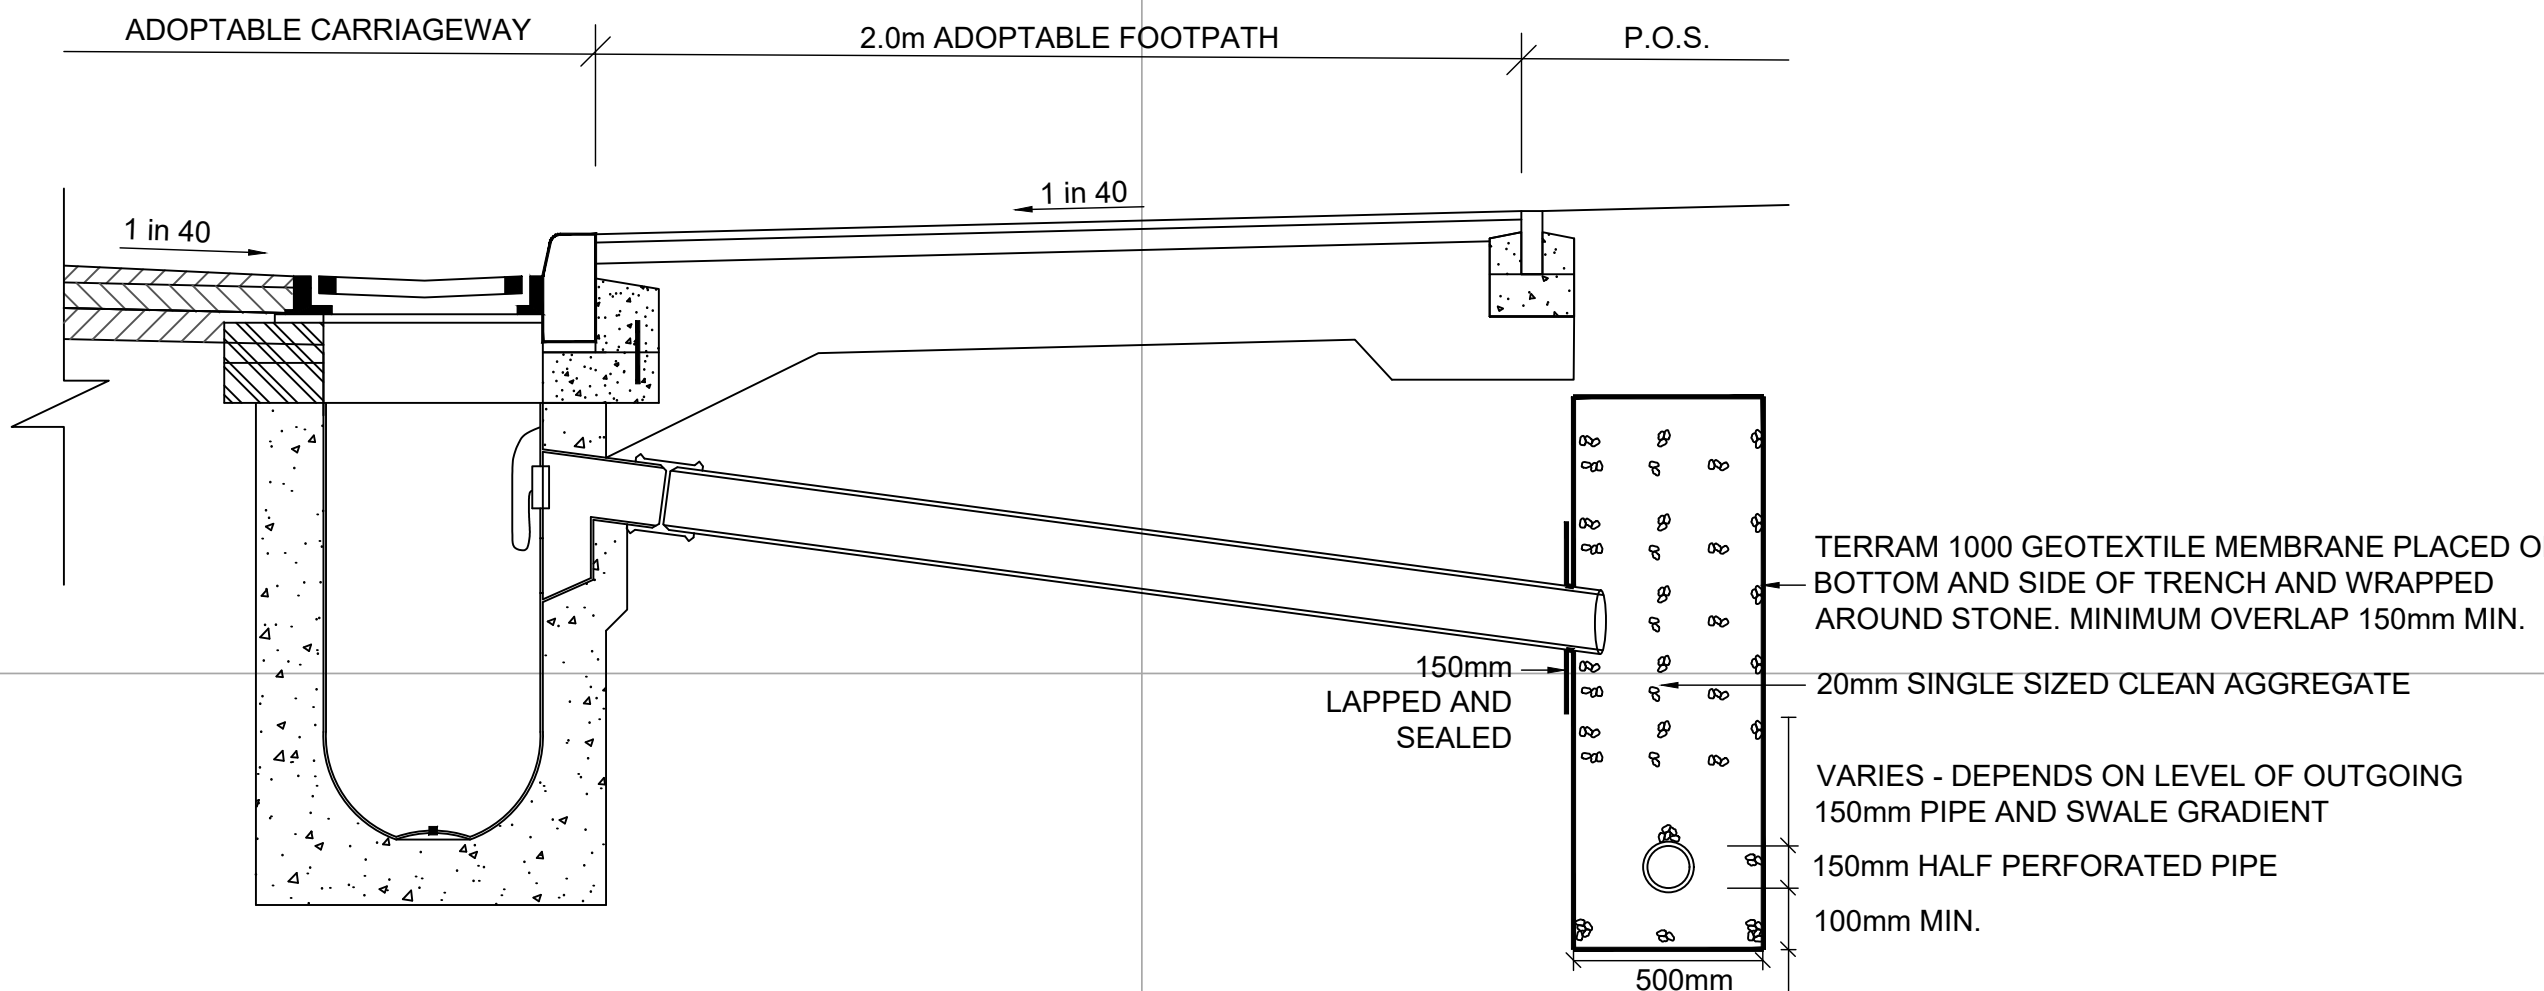

SECTION THROUGH HIGHWAY DRAINAGE FILTER DRAIN (FOOTWAY) (SUBJECT TO THE APPROVAL OF THE HIGHWAY AUTHORITY)

LEGEND		LEGEND		 7 Shelburne Court, Northumberland Business Park, NE23 7RY 0191 5977879		Client		MR R.W. MULHOLLAND	Drawing Title		PROPOSED DRAINAGE				
	EXISTING UU SEWERS		PROPOSED DIVERSION OF MILL RACE MAINTAINED BY MANAGEMENT CO			P9	09-06-23	Drainage layout updated	RH	RH	PL	Scale at A0 1:250			
	PROPOSED UU COMBINED WATER SEWER		PROPOSED SWALE, MAINTAINED BY MANAGEMENT CO			P8	15-05-23	Drainage layout updated	RH	RH	PL				
	PROPOSED UU FOUL WATER SEWER					P7	13-07-22	Filter drains removed	RH	RH	PL				
	PROPOSED UU SURFACE WATER SEWER					P6	07-06-22	Updated to reflect client comments	RH	RH	PL				
	PROPOSED HIGHWAY DRAINAGE					P5	30-05-22	Updated to reflect LFA comments	RH	RH	PL				
				P4	09-12-21	Updated to reflect client comments	RH	RH	PL	Job Title		FLOSH MEADOWS SR12 CUMBRIA	Drawing Status		PRELIMINARY
				P3	19-05-21	Updated to reflect client comments	RH	RH	PL	Job No		1842	Drawing No		202
				Issue	Date	Description	By	CHK	Appd						