


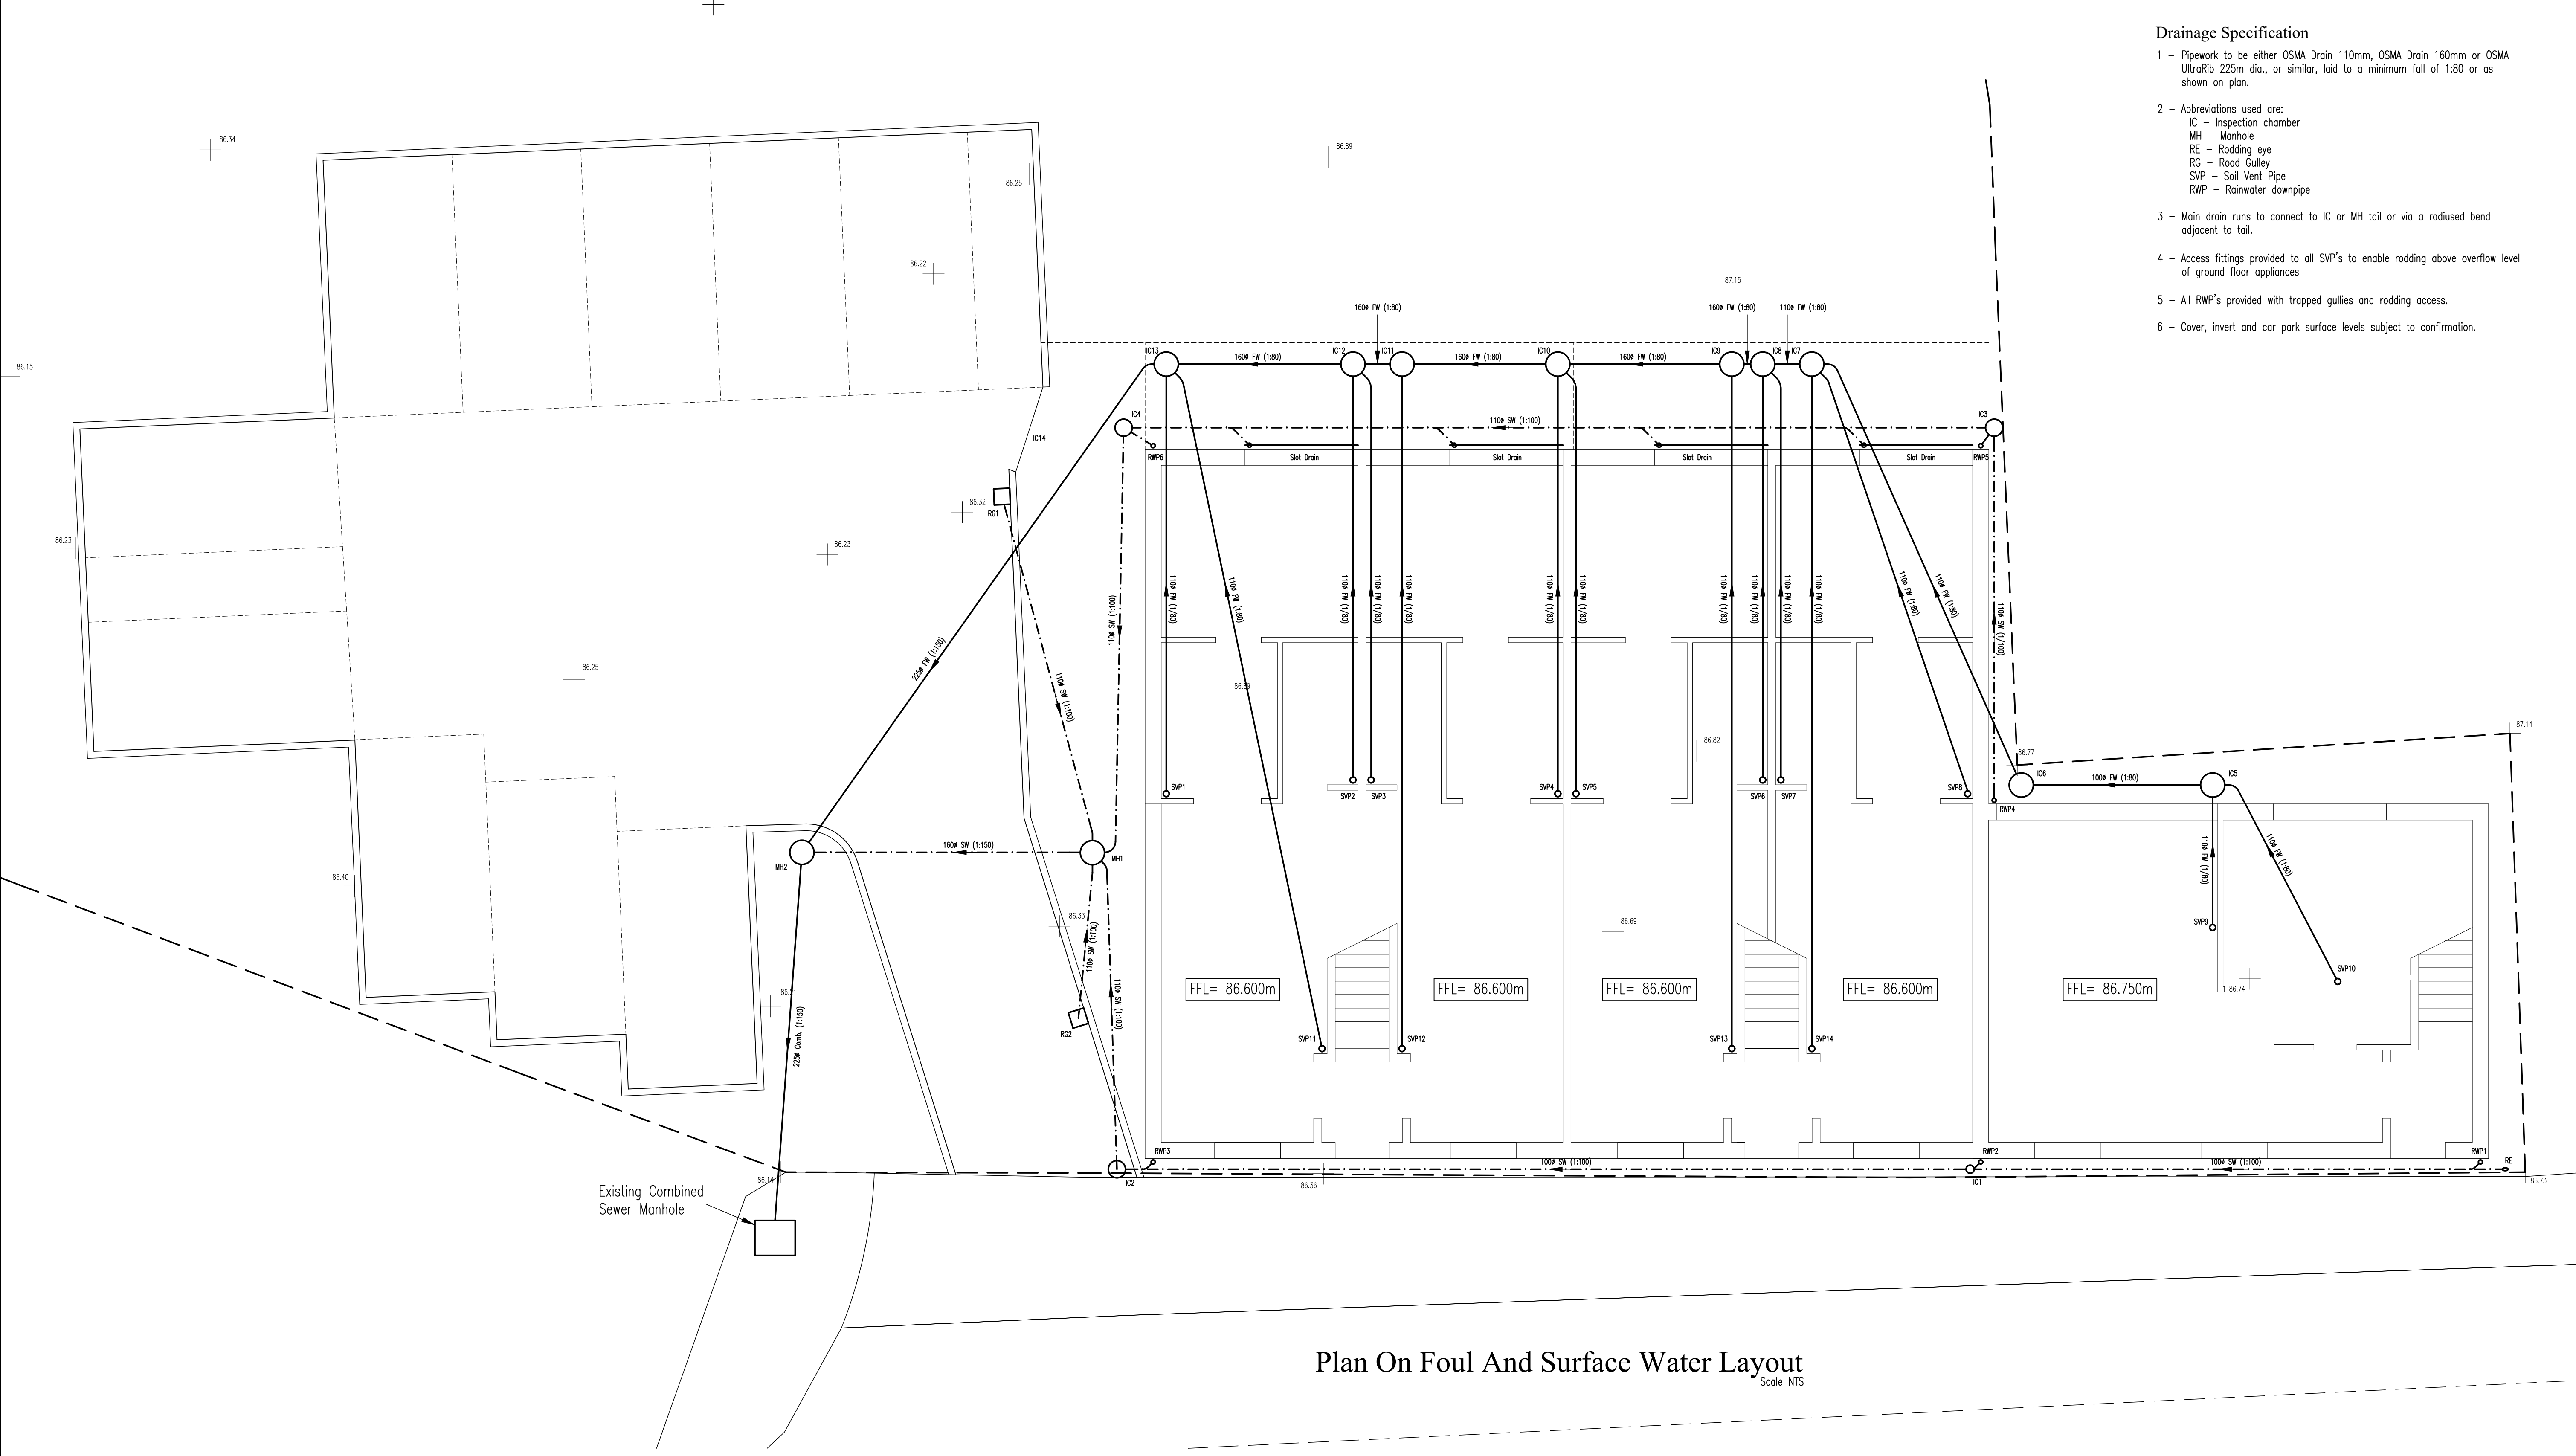

Plan On Foul And Surface Water Layout
Scale NTS

- Drainage Specification**
- 1 - Pipework to be either OSMA Drain 110mm, OSMA Drain 160mm or OSMA UltraRib 225mm dia., or similar, laid to a minimum fall of 1:80 or as shown on plan.
 - 2 - Abbreviations used are:
IC - Inspection chamber
MH - Manhole
RE - Rodding eye
RG - Road Gully
SVP - Soil Vent Pipe
RWP - Rainwater downpipe
 - 3 - Main drain runs to connect to IC or MH tail or via a radiused bend adjacent to tail.
 - 4 - Access fittings provided to all SVP's to enable rodding above overflow level of ground floor appliances
 - 5 - All RWP's provided with trapped gullies and rodding access.
 - 6 - Cover, invert and car park surface levels subject to confirmation.

NOTES

Copyright of this drawing remains with MBC Designs.

Do not scale from this drawing.

Dimensions marked "*" shall be checked on site by the Contractor prior to the commencement of work on site.

Dimensional discrepancies shall be notified to MBC Designs.

B 4/2/22 Surface water drainage updated to suit United Utility requirements			
A 3/2/22 Drainage to car park area and finished floor levels amended			
Rev	Date	Description	
		MBC Designs Building Design Service	
		26 Gloucester Road, Wyton-On-The-Hill, Huntingdon, Cambs. PE28 2HF	
		Tel. No. - 07986 115913 E-mail - mrvandem@btol.co.uk	
Dentholme, Cragg Road, Cleator Moor, CA25 5PR New Dwellings			
Drainage Layout			
DRAWN MRV		CHECKED	DRG No.
SCALES NTS		DATE Jan. 2022	REV B
ACAD FILE No. 0010121		0010121-10	
		©copyright	