



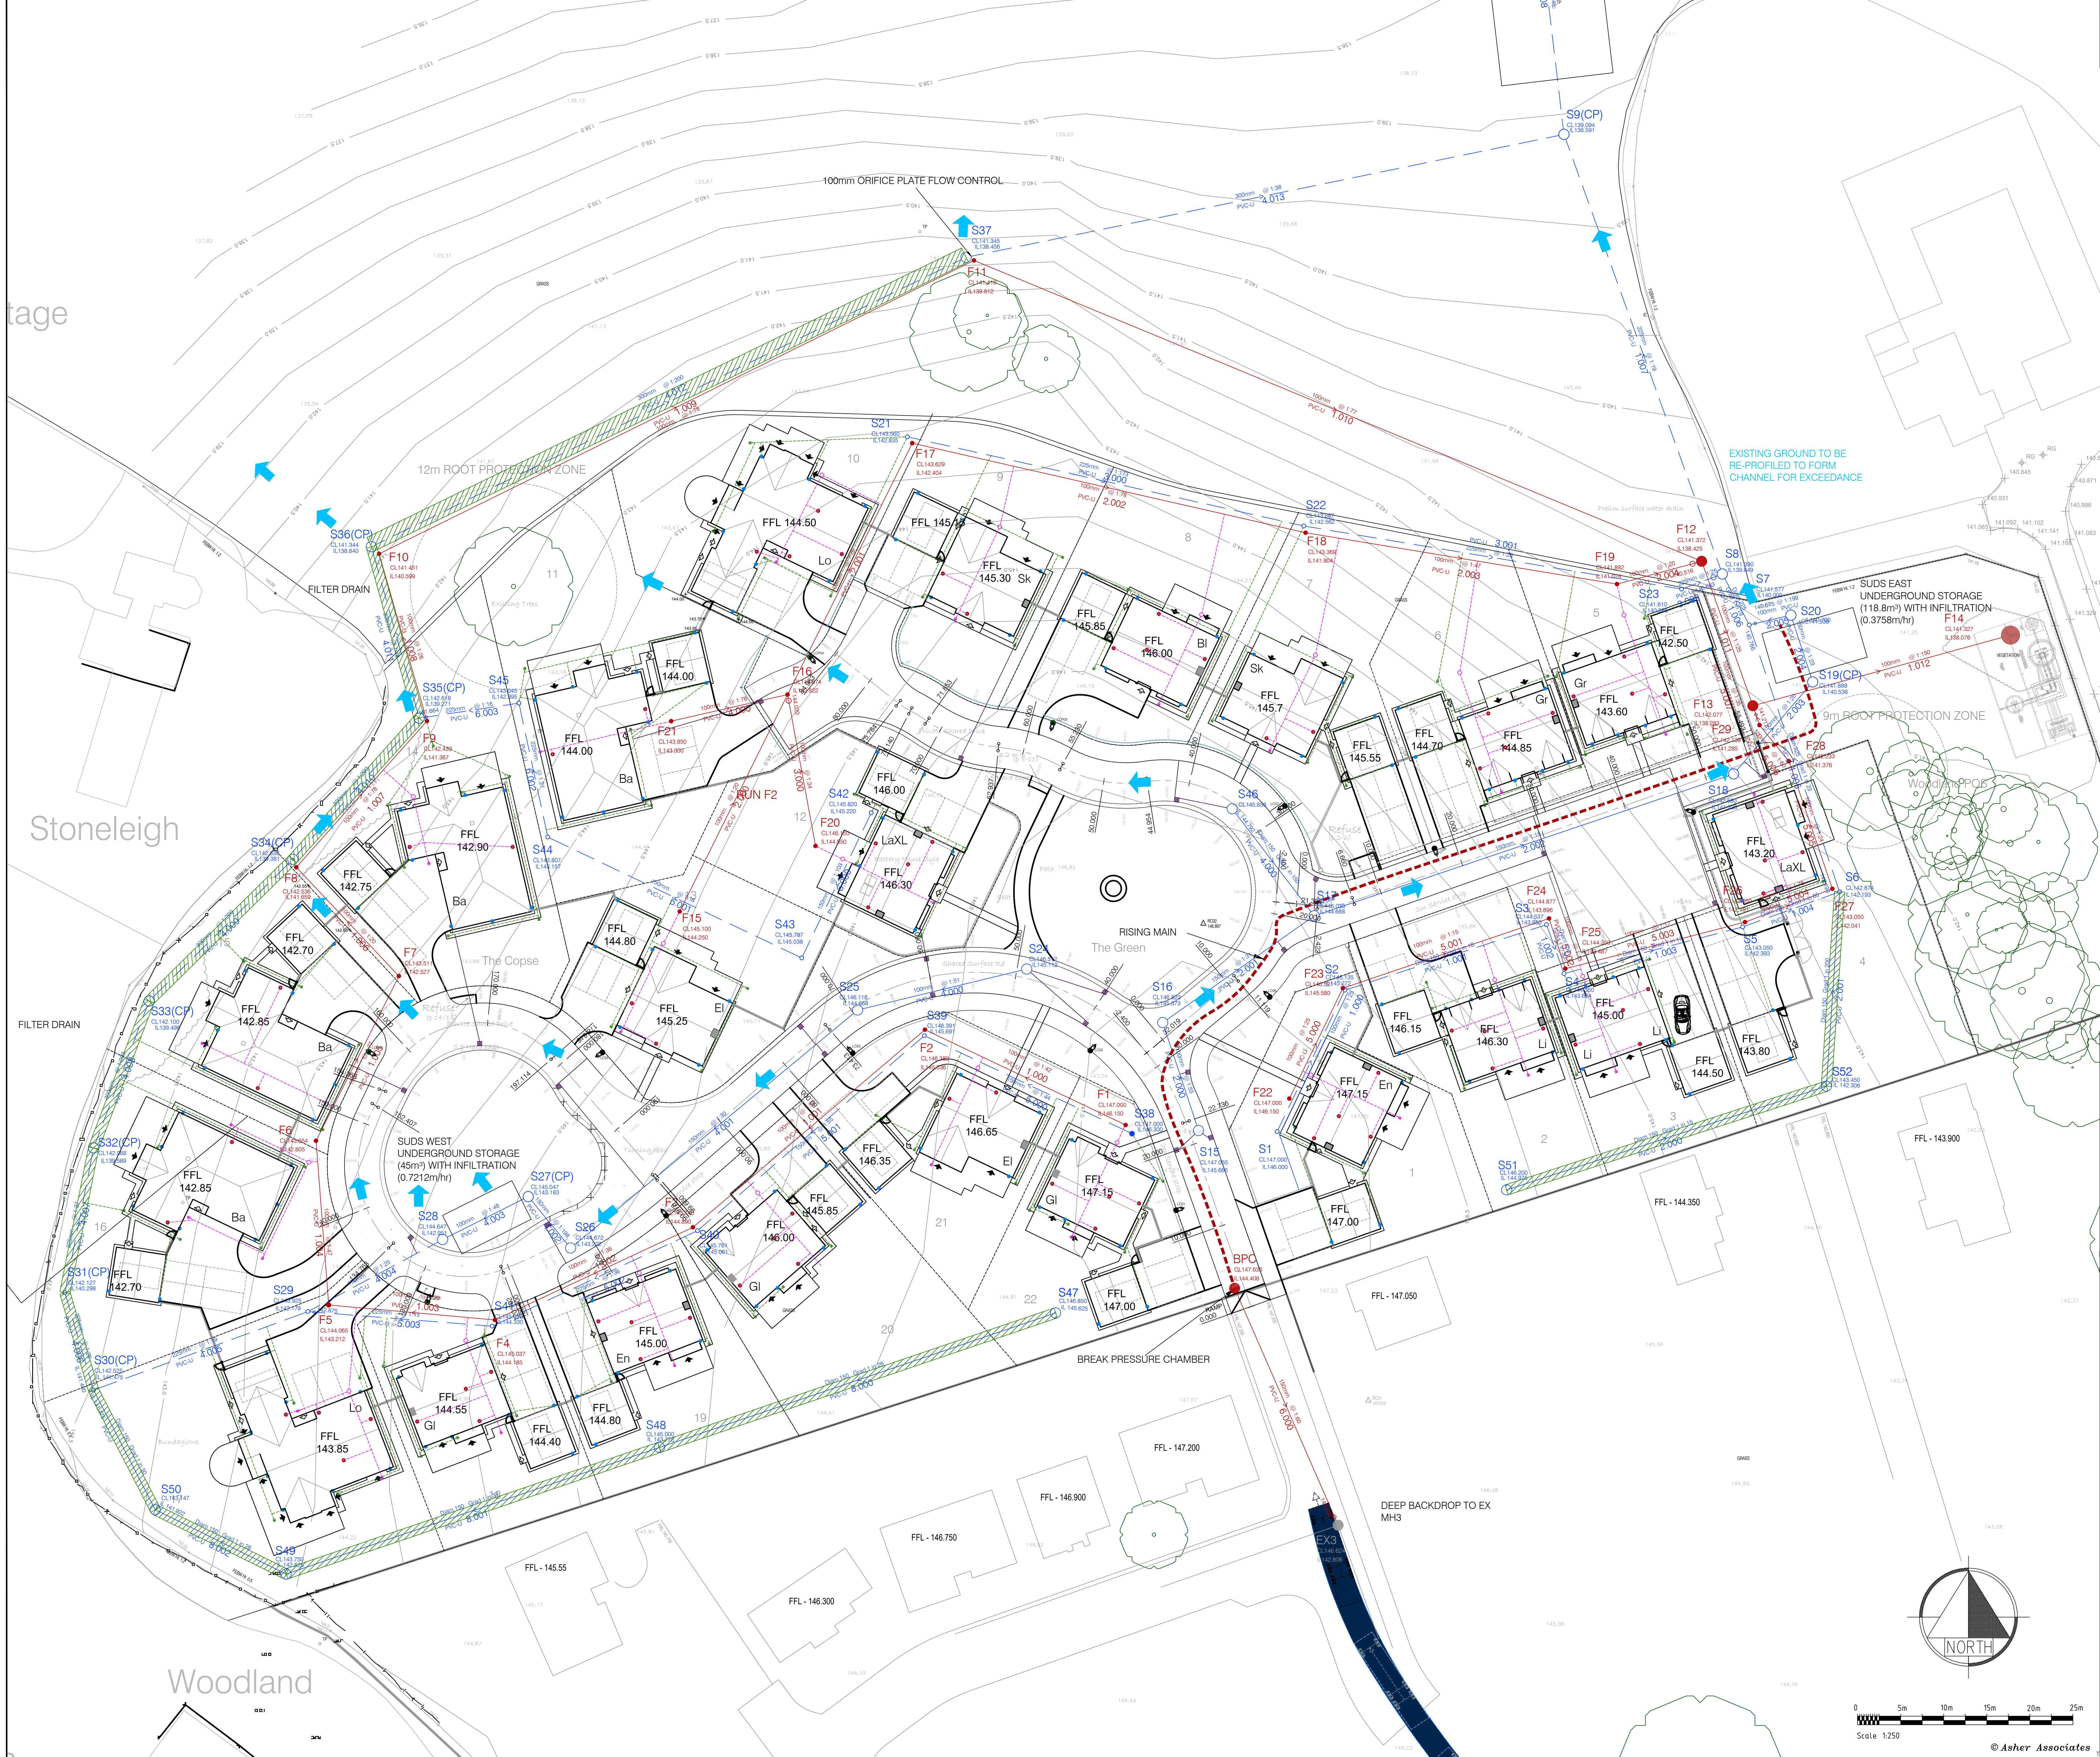

NOTES:
1. DO NOT SCALE FROM THIS DRAWING.
2. ALL DIMENSIONS ARE IN METRES UNLESS OTHERWISE STATED.

- KEY: PROPOSED DRAINAGE**
- ADOPTABLE HIGHWAY DRAIN
 - PRIVATE SURFACE WATER DRAIN
 - PRIVATE FOUL SEWER
 - MANHOLE
 - MANHOLE WITH BACKDROP
 - CATCHPIT
 - HEADWALL
 - GULLY
 - CHANNEL DRAIN
 - SURFACE WATER INSPECTION CHAMBER
 - FOUL INSPECTION CHAMBER
 - RODDING EYE
 - RIISING MAIN
 - DRAINAGE EXCEEDANCE ROUTE
 - INFILTRATION TRENCH

- KEY:**
- STREETLIGHT
 - PRIVATE STREETLIGHT

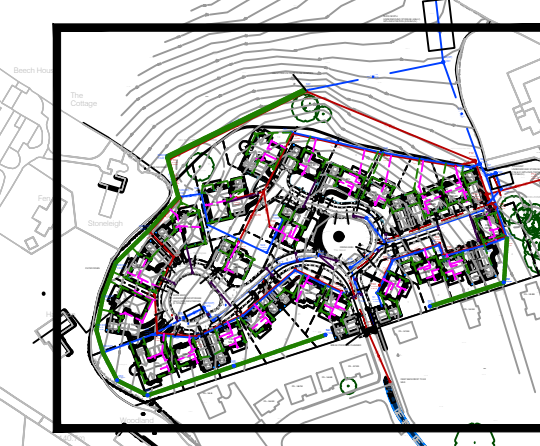

C	UPDATED AS PER A47281/EW/02E	ROM	WAM	WAM	WAM
B	INFILTRATION TRENCH ADDED TO KEY, LIGHTING COLUMNS SHOWN.	RJ	WAM	WAM	WAM
A	UPDATED AS PER A47281/EW/03C	ROM	WAM	WAM	WAM
Rev.	Amendment	By	Checked	Approved	Date
PLANNING APPLICATION					
Status				Appd.	Date
Client					
KCS AGRICULTURAL LTD					
Project					
NORTH PARK RHEDA, PHASE 2					
Title					
DRAINAGE LAYOUT 1/3					
Drawn	Date	Checked	Date	Approved	Date
ROM	23.05.24	WAM	23.05.24	WAM	23.05.24
Scales			1:250 @ A0		
Job No.			AA7281		
Client Drawing No.					Rev.
Drawing No.					C