
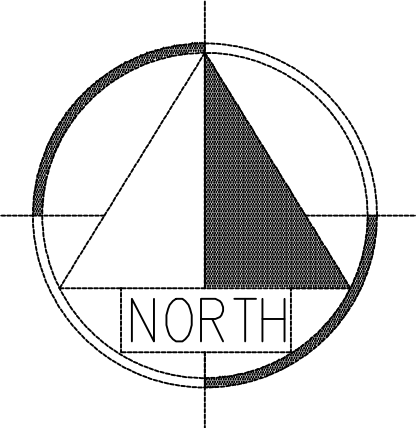
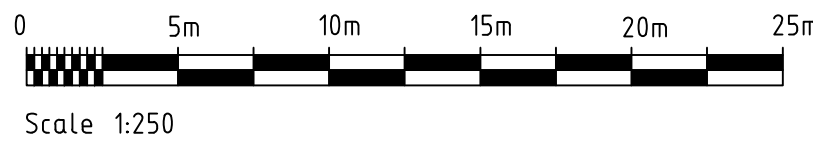


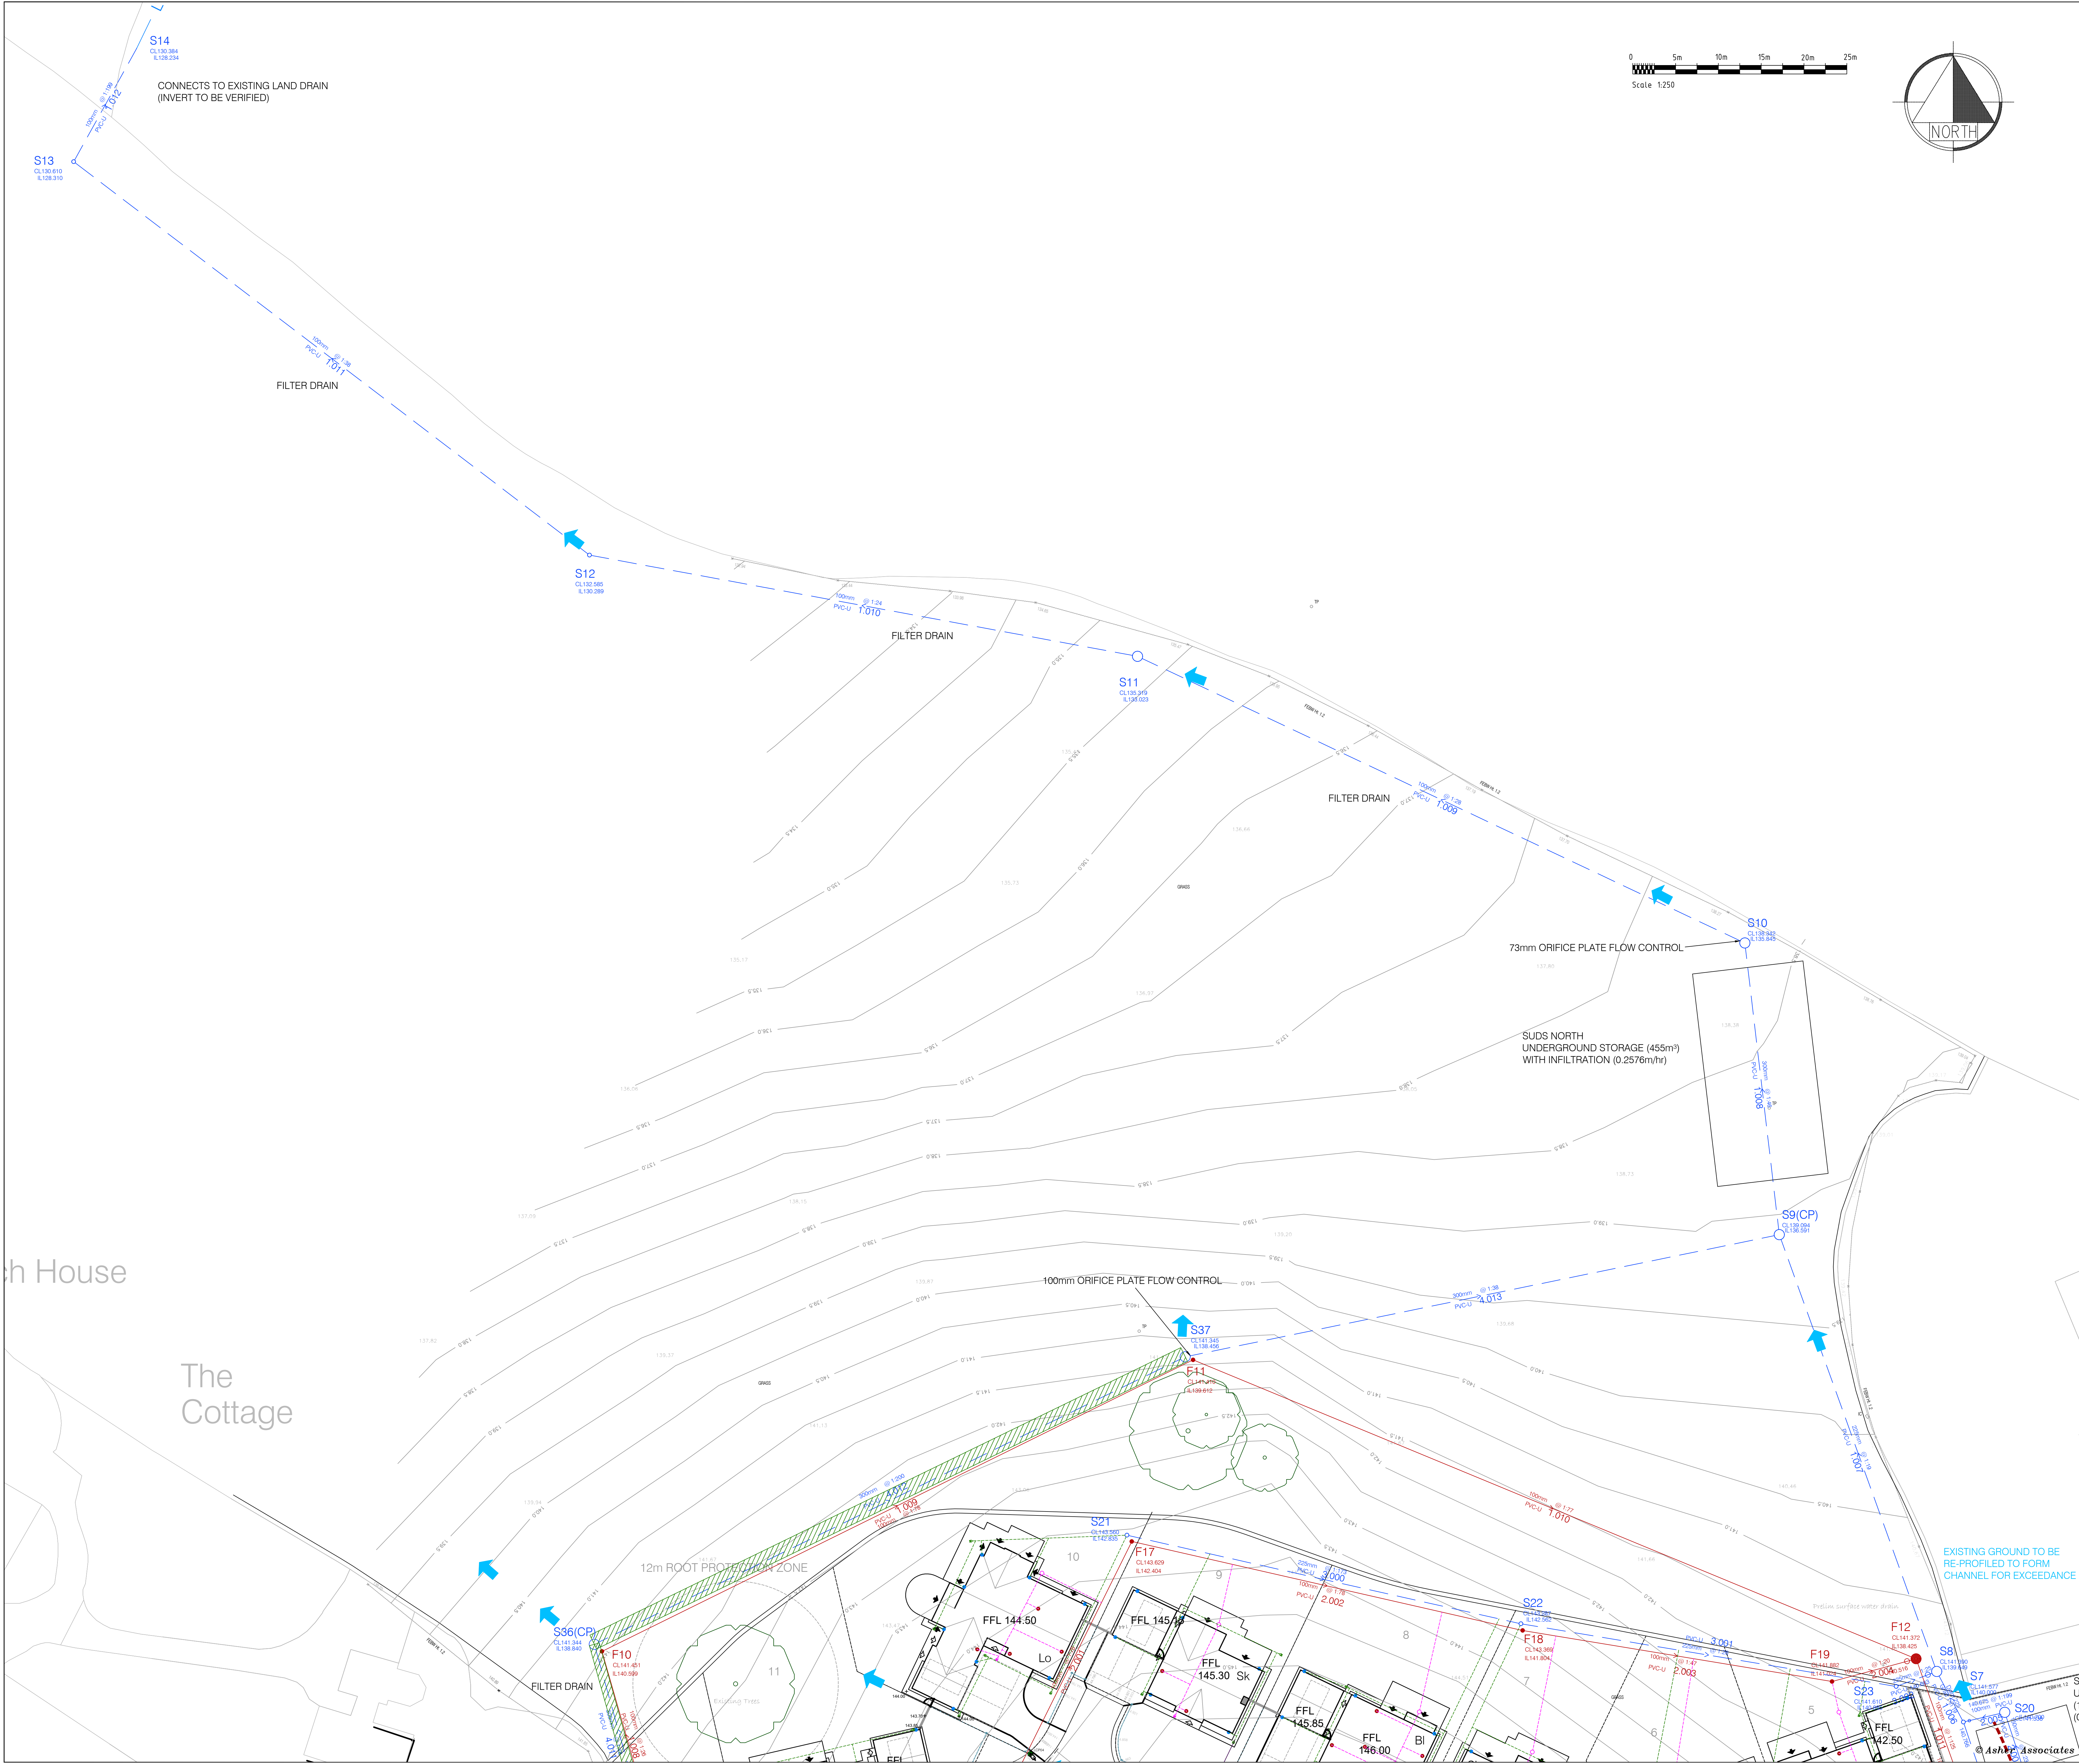


- NOTES.
1. DO NOT SCALE FROM THIS DRAWING.
 2. ALL DIMENSIONS ARE IN METRES UNLESS OTHERWISE STATED.

KEY: PROPOSED DRAINAGE

- ADOPTABLE HIGHWAY DRAIN
- PRIVATE SURFACE WATER DRAIN
- PRIVATE FOUL SEWER
- MANHOLE
- MANHOLE WITH BACKDROP
- CATCHPIT
- HEADWALL
- GULLY
- CHANNEL DRAIN
- SURFACE WATER INSPECTION CHAMBER
- FOUL INSPECTION CHAMBER
- RODDING EYE
- RISING MAIN
- DRAINAGE EXCEEDANCE ROUTE
- INFILTRATION TRENCH

KEY:

- STREETLIGHT
- PRIVATE STREETLIGHT

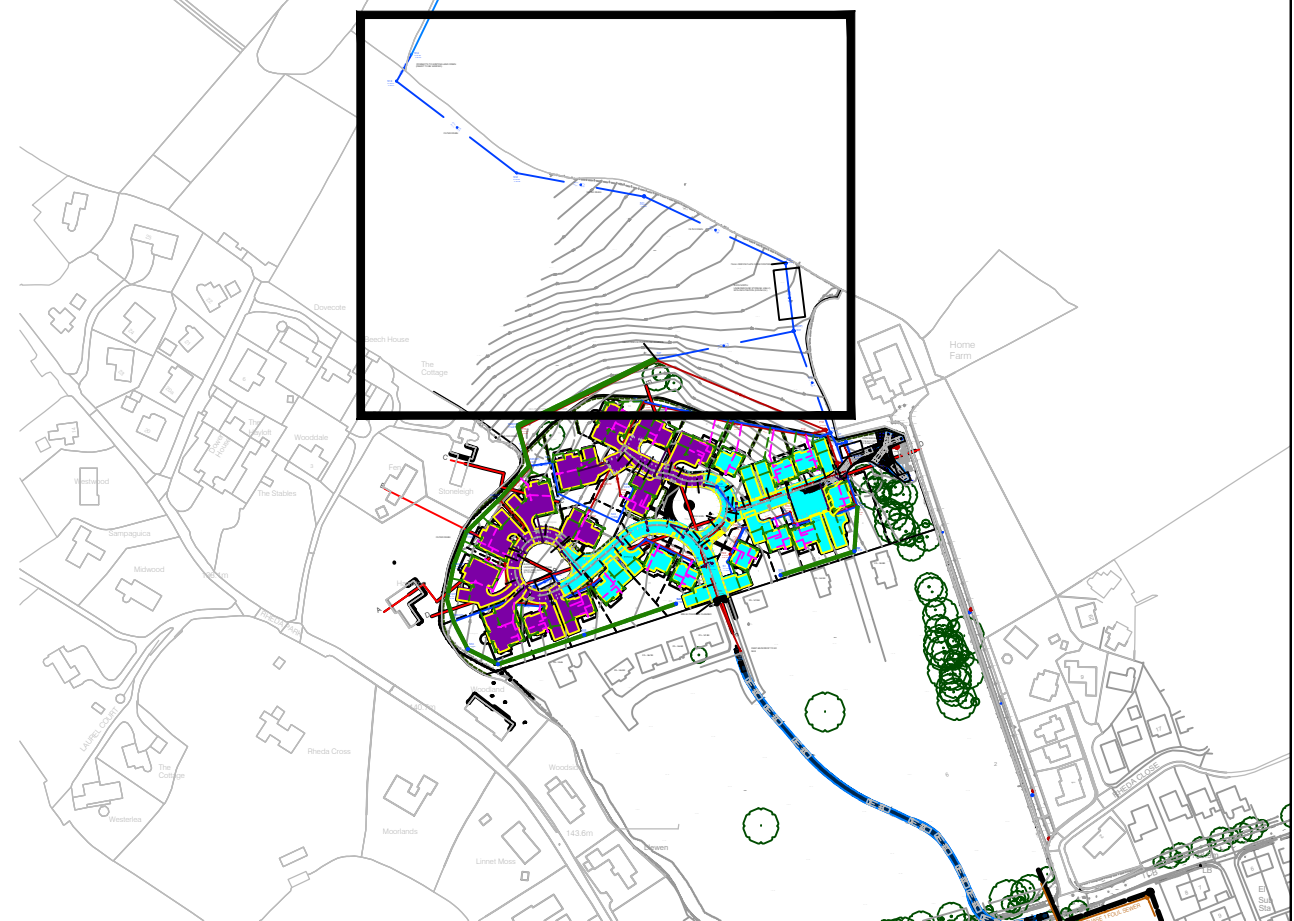

B	INFILTRATION TRENCH ADDED TO KEY. LIGHTING COLUMNS SHOWN.							RJ	WAM	WAM	23.05.24
A	UPDATED AS PER AA7281/EW/03C							ROM	WAM	WAM	23.05.24
Rev.	Amendment							By	Checked	Approved	Date
PLANNING APPLICATION											
Status								Appd.		Date	
Client											
KCS AGRICULTURAL LTD											
Project											
NORTH PARK RHEDA, PHASE 2											
Title											
DRAINAGE LAYOUT 2/3											
Drawn	ROM	Date	23.05.24	Checked	WAM	Date	23.05.24	Approved	WAM	Date	23.05.24
				Scales							
				1:250 @ A0							
				Job No. AA7281							
				Client Drawing No.							Rev.
				Drawing No. AA7281/EW/05							B
35 George Street, Colchester, Essex, Essex S. 01387 250644 www.asherassociates.co.uk											