






FRONT ELEVATION AS EXISTING
Scale 1:100

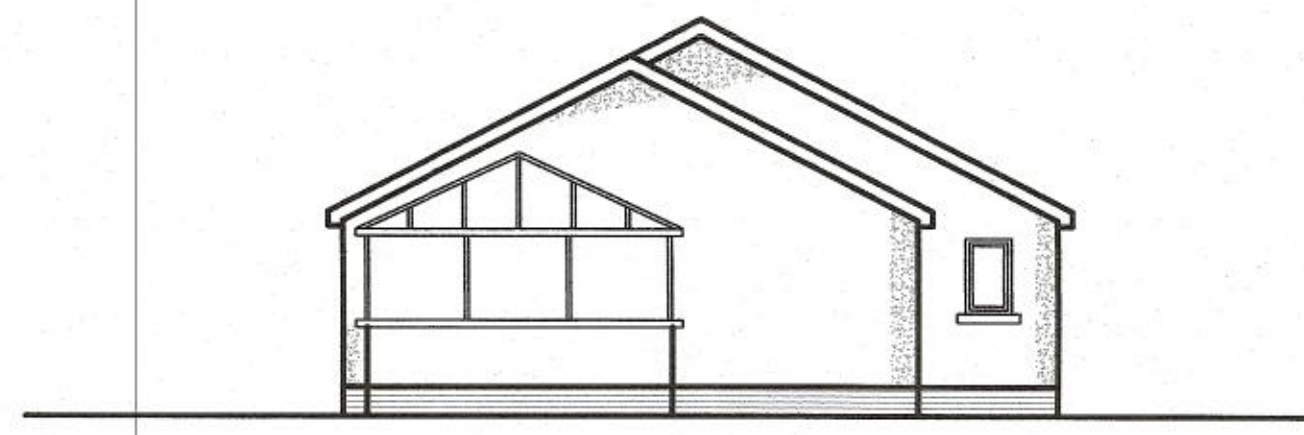

SIDE ELEVATION AS EXISTING

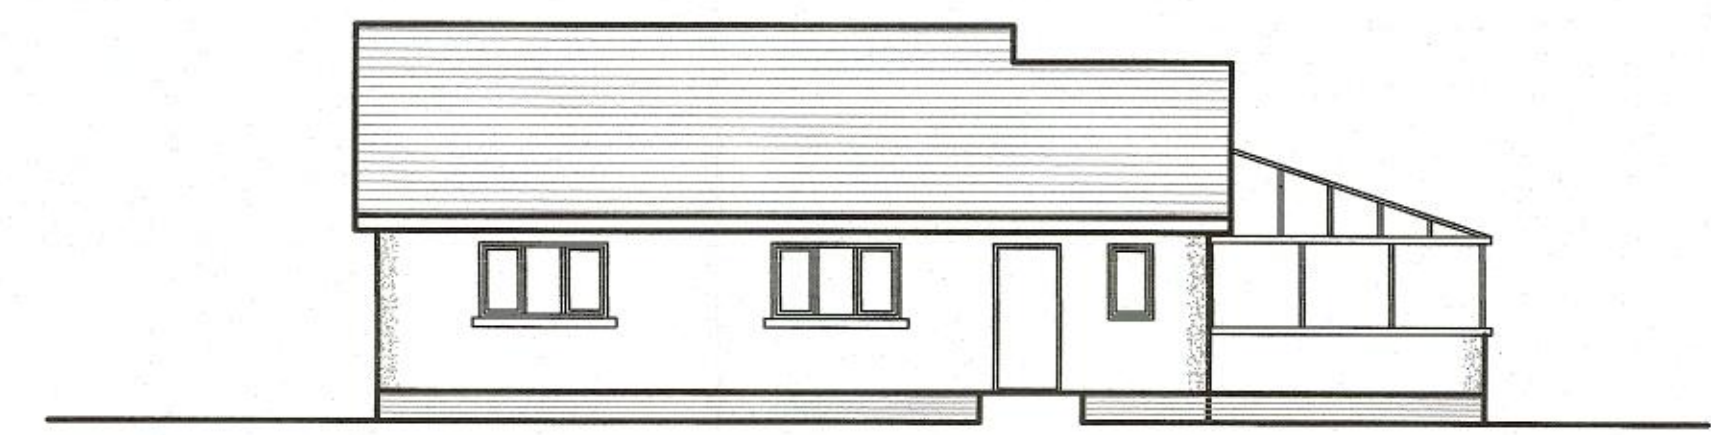

REAR ELEVATION AS EXISTING

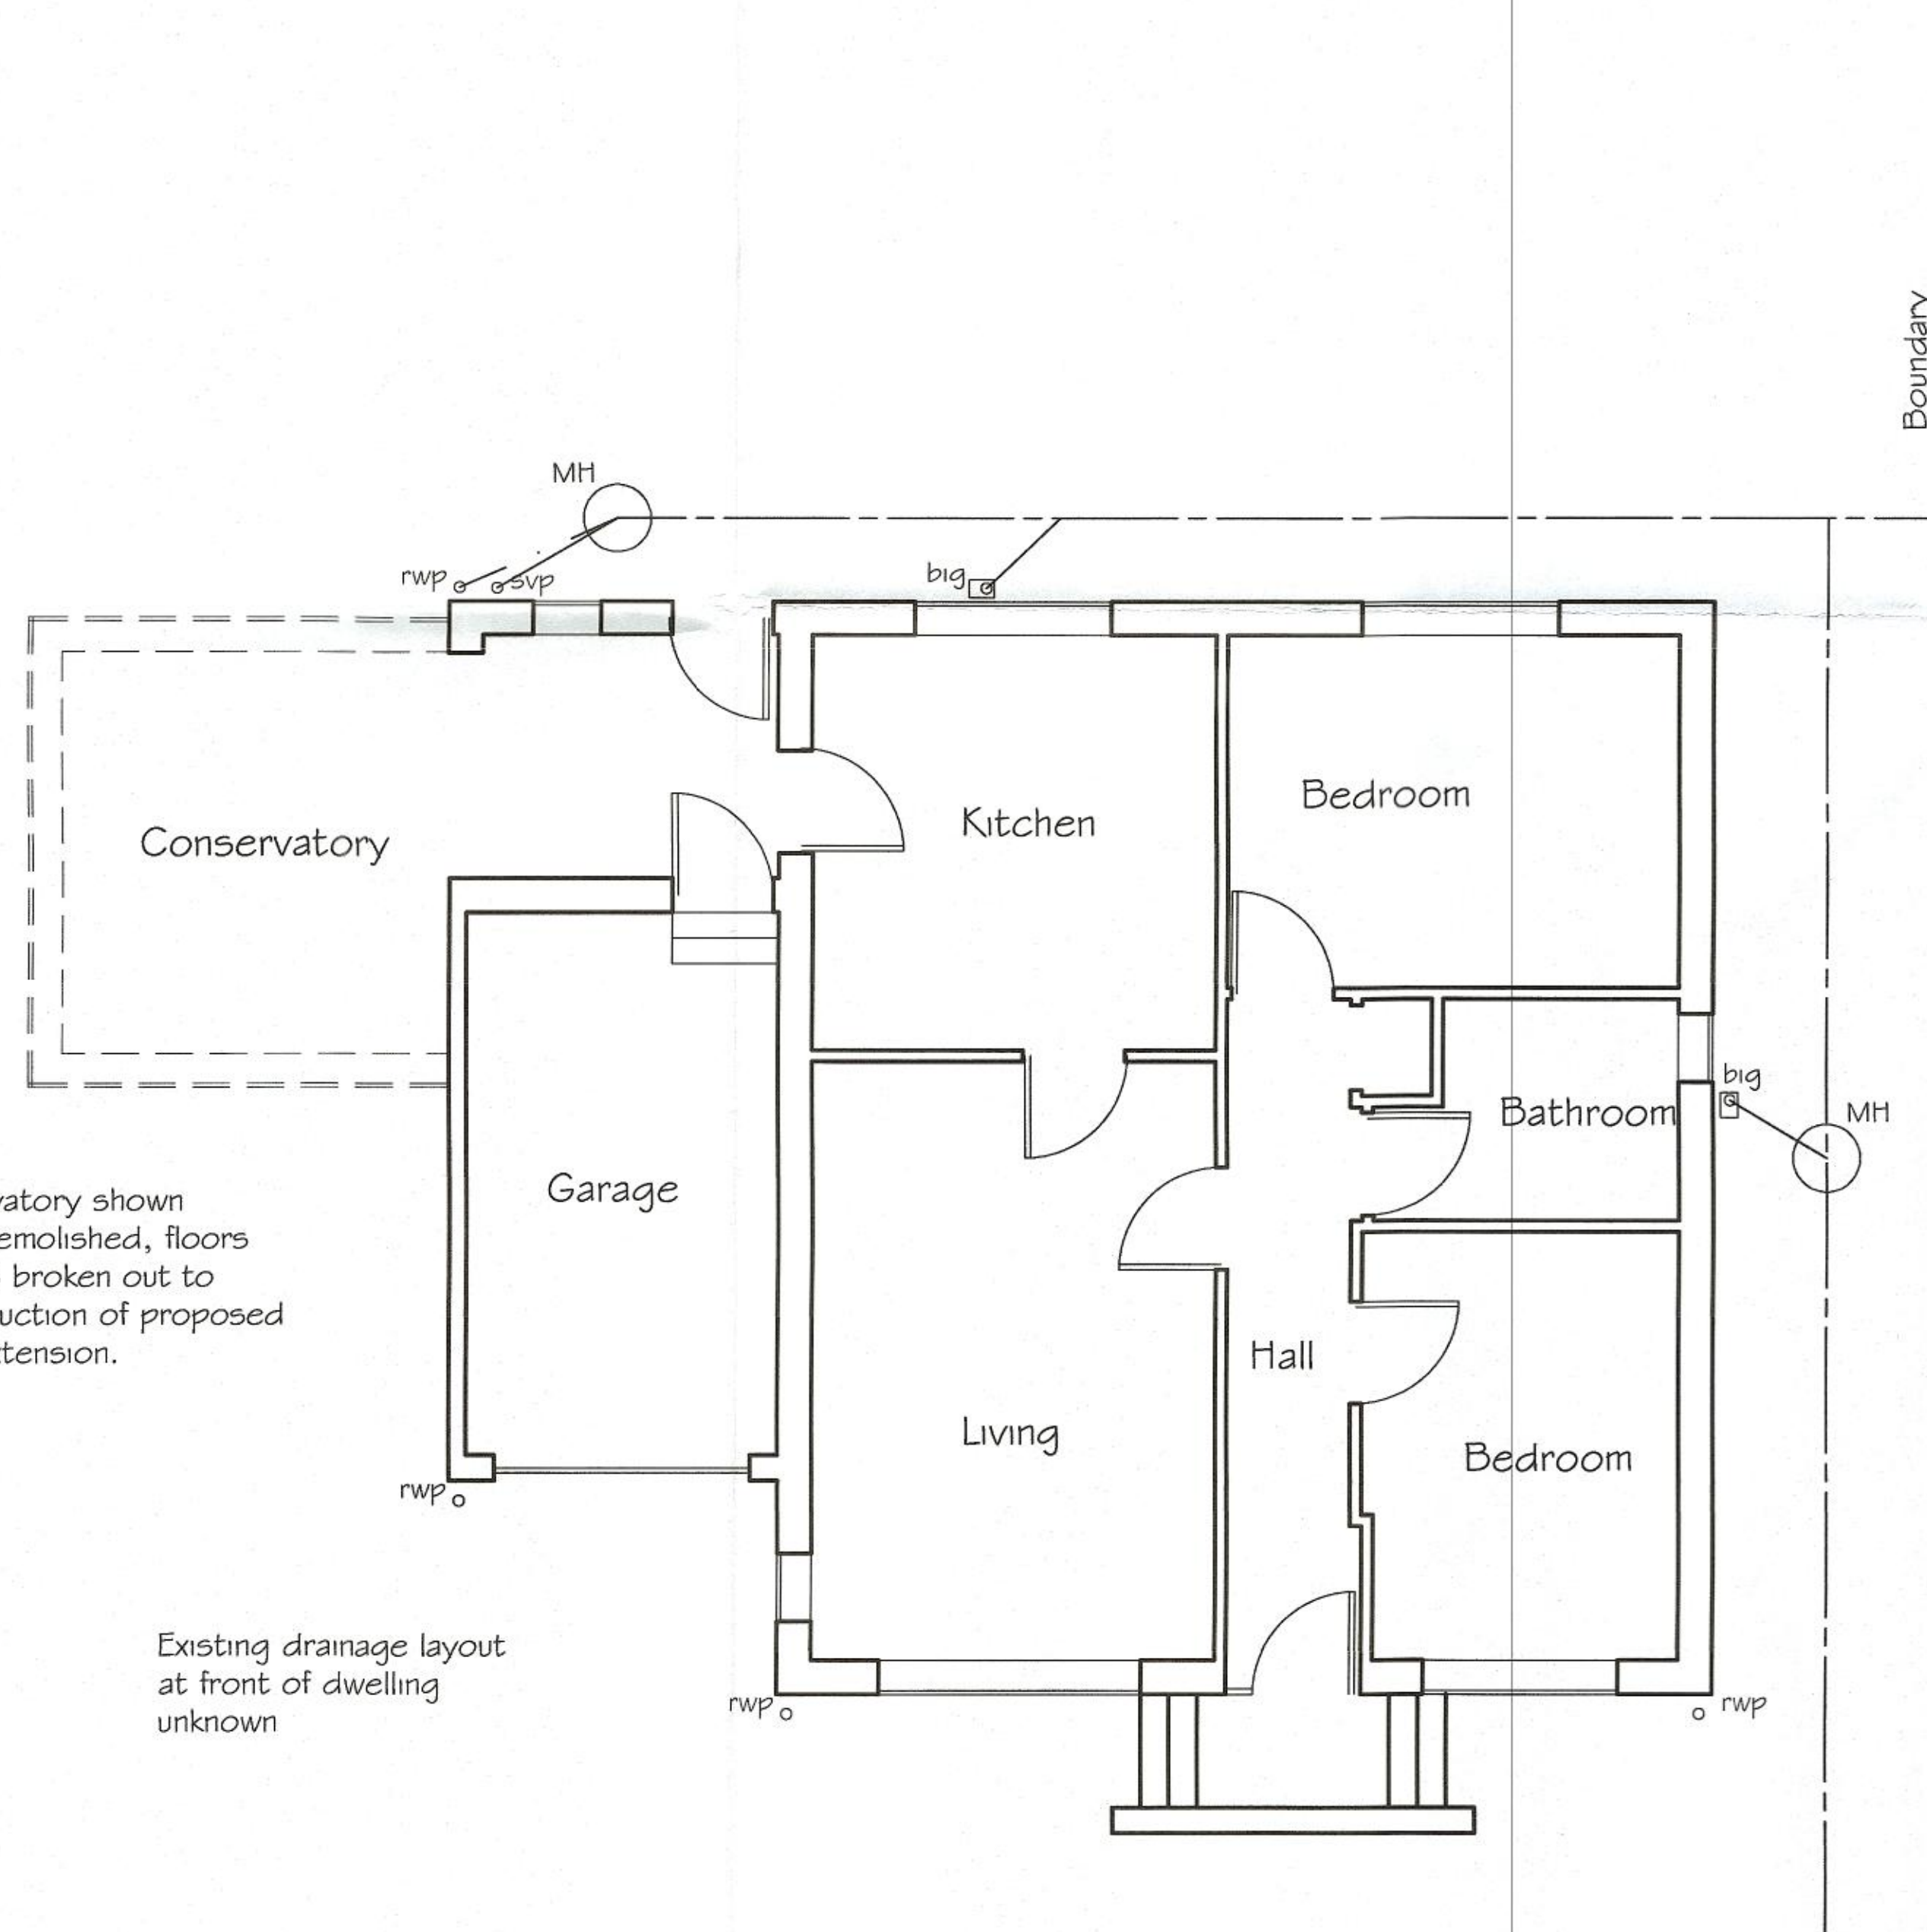

GROUND FLOOR PLAN AS EXISTING
Scale 1:50

Existing drainage layout shown is assumed & shall be verified by the builder during the construction phase. All to be retained & adopted for use on completion of new extensions.