


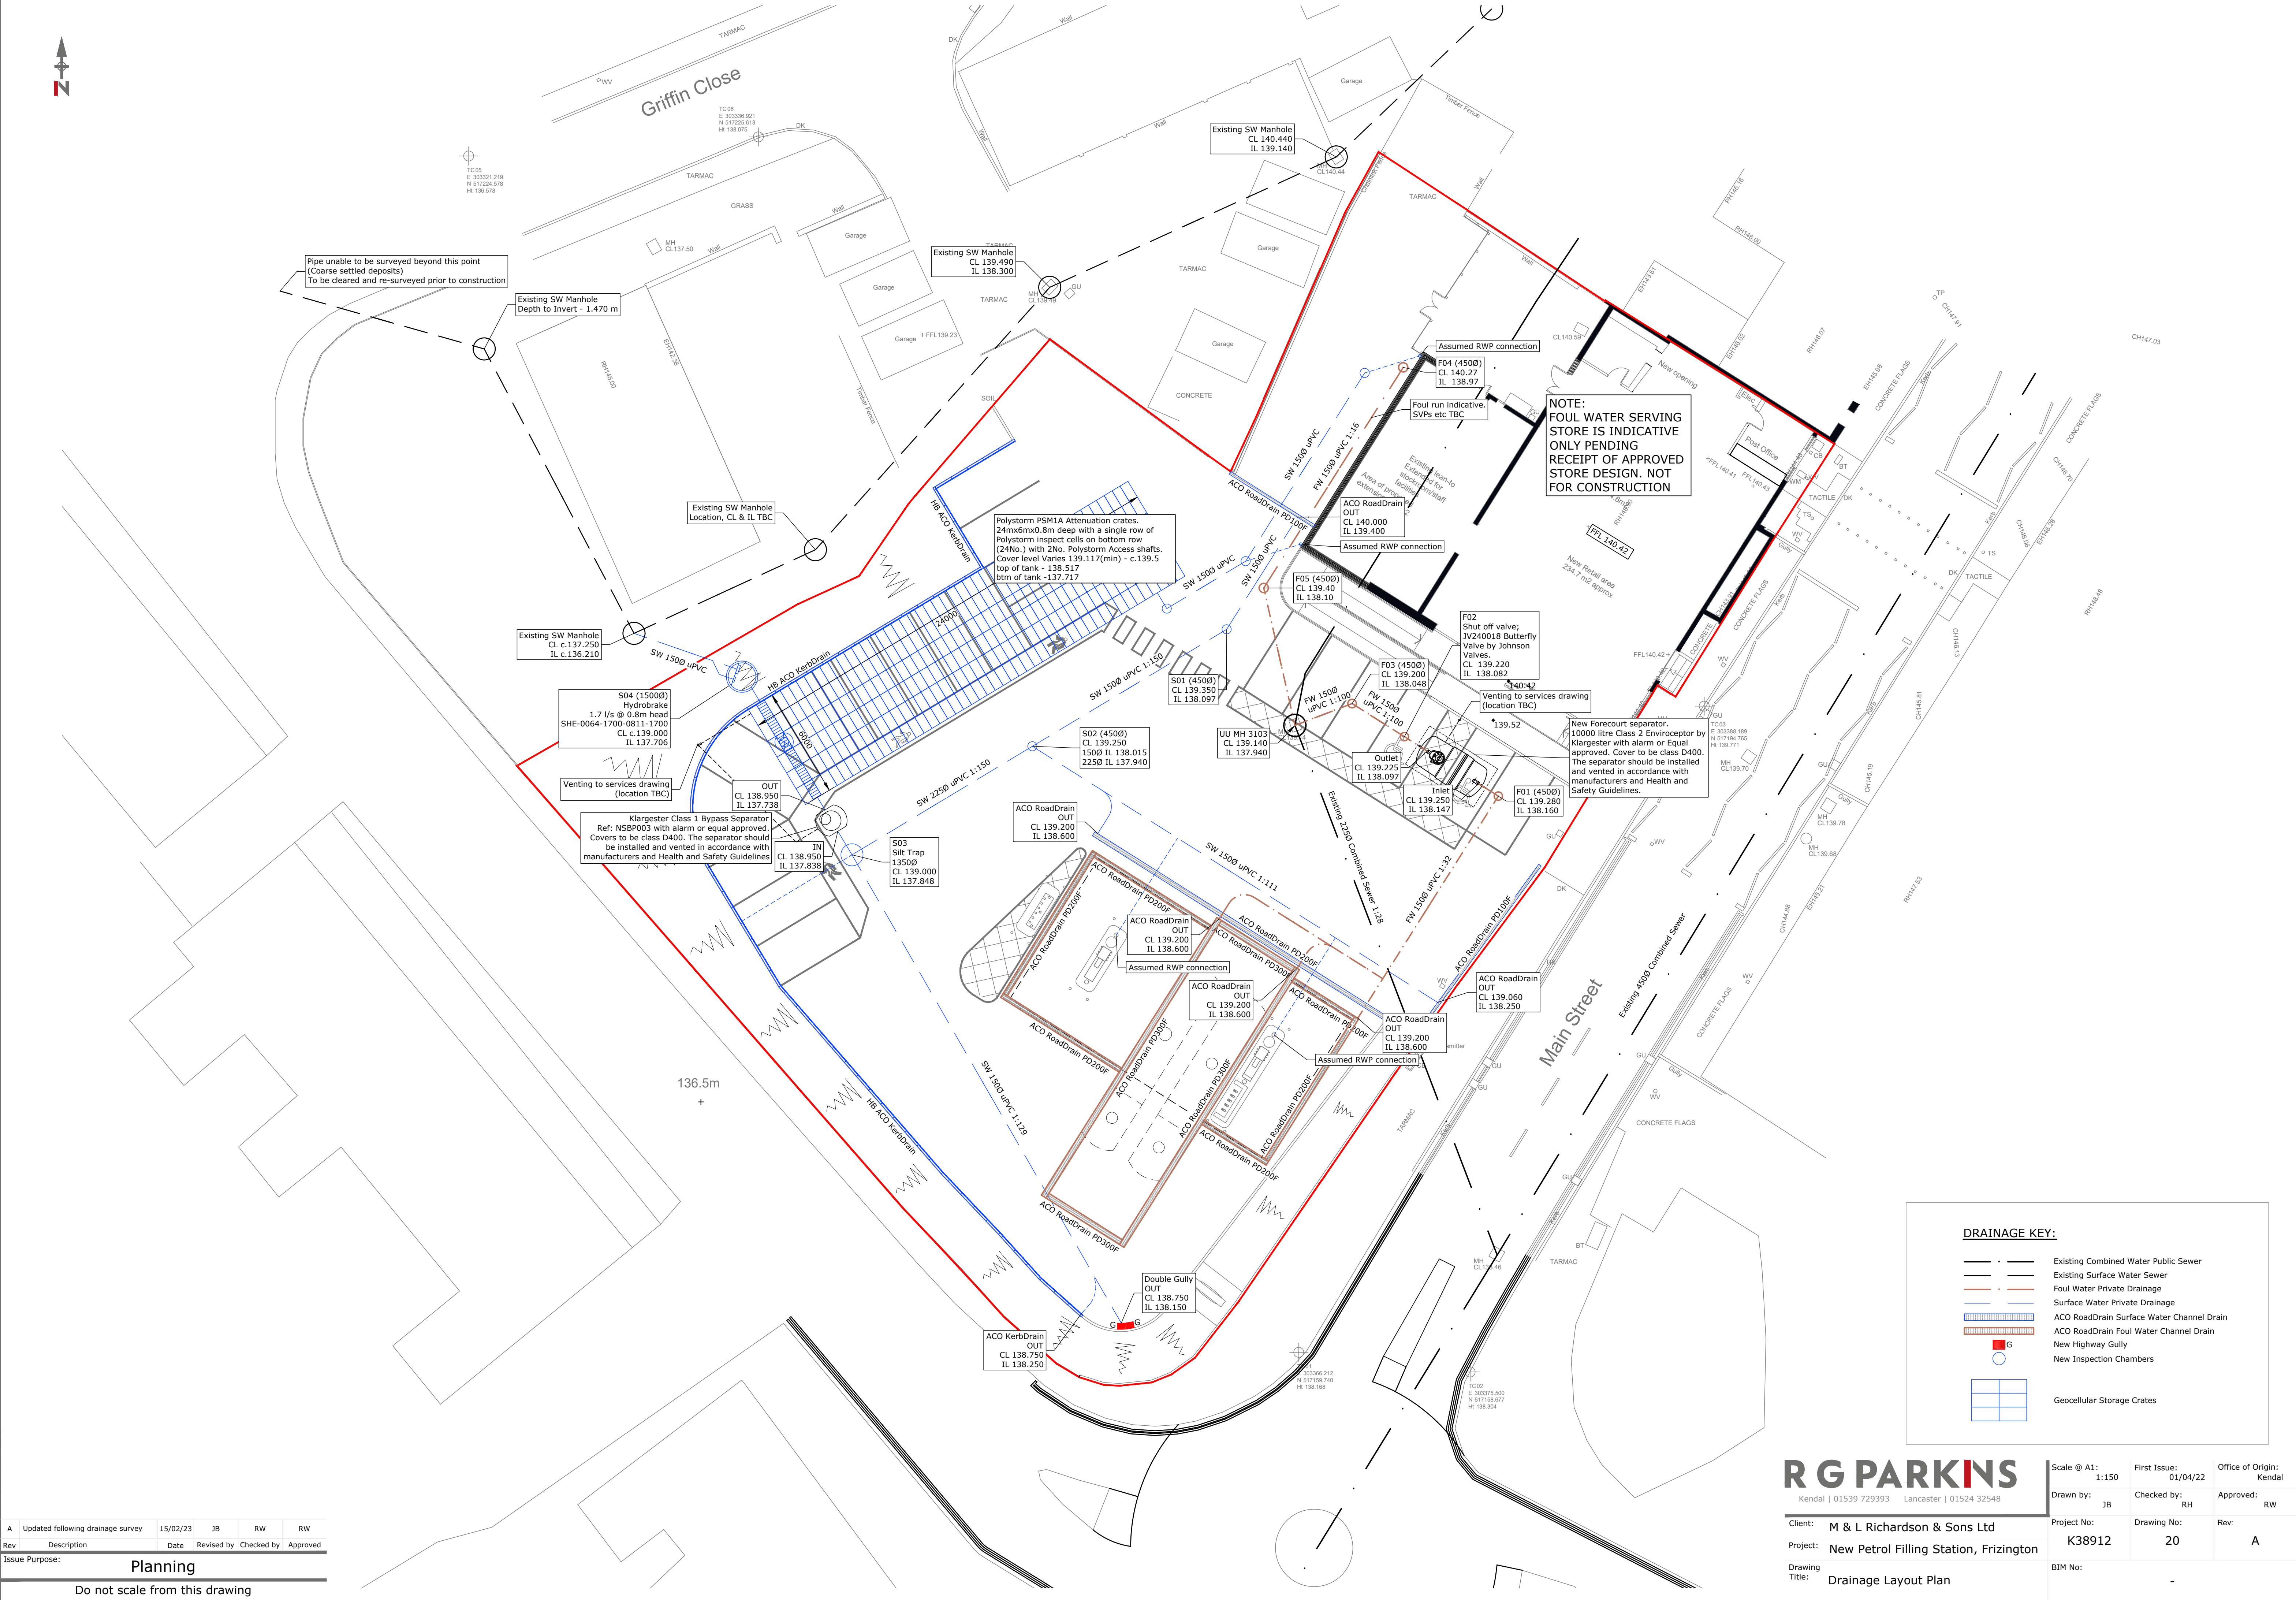

A	Updated following drainage survey	15/02/23	JB	RW	RW
Rev	Description	Date	Revised by	Checked by	Approved
Issue Purpose: Planning					
Do not scale from this drawing					

R G PARKINS

Kendal | 01539 729393 Lancaster | 01524 32548

Client: M & L Richardson & Sons Ltd
Project: New Petrol Filling Station, Frizington
Drawing Title: Drainage Layout Plan

Scale @ A1: 1:150	First Issue: 01/04/22	Office of Origin: Kendal
Drawn by: JB	Checked by: RH	Approved: RW
Project No: K38912	Drawing No: 20	Rev: A
BIM No:		