


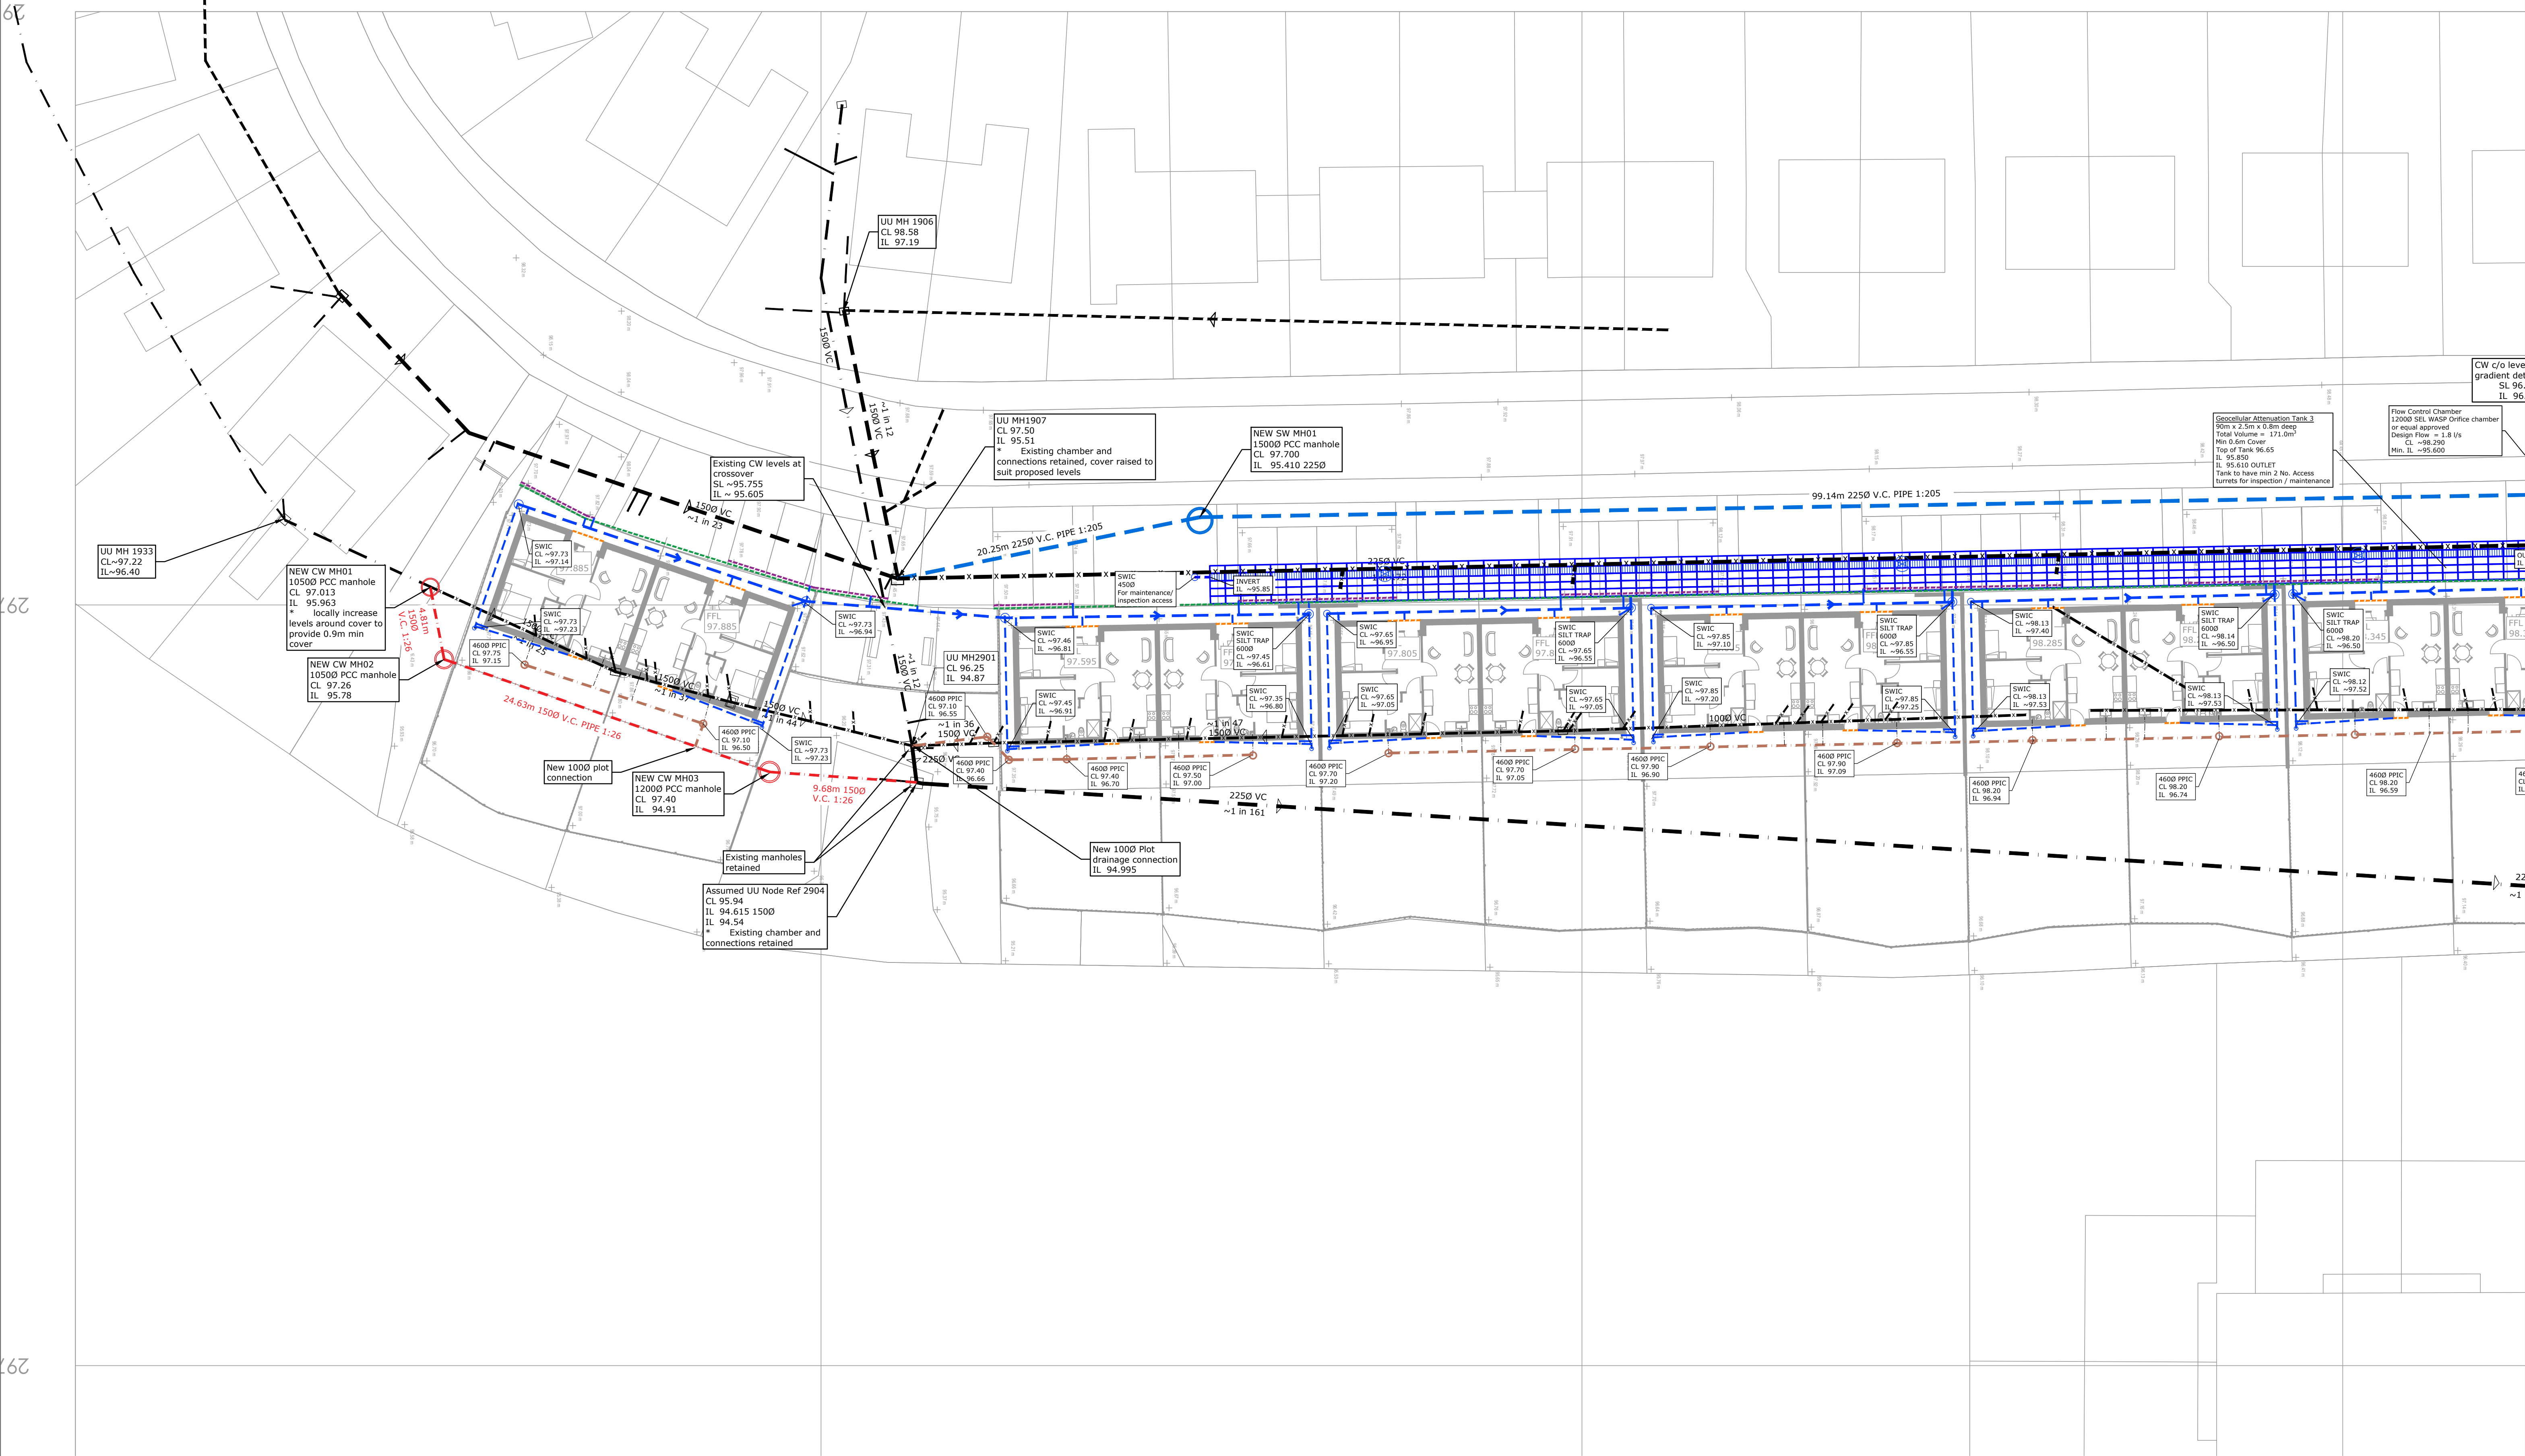

B Drainage updated 28/02/23 CA TM TM					
A Attenuation tanks increased in size to account for 50% climate change 08/11/22 TM TM TM					
Rev	Description	Date	Revised by	Checked by	Approved
Issue Purpose: PLANNING					
Do not scale from this drawing					

PROPOSED PRIVATE DRAINAGE KEY (Indicative only - subject to change)	
	PROPOSED PRIVATE SURFACE WATER SEWER 1500/1000 u.n.o.
	PROPOSED PRIVATE FOUL WATER SEWER 1000 u.n.o.
	PROPOSED THRESHOLD DRAINS TO ARCHITECT'S SPECIFICATION
	PROPOSED DRIVEWAY LINEAR CHANNEL DRAINS (See Detail)
	PROPOSED DRIVEWAY PERFORATED PIPE CONVEYANCE DRAINAGE (See Detail)
	4600 POLYPROPYLENE INSPECTION CHAMBERS u.n.o.

DRAINAGE KEY - SEWER DIVERSIONS & ABANDONMENTS	
	EXISTING PUBLIC COMBINED SEWER
	PROPOSED DIVERSION OF EXISTING PUBLIC COMBINED SEWER
	PROPOSED ABANDONMENT OF EXISTING PUBLIC COMBINED SEWER
	EXISTING PUBLIC SURFACE WATER SEWER
	PROPOSED DIVERSION OF EXISTING PUBLIC SURFACE WATER SEWER
	PROPOSED ABANDONMENT OF EXISTING PUBLIC SURFACE WATER SEWER
	PROPOSED HIGHWAYS DRAINAGE DIVERSION

R G PARKINS
Kendal | 01539 729393 Lancaster | 01524 32548

Client: Thomas Armstrong Ltd
Project: Windermere Rd & Fell View Ave
Drawing Title: Proposed Drainage Plan 1 of 4

Scale @ A1: 1:200	First Issue: 02/08/22	Office of Origin: Kendal
Drawn by: CA	Checked by: TM	Approved: TM
Project No: K39225	Drawing No: 105	Rev: B
BIM No:		