


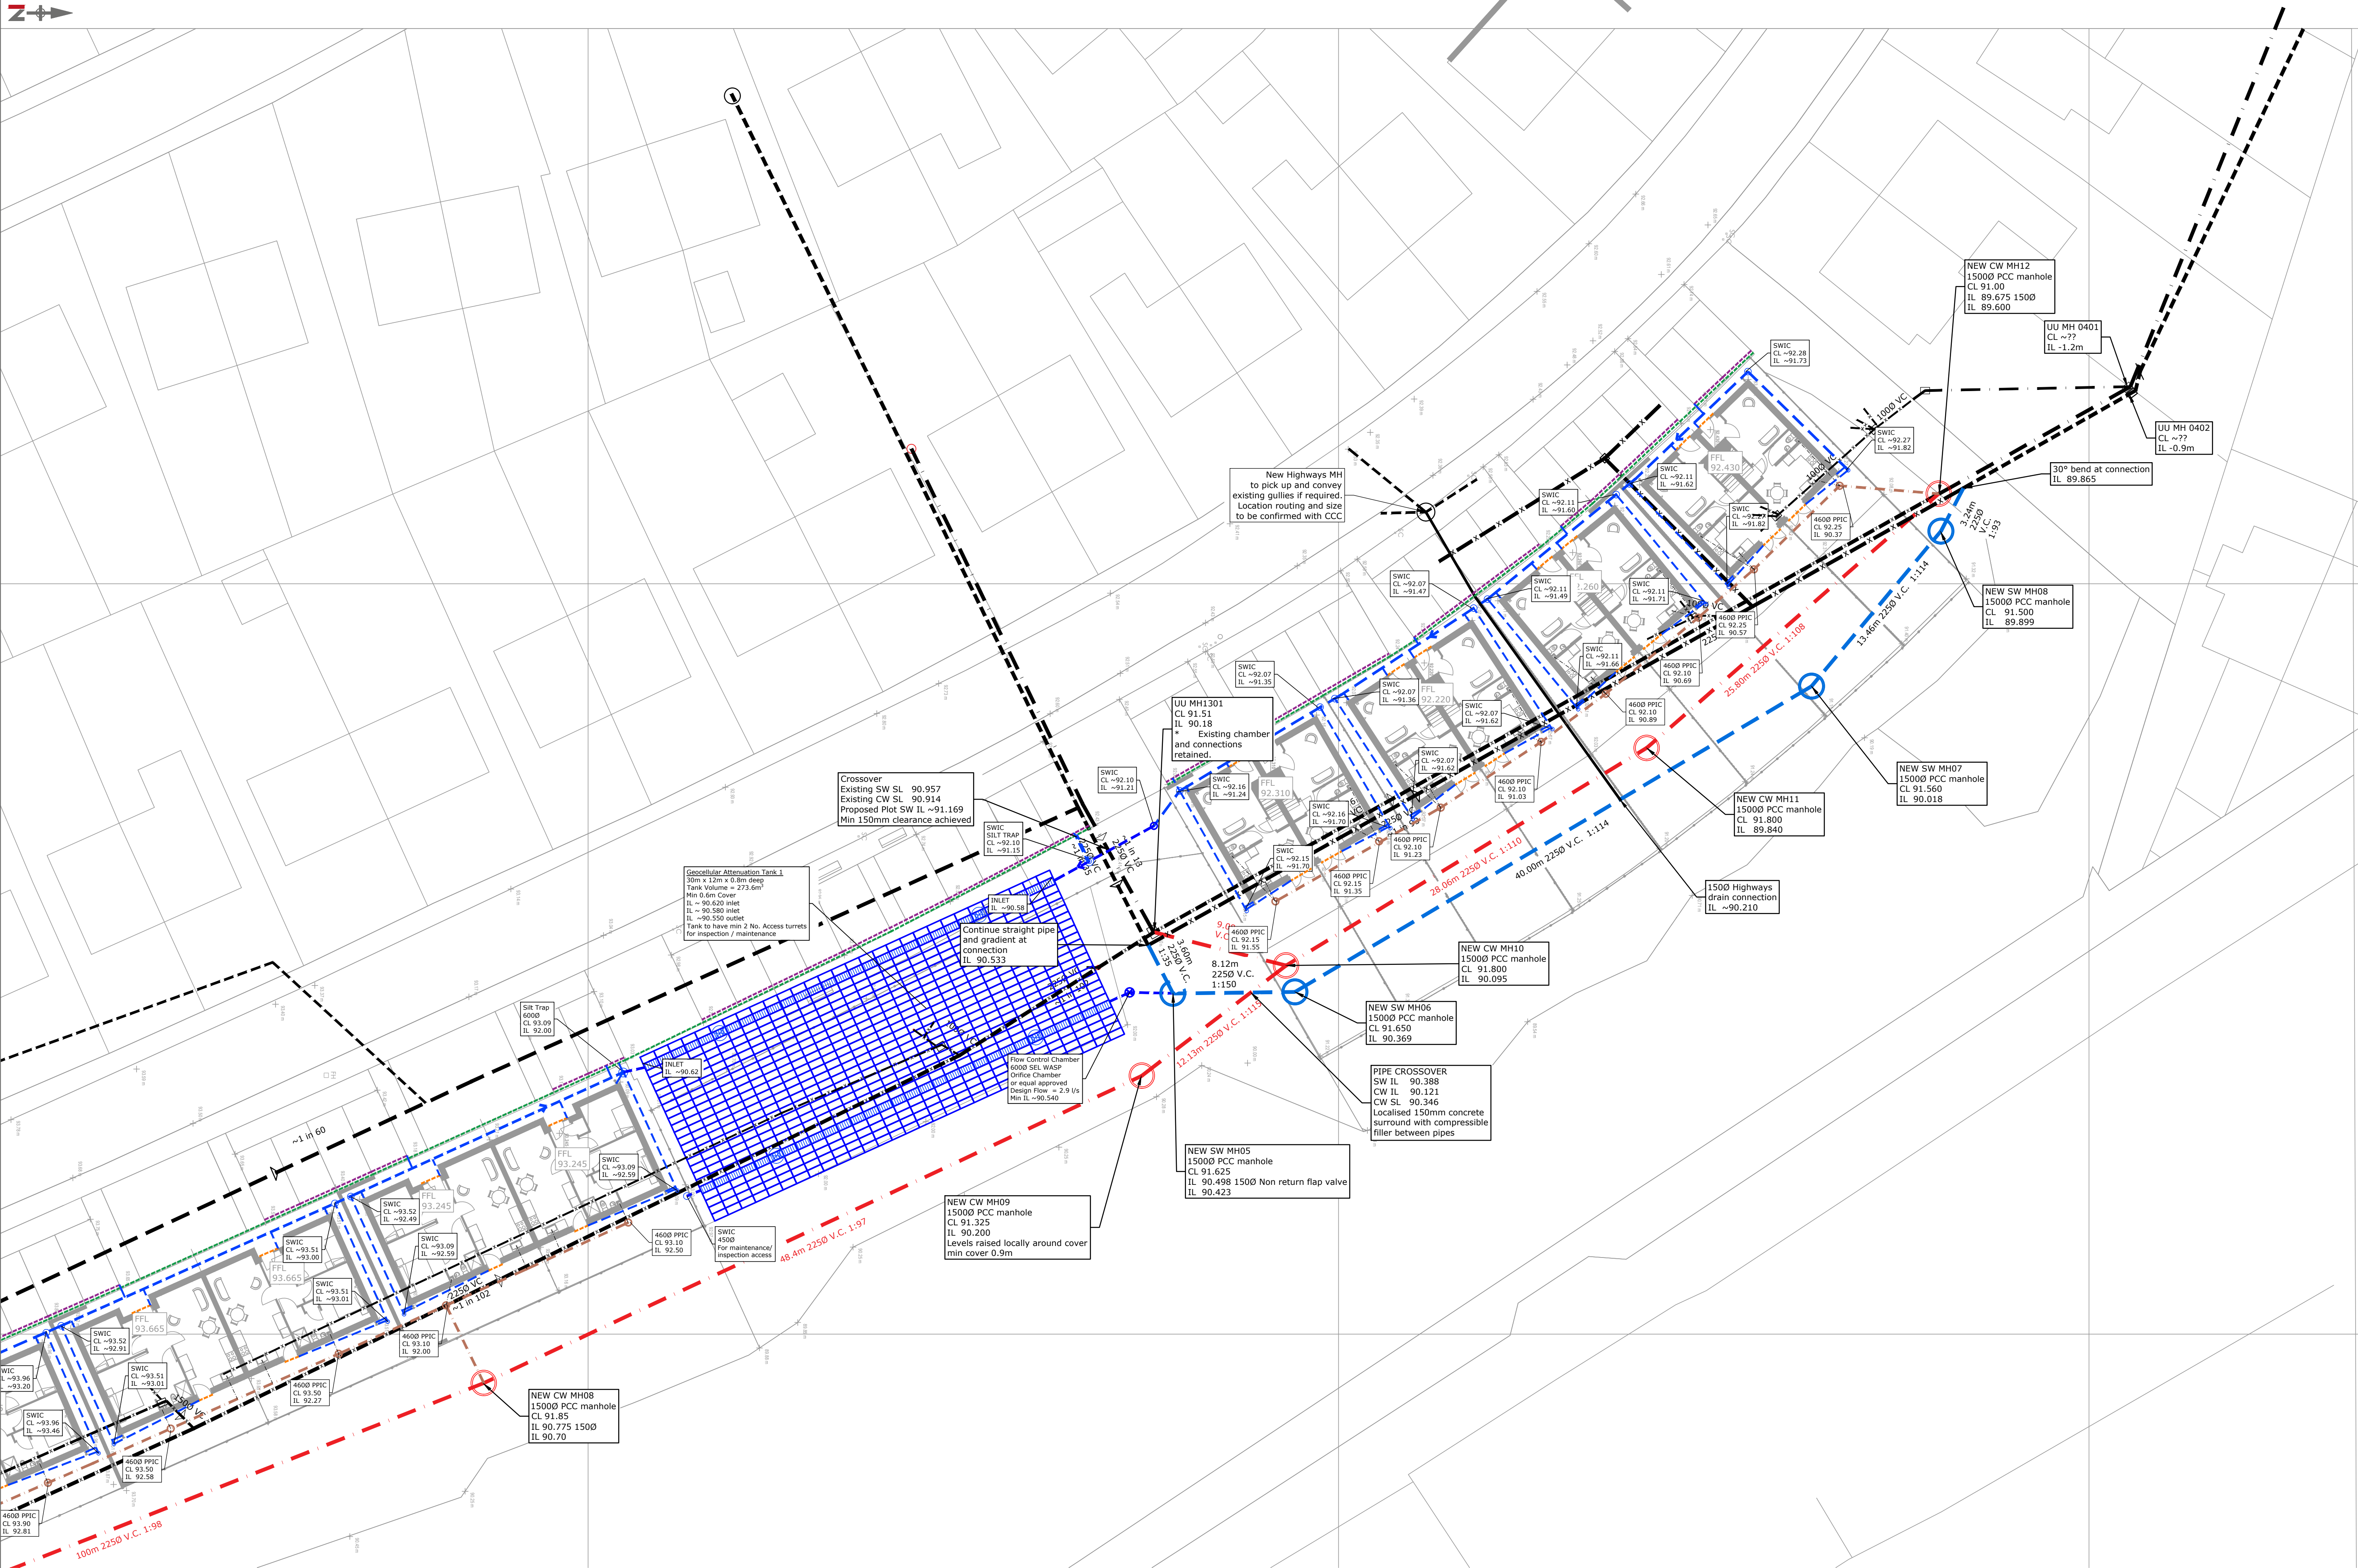

297063

297100

297150



PROPOSED PRIVATE DRAINAGE KEY
(Indicative only - subject to change)

- PROPOSED PRIVATE SURFACE WATER SEWER 1500/1000 u.n.o.
- PROPOSED PRIVATE FOUL WATER SEWER 1000 u.n.o.
- PROPOSED THRESHOLD DRAINS TO ARCHITECT'S SPECIFICATION
- PROPOSED DRIVEWAY LINEAR CHANNEL DRAINS (See Detail)
- PROPOSED DRIVEWAY PERFORATED PIPE CONVEYANCE DRAINAGE (See Detail)
- 4600 POLYPROPYLENE INSPECTION CHAMBERS u.n.o.

B	Drainage updated	28/02/23	CA	TM	TM
A	Attenuation tanks increased in size to account for 50% climate change	08/11/22	TM	TM	TM
Rev	Description	Date	Revised by	Checked by	Approved
Issue Purpose: PLANNING					
Do not scale from this drawing					

DRAINAGE KEY - SEWER DIVERSIONS & ABANDONMENTS

- EXISTING PUBLIC COMBINED SEWER
- PROPOSED DIVERSION OF EXISTING PUBLIC COMBINED SEWER
- PROPOSED ABANDONMENT OF EXISTING PUBLIC COMBINED SEWER
- EXISTING PUBLIC SURFACE WATER SEWER
- PROPOSED DIVERSION OF EXISTING PUBLIC SURFACE WATER SEWER
- PROPOSED ABANDONMENT OF EXISTING PUBLIC SURFACE WATER SEWER
- PROPOSED HIGHWAYS DRAINAGE DIVERSION

R G PARKINS
Kendal | 01539 729393 | Lancaster | 01524 32548

Client: **Thomas Armstrong Ltd**

Project: **Windermere Rd & Fell View Ave**

Drawing Title: **Proposed Drainage Plan 4 of 4**

Scale @ A1: 1:200

Drawn by: CA

Project No: **K39225**

BIM No:

First Issue: 02/08/22

Checked by: TM

Drawing No: **108**

Office of Origin: Kendal

Approved: TM

Rev: **B**