


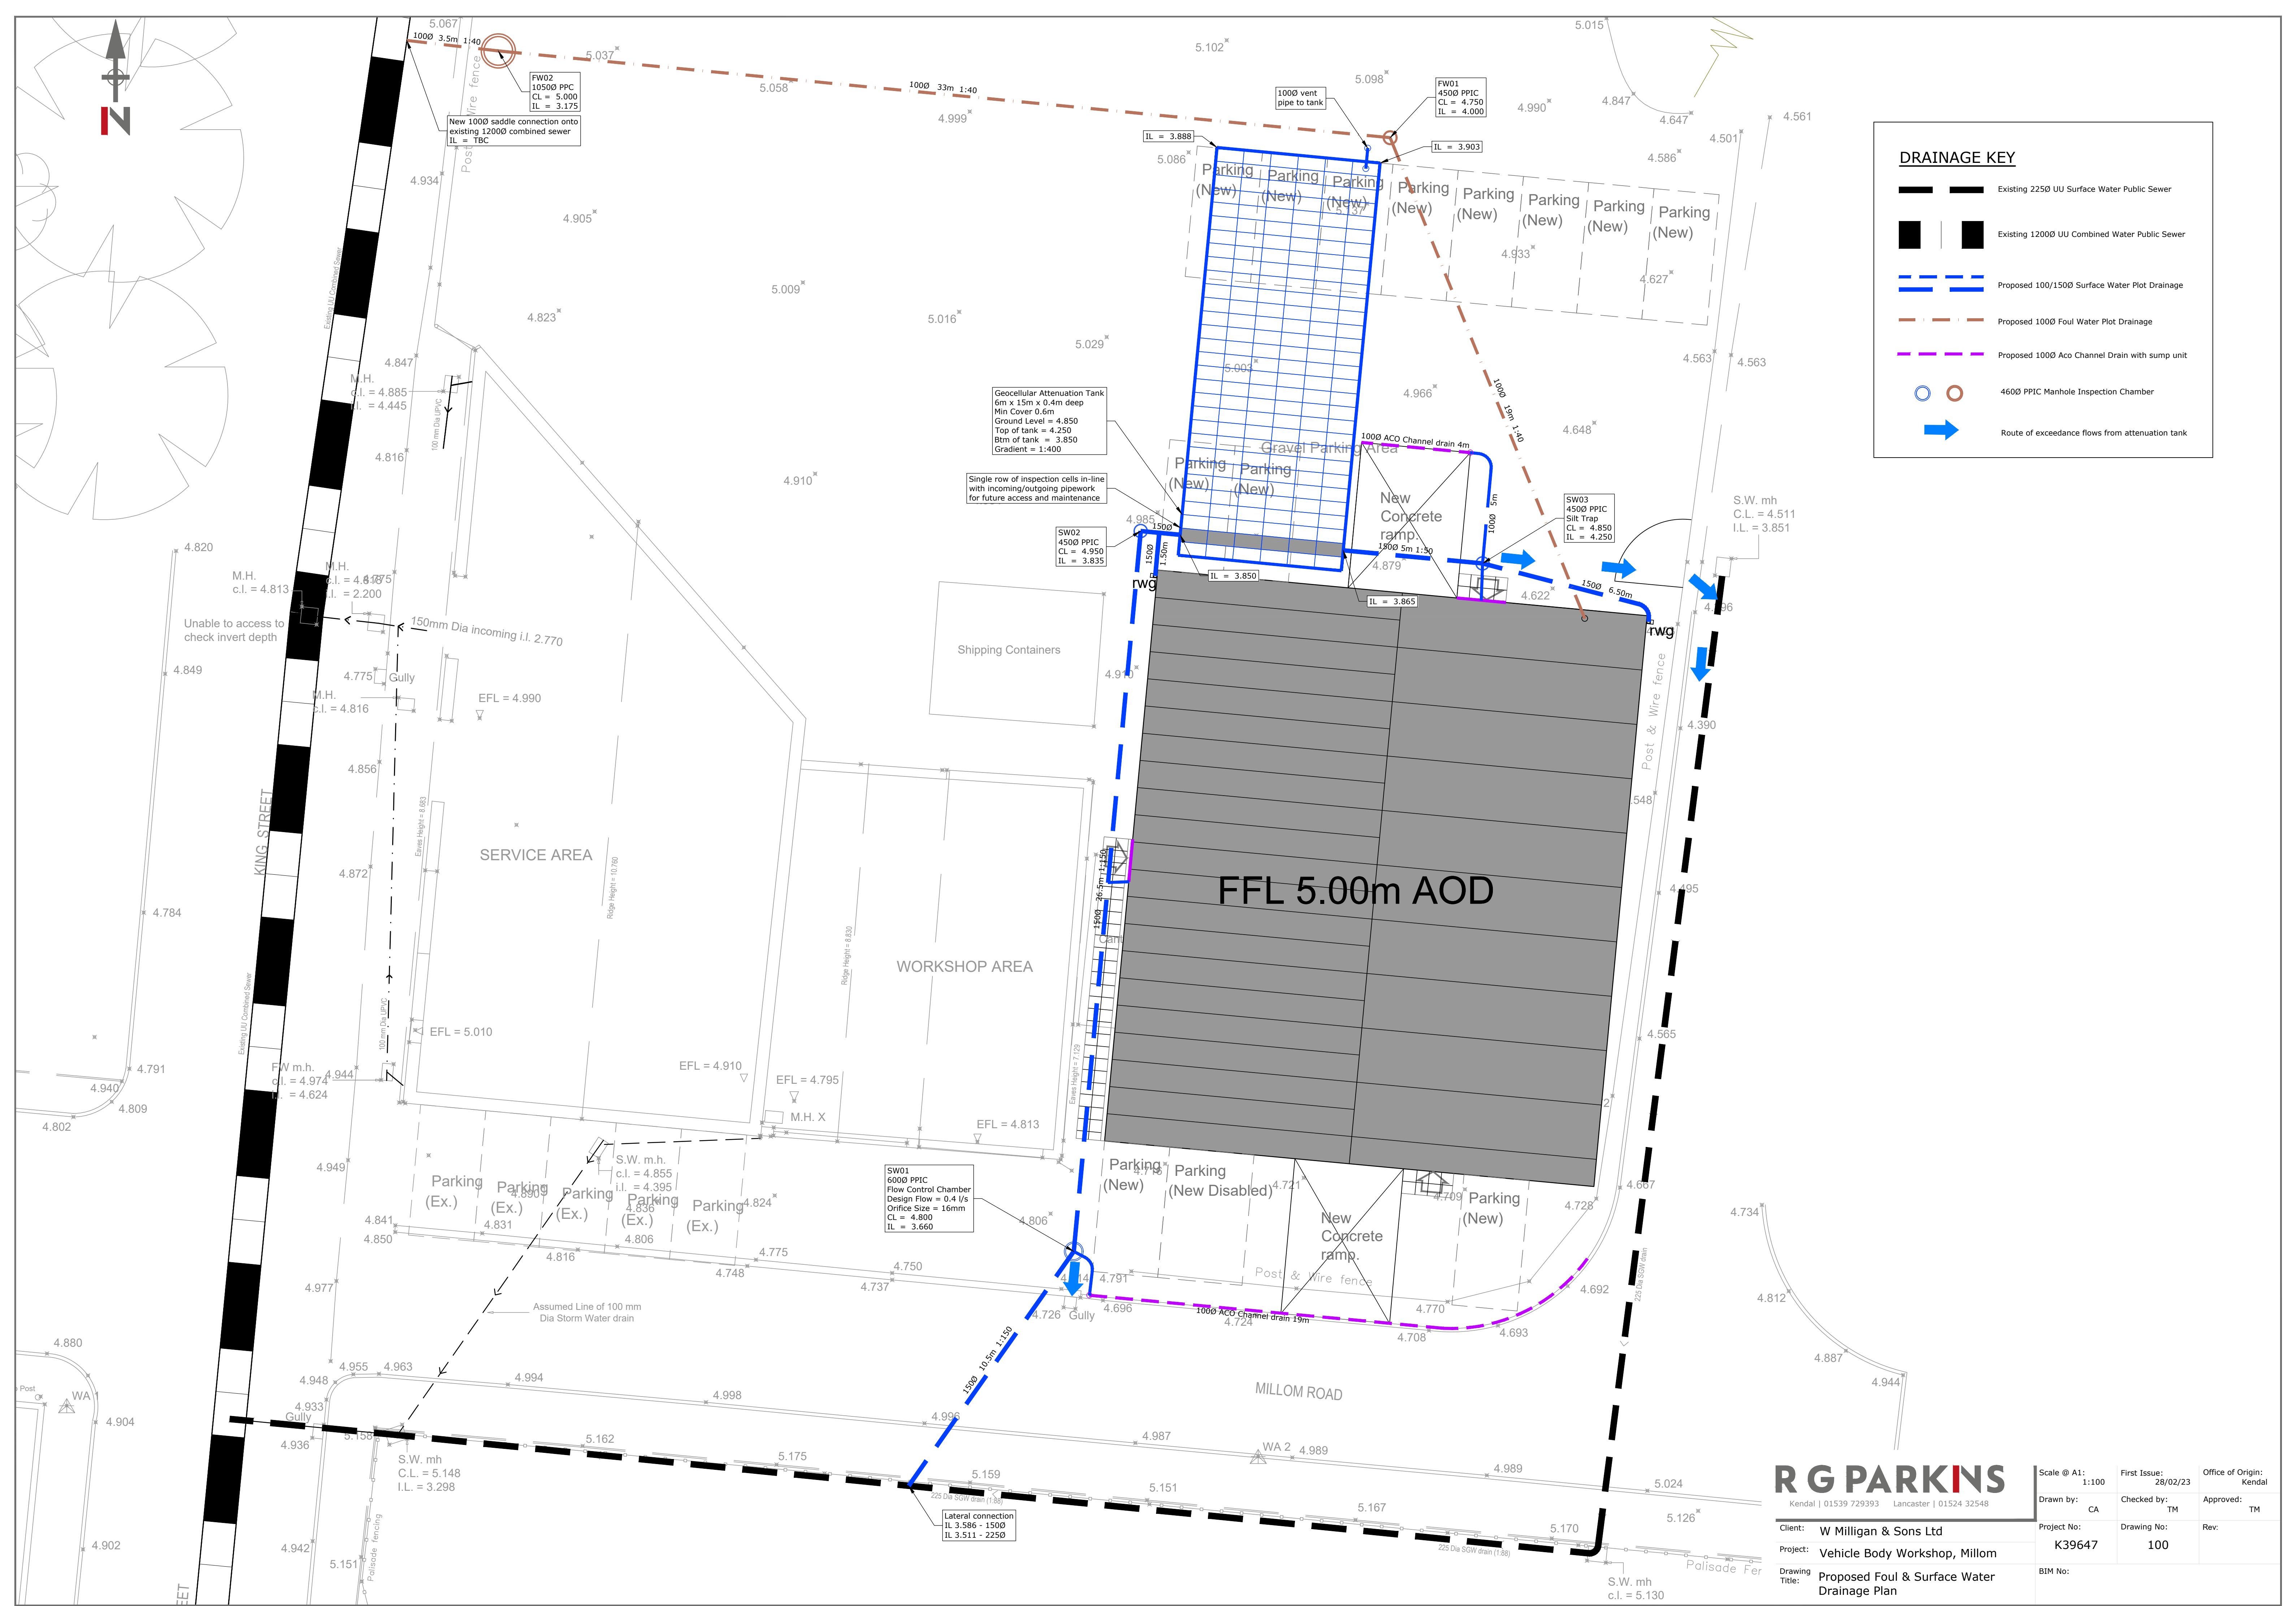

DRAINAGE KEY

- Existing 2250 UU Surface Water Public Sewer
- Existing 12000 UU Combined Water Public Sewer
- Proposed 100/1500 Surface Water Plot Drainage
- Proposed 1000 Foul Water Plot Drainage
- Proposed 1000 Aco Channel Drain with sump unit
- 4600 PPIC Manhole Inspection Chamber
- Route of exceedance flows from attenuation tank

R G PARKINS
Kendal | 01539 729393 | Lancaster | 01524 32548

Client: **W Milligan & Sons Ltd**
Project: **Vehicle Body Workshop, Millom**
Drawing Title: **Proposed Foul & Surface Water Drainage Plan**

Scale @ A1: 1:100	First Issue: 28/02/23	Office of Origin: Kendal
Drawn by: CA	Checked by: TM	Approved: TM
Project No: K39647	Drawing No: 100	Rev:
BIM No:		