



2 Section 6
1 : 50

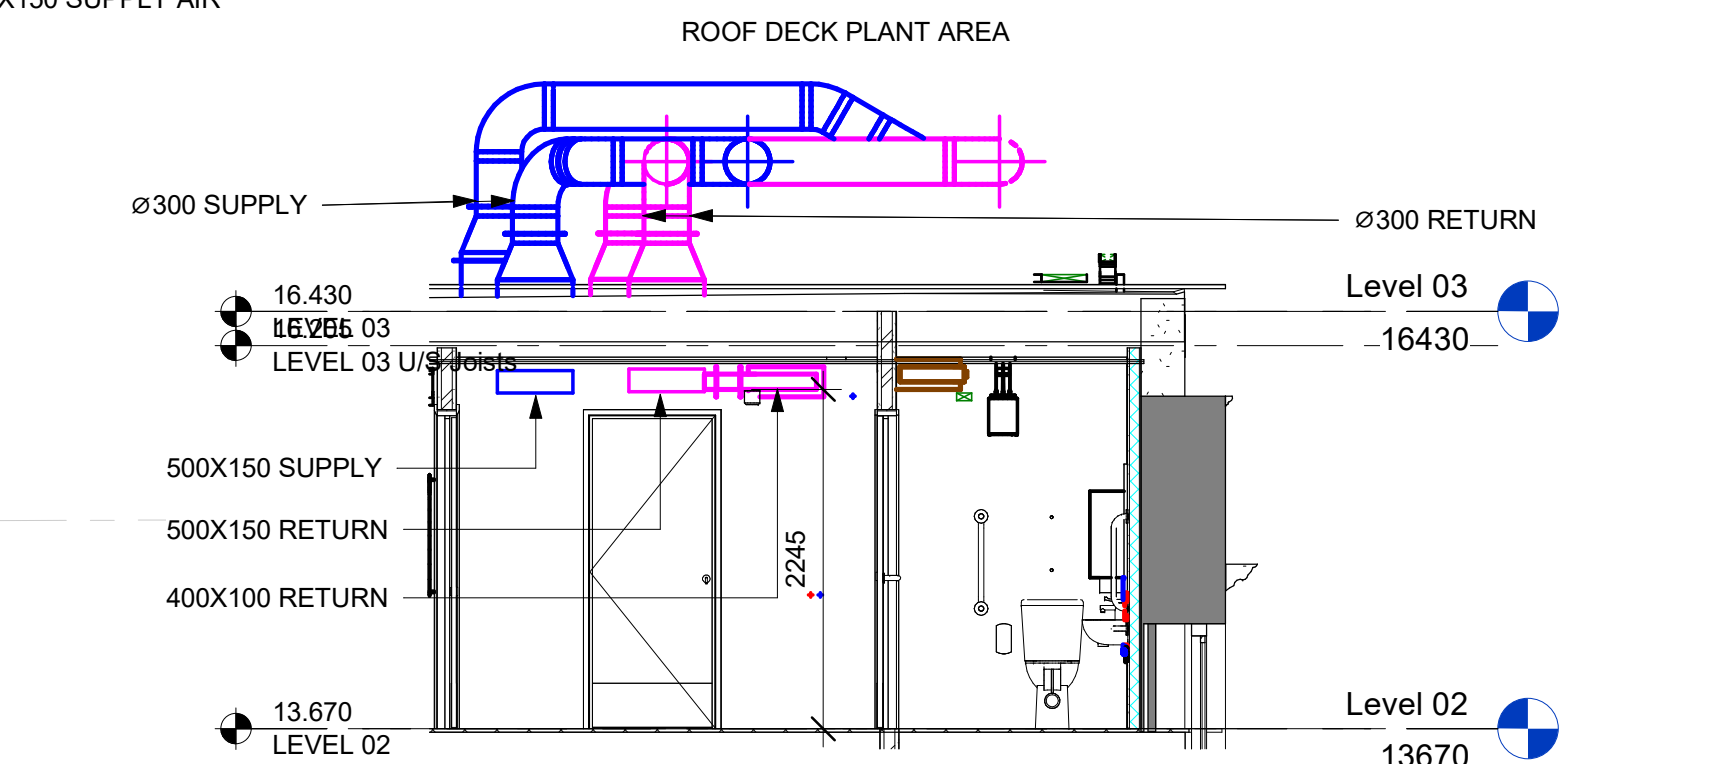

3 Section 7
1 : 50

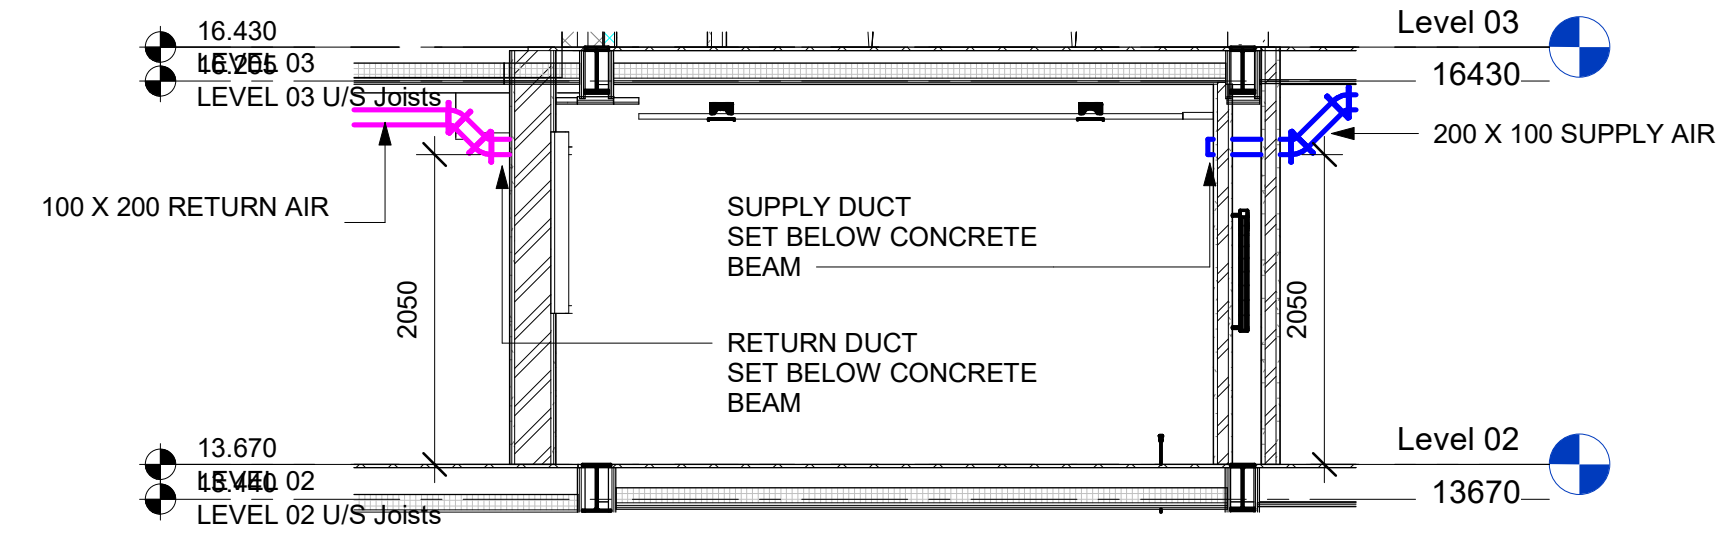

5 Section 10
1 : 50

Safety, Health and Environmental Information

IN ADDITION TO THE HAZARDS / RISKS NORMALLY ASSOCIATED WITH THE TYPE OF WORK DETAILED ON THIS DRAWING, NOTE THE FOLLOWING:

Construction

-

Maintenance/Cleaning

-

Decommissioning/Demolition

-

IT IS ASSUMED THAT ALL WORKS WILL BE CARRIED OUT BY A COMPETENT CONTRACTOR WORKING, WHERE APPROPRIATE, TO AN APPROVED METHOD STATEMENT. THIS IS NOT AN EXHAUSTIVE LIST AND REFERENCE SHOULD BE MADE TO THE HEALTH AND SAFETY FILE.

LEGEND

SUPPLY AIR

EXHAUST AIR

FRESH AIR INTAKE

RETURN AIR

DIRTY AIR

HRU HEAT RECOVERY UNIT.

ABBREVIATIONS

EF EXTRACT FAN

VCD VOLUME CONTROL DAMPER

FD FIRE DAMPER

SG SUPPLY AIR GRILLE

EG EXTRACT AIR GRILLE

C03	UPDATED AS PER CO-ORDINATION WITH ARCHITECTURAL CHANGES	AW	GG	28.03.25
C02	UPDATED AS PER M&E COORDINATION	RM	GG	21.02.25
C01	CONSTRUCTION ISSUE	RM	GG	10.01.25
Rev	Description	By	App	Date

LINK

MEP CONSULTING ENGINEERS

Albany Court
Newcastle Business Park
Newcastle upon-Tyne
NE4 7YB

Tel: (0191) 242 0699
Web: www.linkmep.com

Copyright ©
Link MEP Consulting Engineers Ltd

Client

BEC

Project Title

DIGITAL AND GAMING HUB
WHITEHAVEN - LEVELS

Drawing Title

MECHANICAL SERVICES
LEVEL 02
VENTILATION LAYOUT

Scale @ A1	Description/Issued For	Status
1 : 50	CONSTRUCTION	
Drawing Number		Revision
LUWH-LNK-XX-02-DR-M-57001		C03