
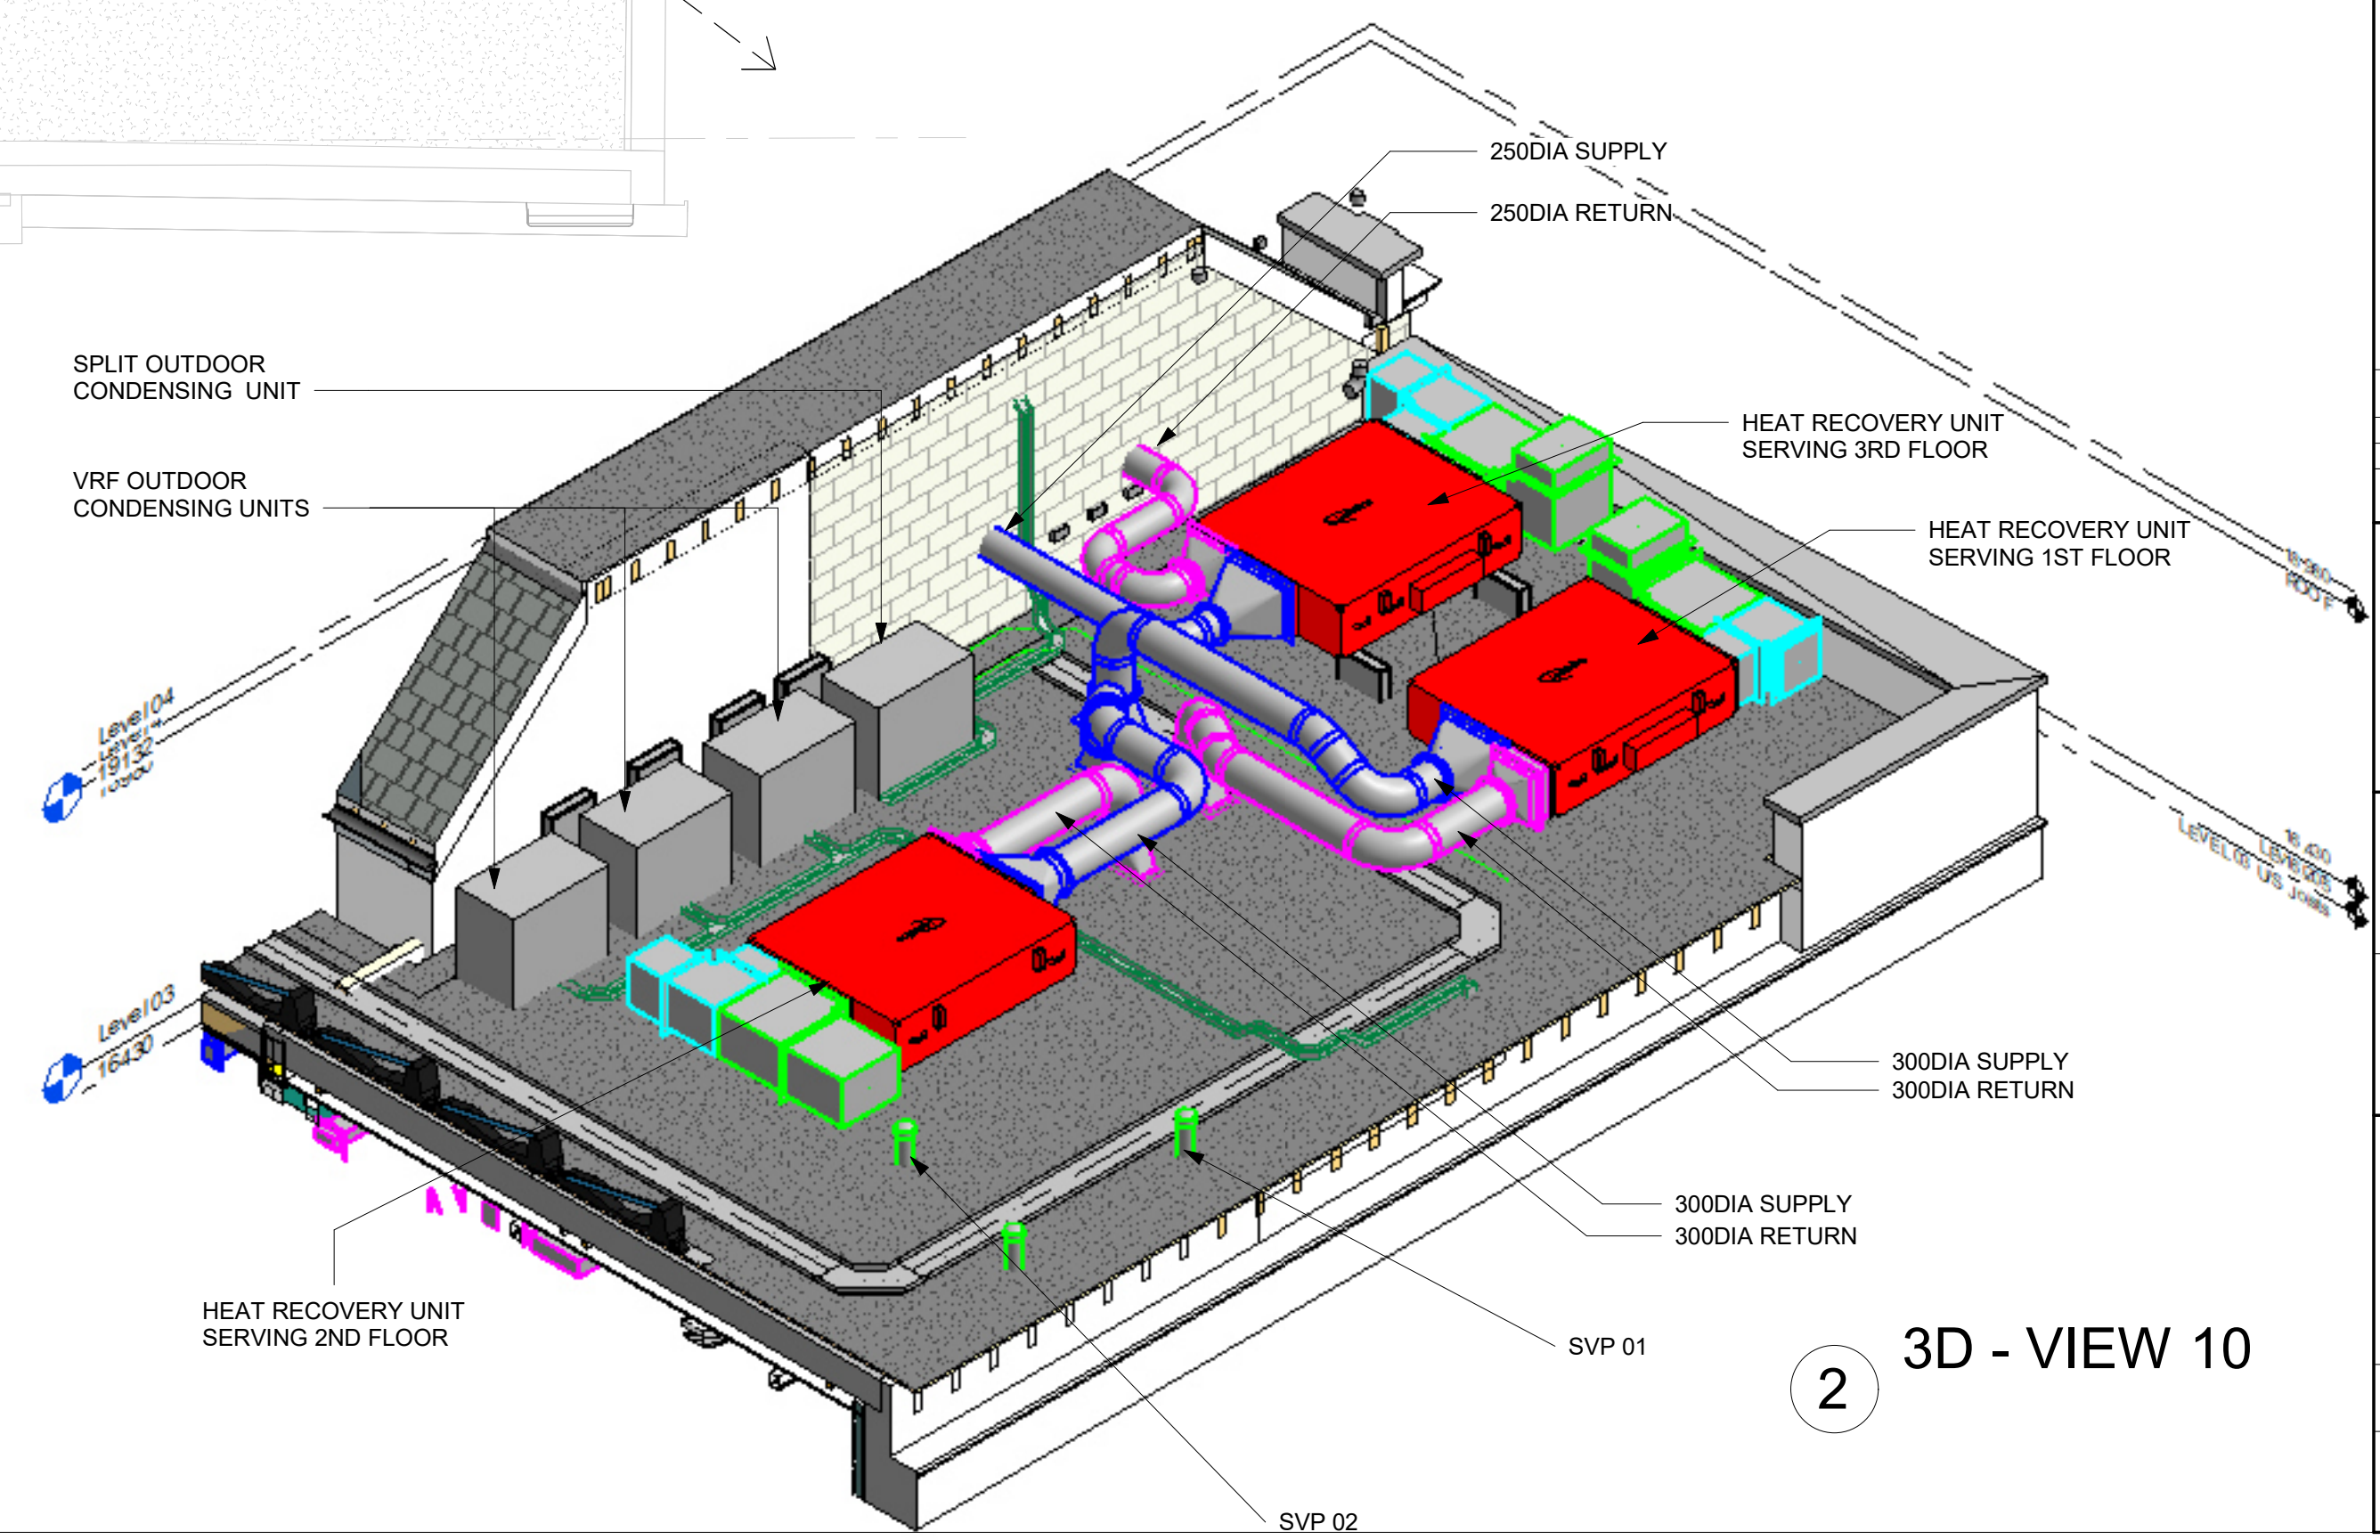


3 Section 14
1 : 50

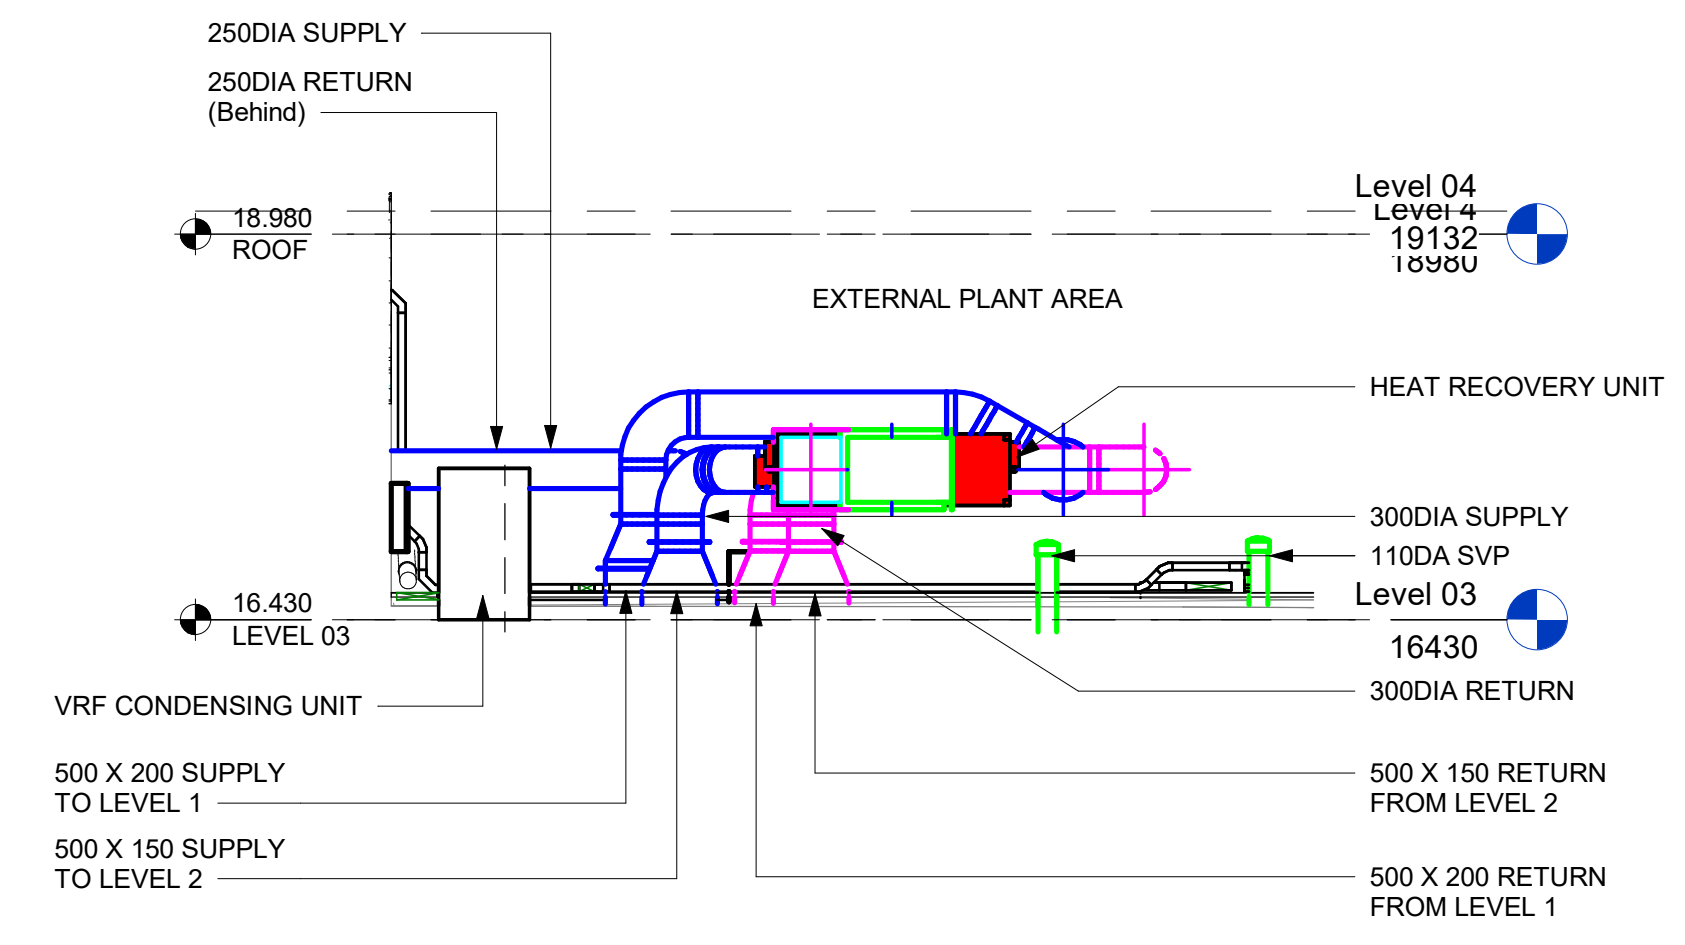

2 3D - VIEW 10

Safety, Health and Environmental Information

IN ADDITION TO THE HAZARDS / RISKS NORMALLY ASSOCIATED WITH THE TYPE OF WORK DETAILED ON THIS DRAWING, NOTE THE FOLLOWING:

Construction

-

Maintenance/Cleaning

-

Decommissioning/Demolition

-

IT IS ASSUMED THAT ALL WORKS WILL BE CARRIED OUT BY A COMPETENT CONTRACTOR WORKING, WHERE APPROPRIATE, TO AN APPROVED METHOD STATEMENT. THIS IS NOT AN EXHAUSTIVE LIST AND REFERENCE SHOULD BE MADE TO THE HEALTH AND SAFETY FILE.

LEGEND

SUPPLY AIR

EXHAUST AIR

FRESH AIR INTAKE

RETURN AIR

DIRTY AIR

HRU HEAT RECOVERY UNIT.

ABBREVIATIONS

EF EXTRACT FAN

VCD VOLUME CONTROL DAMPER

FD FIRE DAMPER

SG SUPPLY AIR GRILLE

EG EXTRACT AIR GRILLE

| | | | | |
|-----|---------------------------------------------------------|----|-----|----------|
| C03 | UPDATED AS PER CO-ORDINATION WITH ARCHITECTURAL CHANGES | AW | GG | 28.03.25 |
| C02 | UPDATED AS PER M&E COORDINATION | RM | GG | 21.02.25 |
| C01 | CONSTRUCTION ISSUE | RM | GG | 10.01.25 |
| Rev | Description | By | App | Date |

LINK

MEP CONSULTING ENGINEERS

Albany Court
Newcastle Business Park
Newcastle upon-Tyne
NE4 7YB
Tel: (0191) 242 0699
Web: www.linkmep.com
Copyright ©
Link MEP Consulting Engineers Ltd

Client

BEC

Project Title

DIGITAL AND GAMING HUB
WHITEHAVEN - LEVELS

Drawing Title

MECHANICAL SERVICES
LEVEL 03
VENTILATION LAYOUT

| | | |
|---------------------------|------------------------|----------|
| Scale @ A1 | Description/Issued For | Status |
| 1 : 50 | CONSTRUCTION | |
| Drawing Number | | Revision |
| LUWH-LNK-XX-03-DR-M-57001 | | C03 |