


This drawing shall not be scaled.
Work from the dimensions shown in the drawing or given in relevant specifications

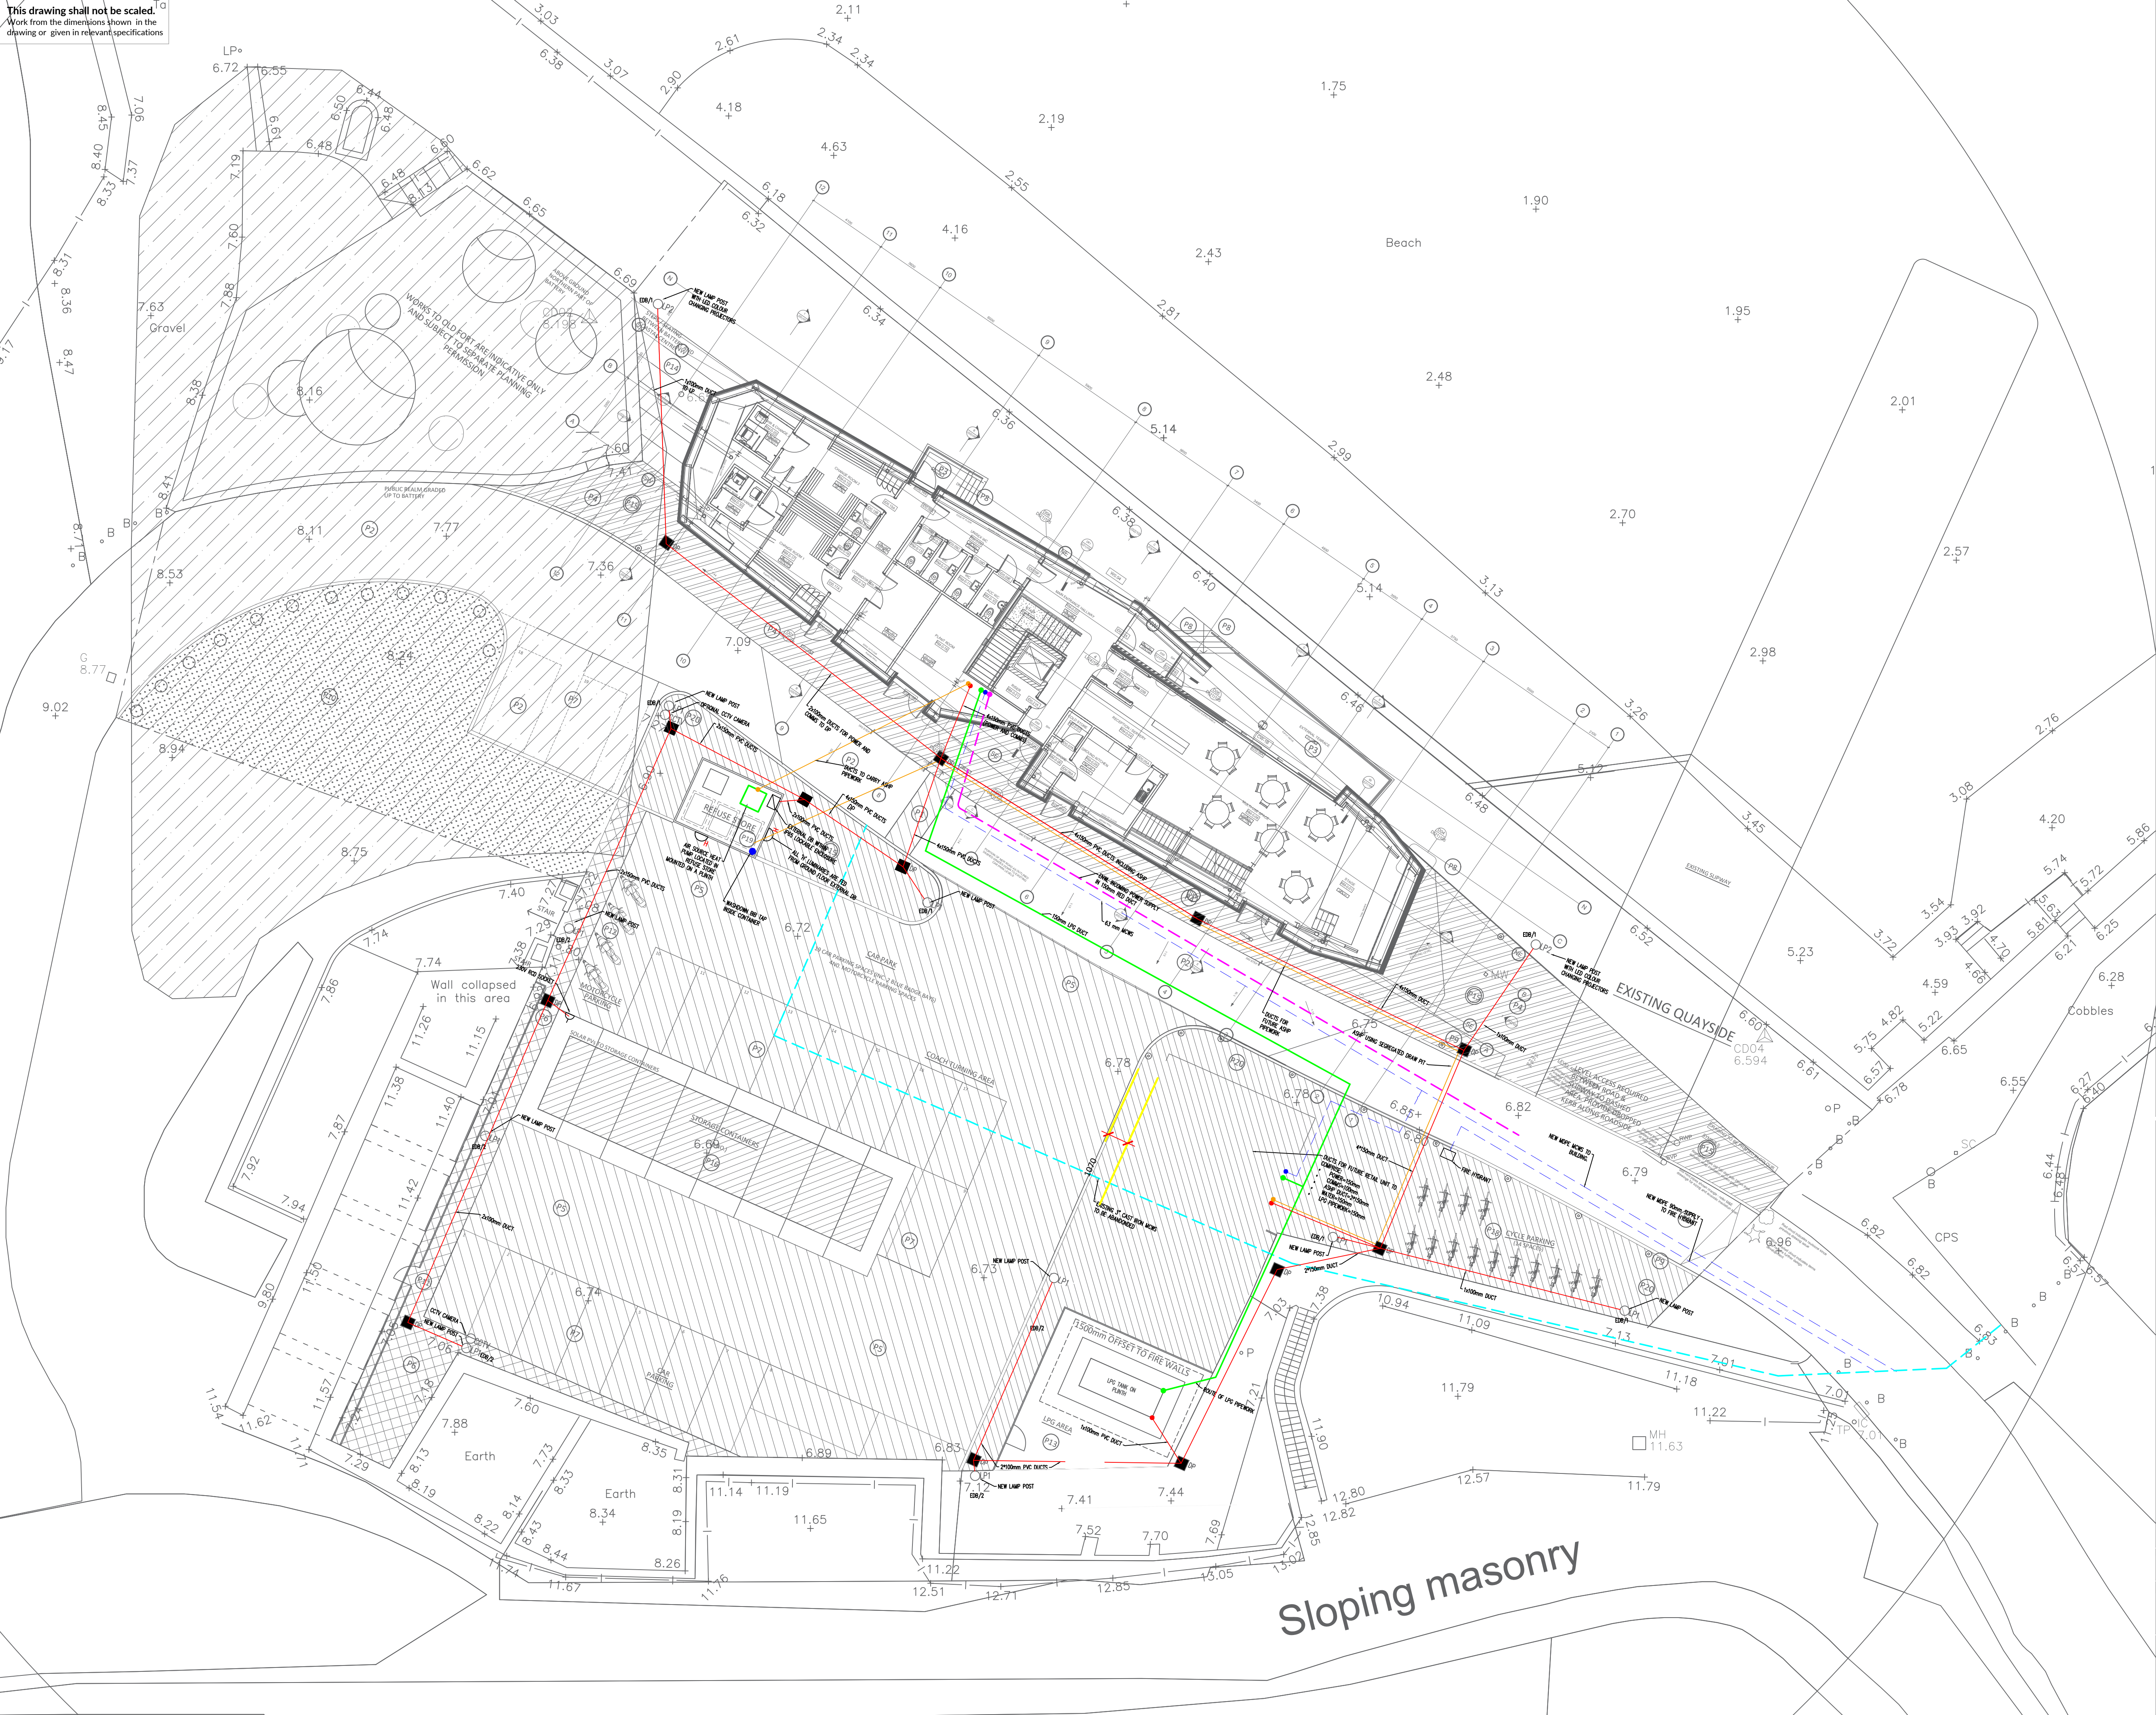

CDM Regulations:

In addition to any information included in this drawing or the model from which it is derived, refer also to the project CDM Risk Register for information on residual risks.

General Notes:

- The drawing does not necessarily show all the information needed to interpret the design intent or the construction details.
- The drawing contains information from more than one source and must be read in conjunction with all relevant specifications.
- Any apparent drafting errors and differences between other drawings and specifications shall be brought to our attention.

Project Notes:

- THIS DRAWING DOES NOT INDICATE THE WALL MOUNTED BUILDING EXTERNAL LUMINARIES WHICH ARE SHOWN ON THE GROUND FLOOR LIGHTING LAYOUT DRAWINGS.
- REFER TO SEPARATE LIGHTING PROPOSAL DOCUMENT.

EXTERNAL LIGHTING KEY:

P8 - WALL MOUNTED LED LUMINAIRE

LP1 - 6M LIGHTING COLUMN COMPLETE WITH POST TOP LANTERN

LP2 - 6M LIGHTING COLUMN COMPLETE WITH COLOUR CHANGING LED PROJECTORS

C02	CONTRACT ISSUE	SD	SH	PT	08/22
C01	CONTRACT ISSUE	SD	SM	PT	05/22
Index	Description	Designed	Reviewed	Authorised	Date

REVISIONS:

HOARE LEA 

ARCHITECT:
Northmill Associates

CLIENT:
Whitehaven Harbour Commissioners

PROJECT TITLE:
THE EDGE CUMBRIA

DRAWING TITLE:
M&E External Services Layout

Contract Issue

PERSON RESPONSIBLE FOR:		
Design:	Review:	Authorising Issue:
HK	PT	PT
Project No:	Date:	Scale @ A1:
0308104	March 2022	1:150 @ A1
DRAWING NUMBER:	Revision:	
0308104-HLEA-XX-SP-DR-UE-100-0001	C02	