


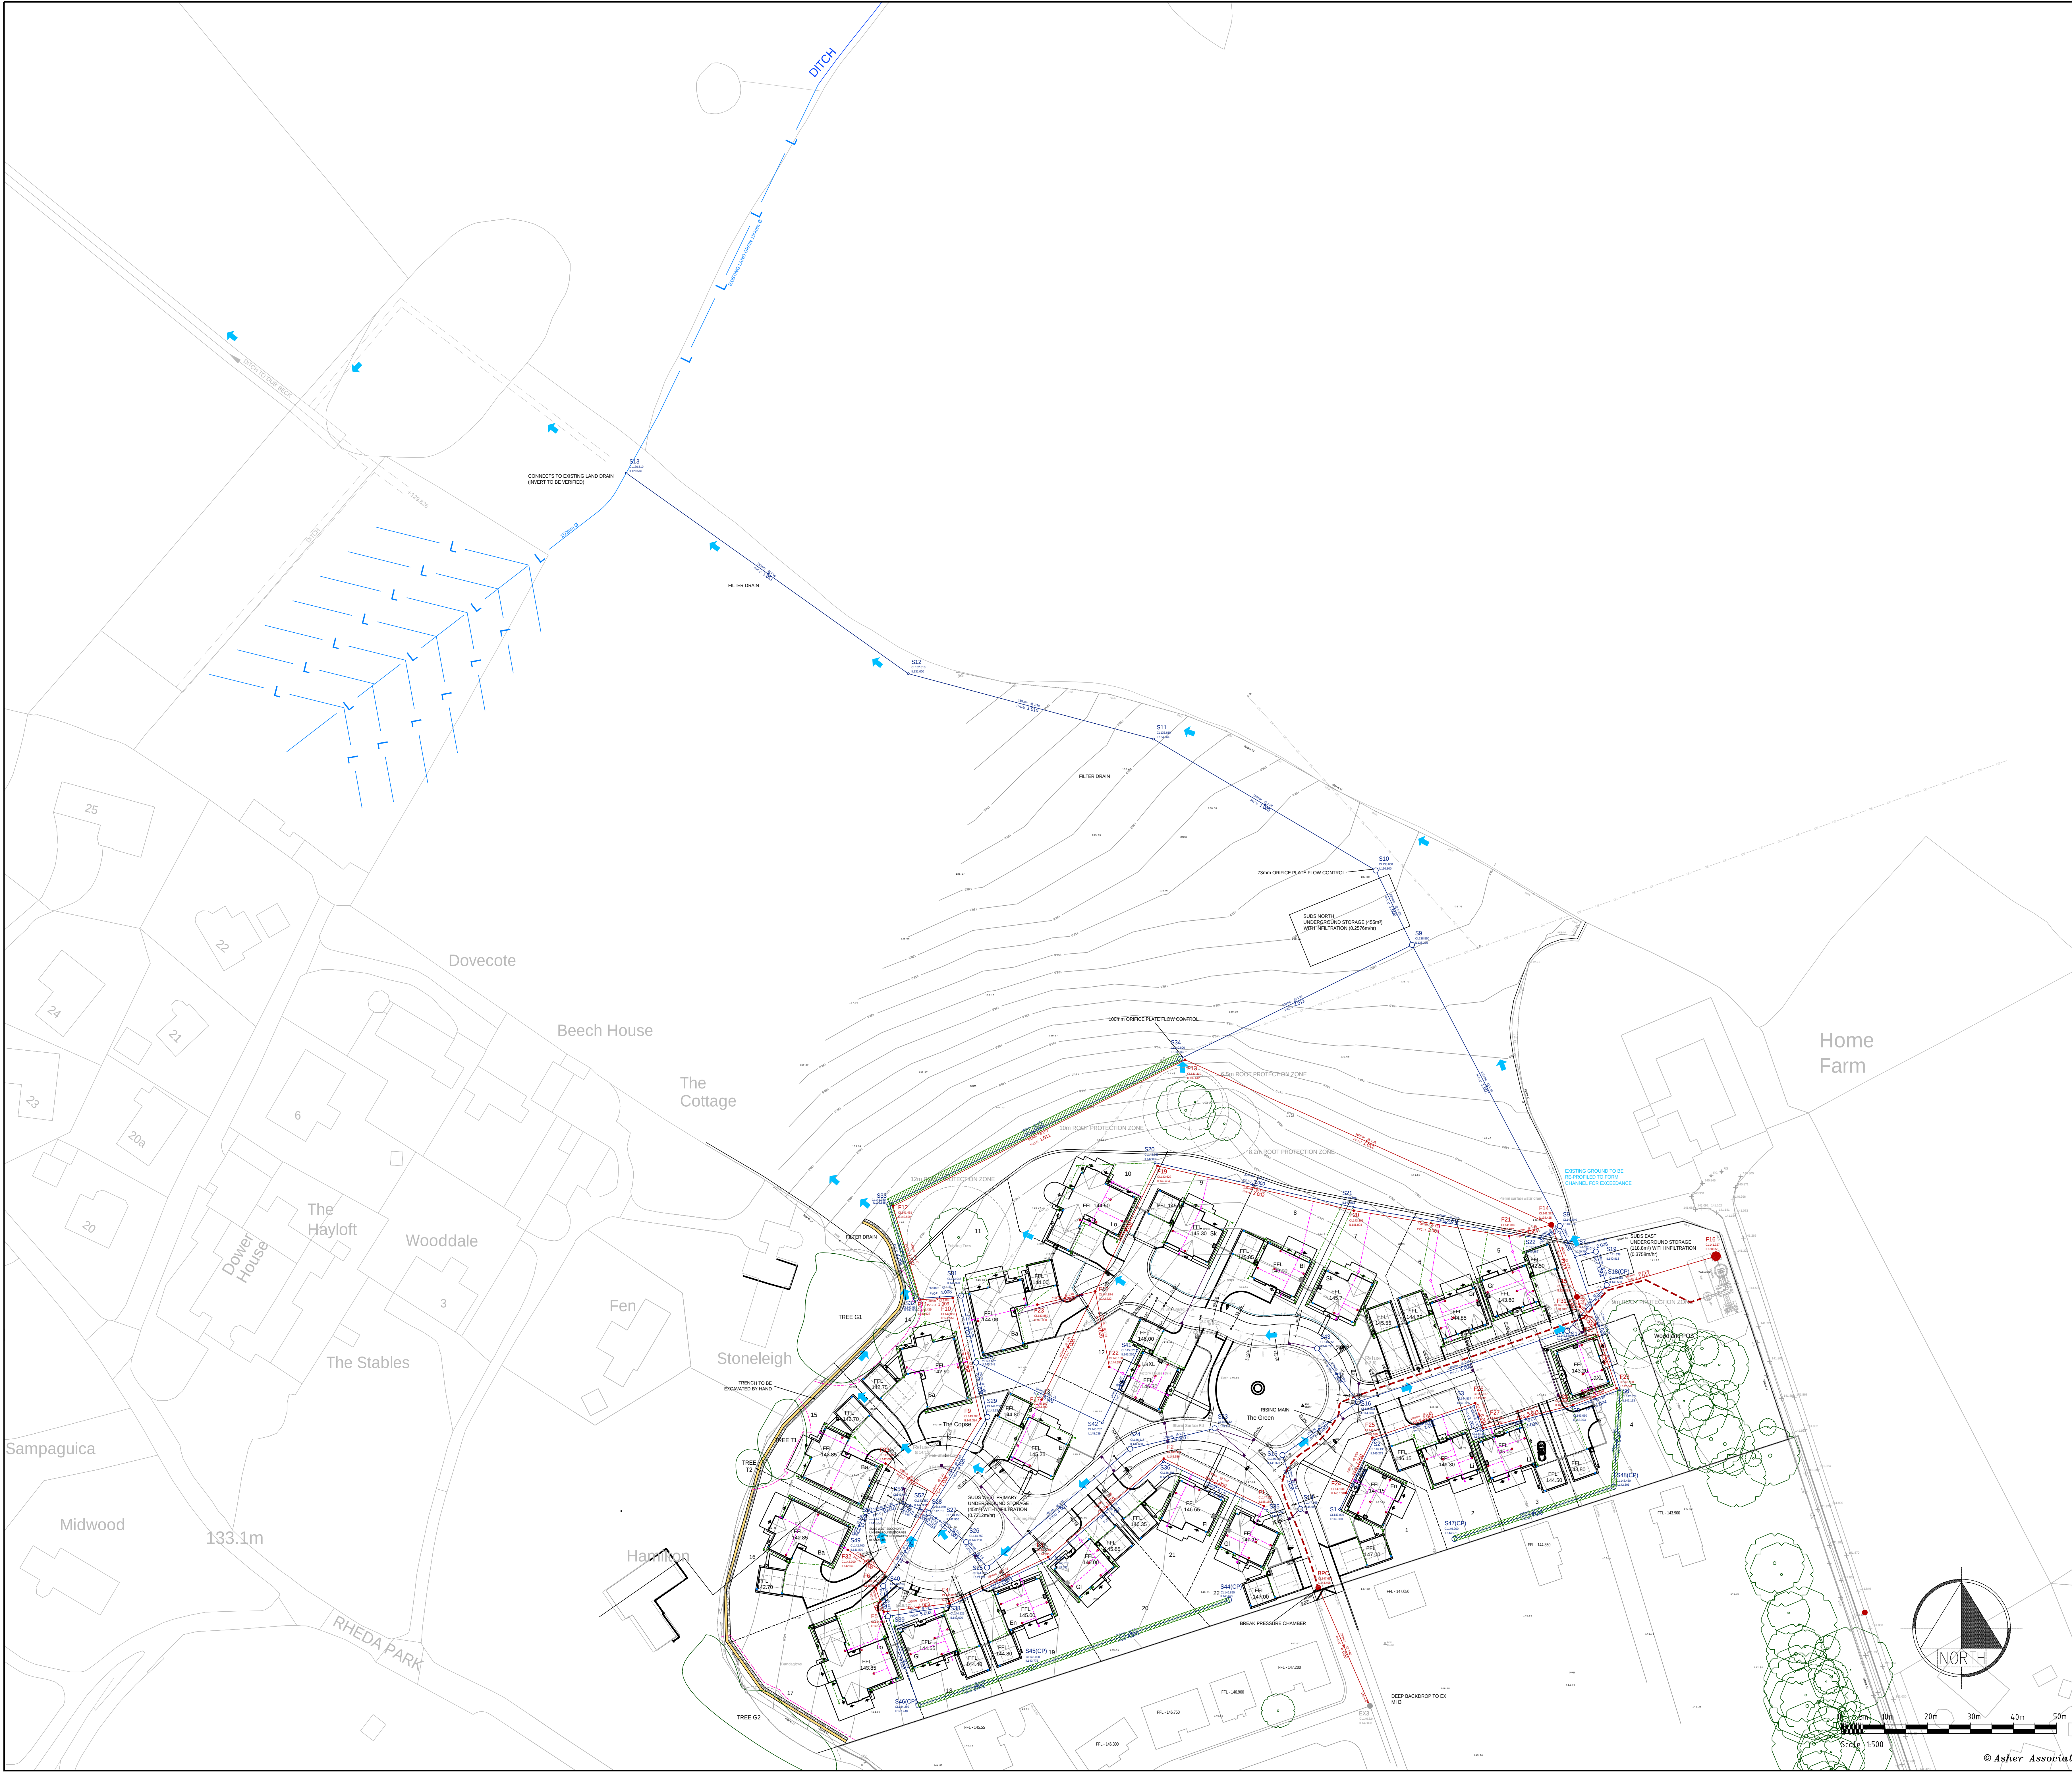


- NOTES.
- DO NOT SCALE FROM THIS DRAWING.
 - ALL DIMENSIONS ARE IN METRES UNLESS OTHERWISE STATED.

KEY: PROPOSED DRAINAGE

- ADOPTABLE HIGHWAY DRAIN
- PRIVATE SURFACE WATER DRAIN
- PRIVATE FOUL SEWER
- MANHOLE
- MANHOLE WITH BACKDROP
- CATCHPIT
- HEADWALL
- GULLY
- CHANNEL DRAIN
- SURFACE WATER INSPECTION CHAMBER
- FOUL INSPECTION CHAMBER
- RODDING EYE
- RISING MAIN
- DRAINAGE EXCEEDANCE ROUTE
- INFILTRATION TRENCH
- KESTED HEDGE
- ROOT PROTECTION AREA
- EXISTING TREE CROWN SPREAD
- TREE PROTECTION FENCING

- KEY:
- STREETLIGHT
- PRIVATE STREETLIGHT

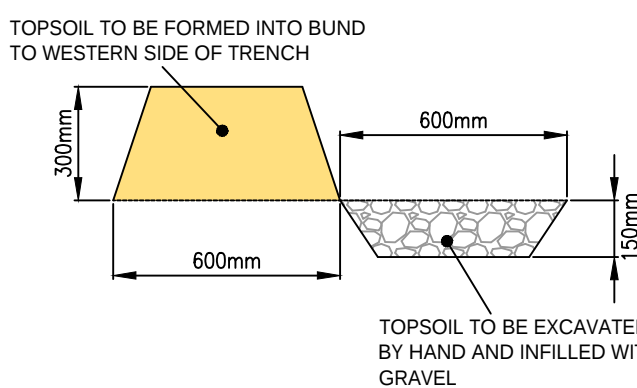

J	TREE CANOPIES AND ROOT PROTECTION ZONES AMENDED.	ROM	WAM	WAM	11/10/20
H	GULLY CONNECTIONS AT PLOT 14 & 15 AMENDED, KESTED HEDGE EXTENDED.	ROM	WAM	WAM	11/10/20
G	WEST DRAINAGE REVISED.	ROM	WAM	WAM	11/10/20
F	OFF-SITE DRAINAGE AMENDED.	ROM	WAM	WAM	11/10/20
E	MANHOLE S14 REMOVED.	ROM	WAM	WAM	11/10/20
D	UPDATED AS PER A47281/EW/02E.	ROM	WAM	WAM	11/10/20
C	INFILTRATION TRENCH ADDED TO KEY, LIGHTING COLUMNS SHOWN.	RJ	WAM	WAM	11/10/20
B	MANHOLES S46 TO S50 ADDED, COVER LEVELS UPDATED, DRAINAGE EXCEEDANCE ROUTE ADDED, MANHOLES S2 TO S8 ALTERED, SUDS NORTH & WEST ALTERED.	ROM	WAM	WAM	11/10/20
A	GULLIES ADDED.	ROM	WAM	WAM	11/10/20

Rev.	Amendment	By	Checked	Approved	Date
------	-----------	----	---------	----------	------

PLANNING APPLICATION

Status	Appd.	Date
--------	-------	------

Client

KCS AGRICULTURAL LTD

Project

NORTH PARK RHEDA,
PHASE 2

Title

OVERALL DRAINAGE LAYOUT

Drawn	Date	Checked	Date	Approved	Date
ROM	23.05.24	WAM	23.05.24	WAM	23.05.24

Scales	1:500 @ A0
--------	------------

Job No. AA7281

Client Drawing No.

Drawing No. AA7281/EW/03

Rev. J

© Asher Associates

32 George Street, Dimses DG1 1EH
Tel: 01287 255644 www.asherassociates.co.uk