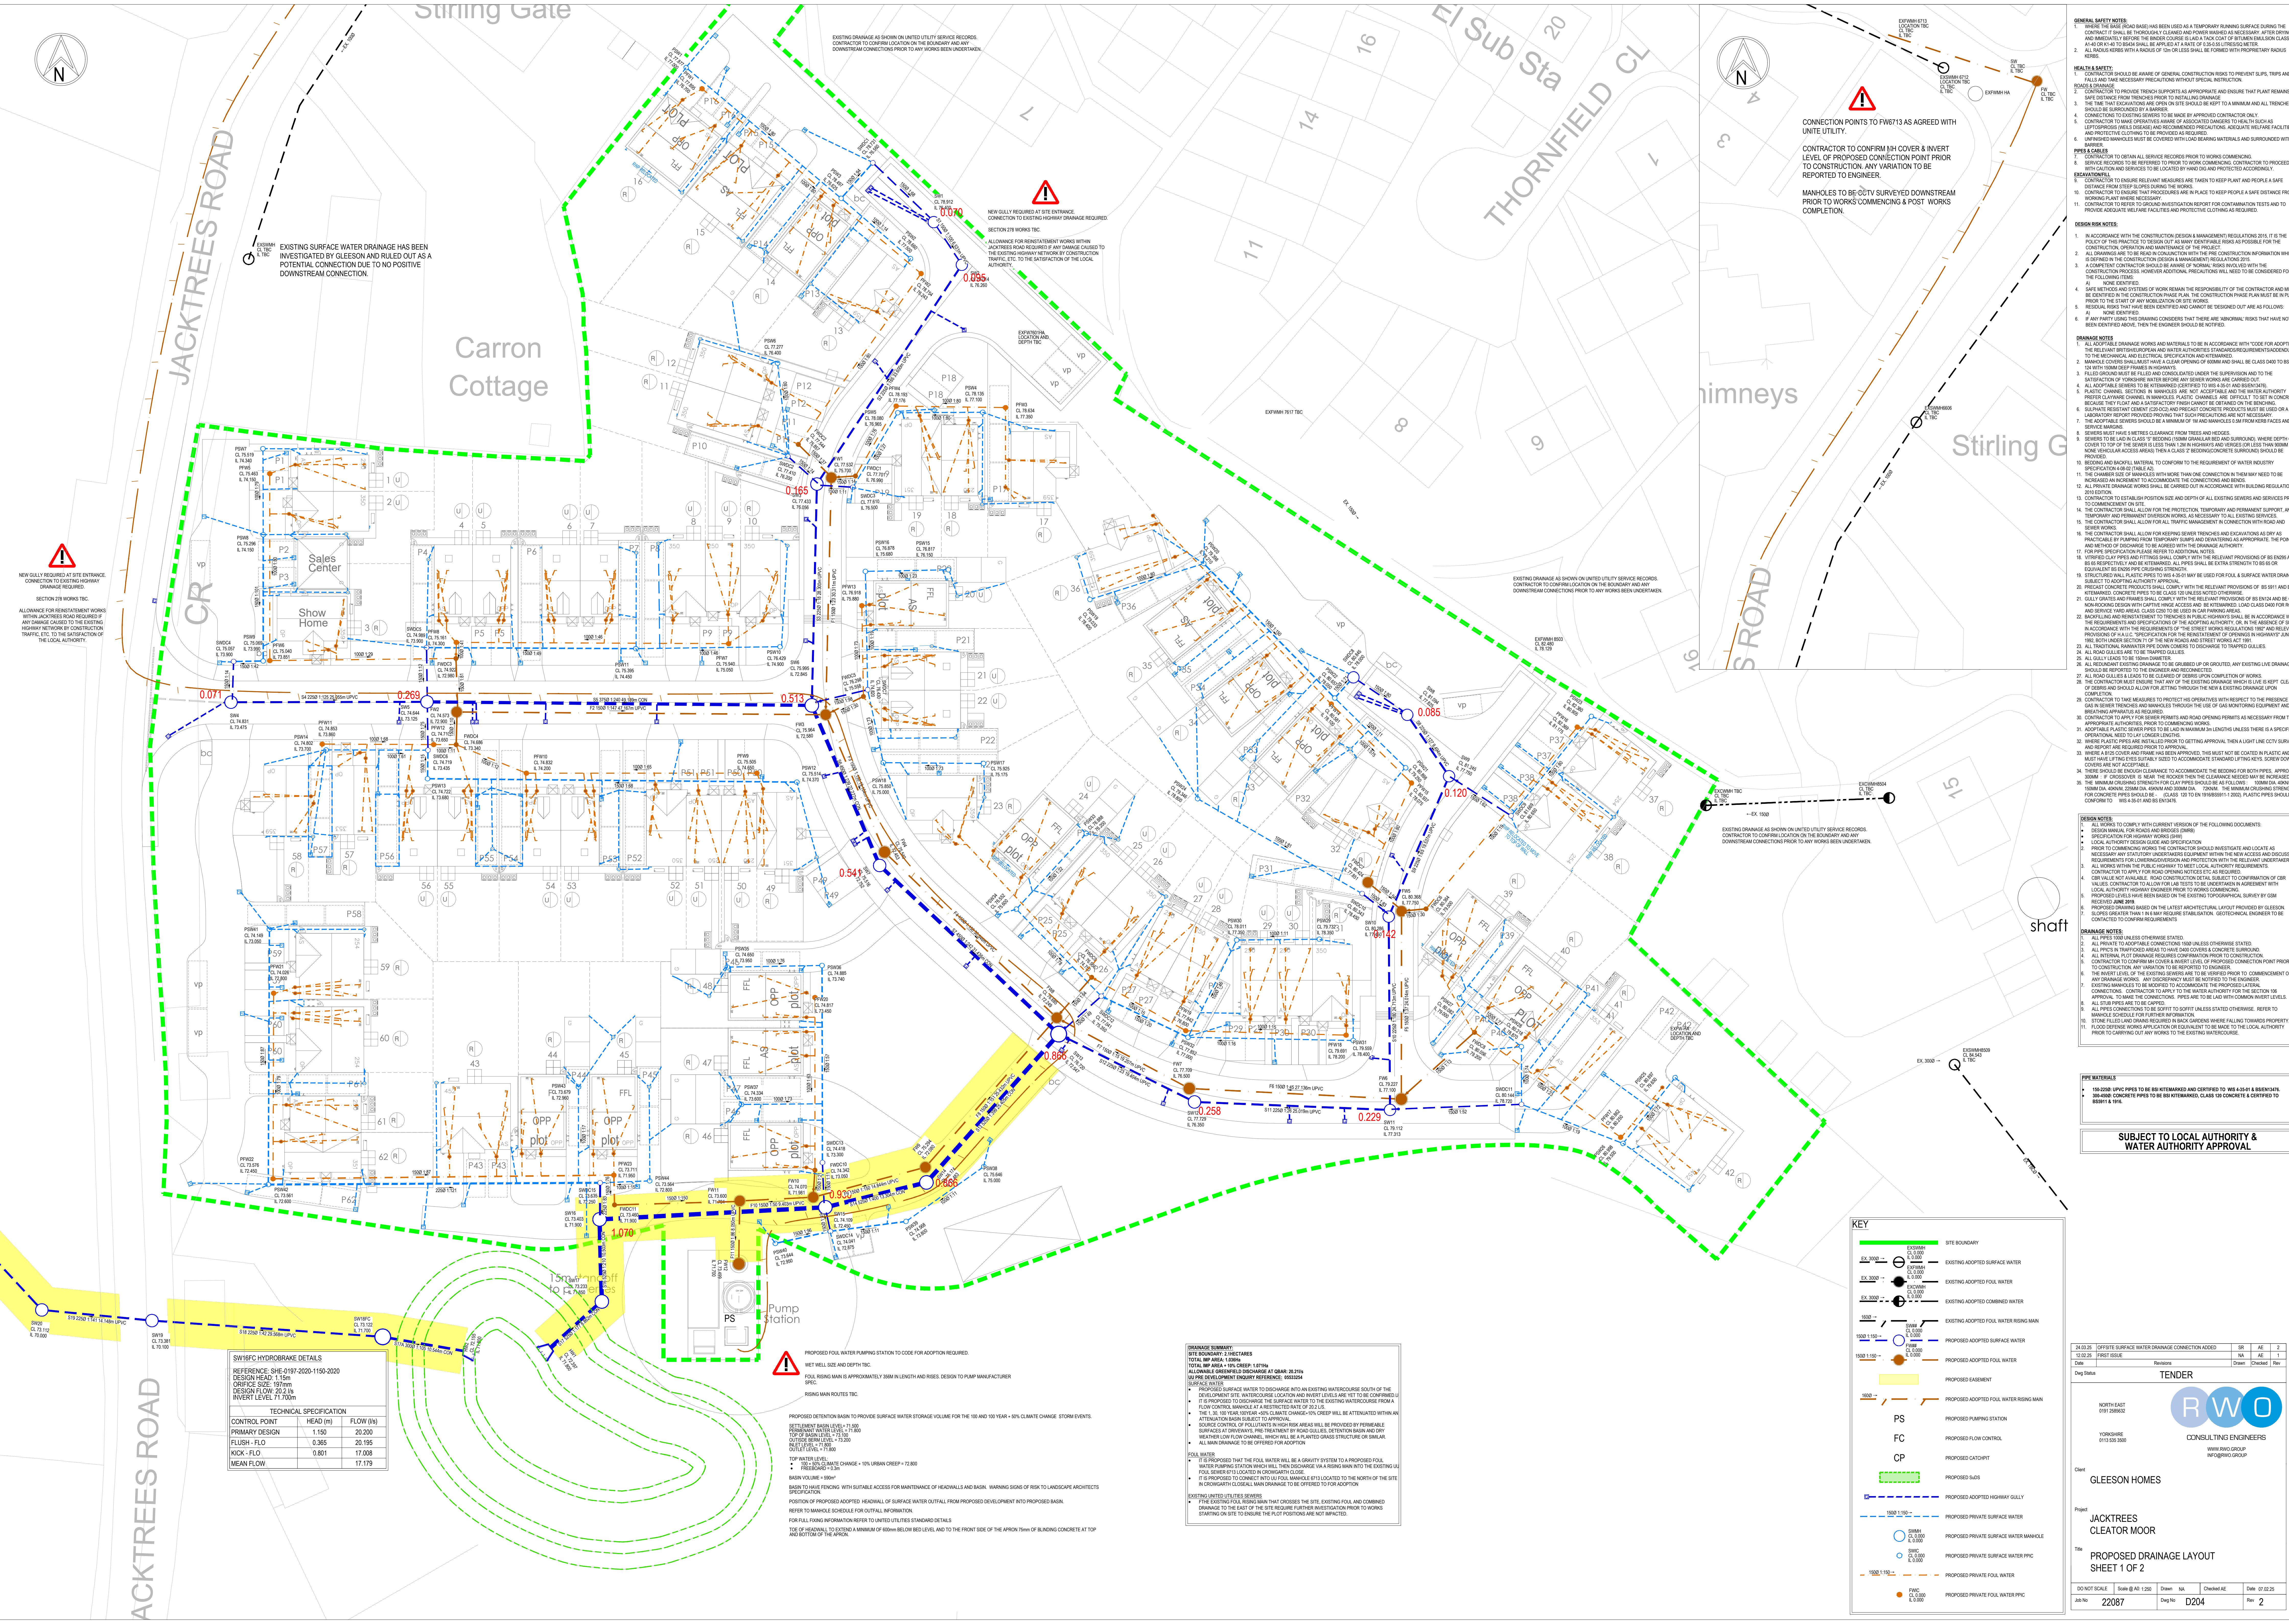


[illegible][illegible][illegible]

PIPE MATERIALS

- 150-2250: UPVC PIPES TO BE BSI KITEMARKED AND CERTIFIED TO WS 4-35-01 & BS EN 13476.
- 300-4500: CONCRETE PIPES TO BE BSI KITEMARKED, CLASS 120 CONCRETE & CERTIFIED TO BS EN 1211 & 1212

**SUBJECT TO LOCAL AUTHORITY &
WATER AUTHORITY APPROVAL**

24.02.20	OFFSETS SURFACE WATER DRAINAGE CONNECTION ADDED	DR	AE	2
12.02.20	FIRST ISSUE	NA	AE	1
Date	Revisions	Drawn	Checked	Rev

TENDER



 NORTH EAST
 0191 258932

YORKSHIRE
 0113 535 3000

CONSULTING ENGINEERS

WWW.RWQ.GROUP
 INFO@RWQ.GROUP

GLEESON HOMES

Project
JACKTREES
CLEATOR MOOR

PROPOSED DRAINAGE LAYOUT

SHEET 1 OF 2				
DO NOT SCALE	Scale @ A0: 1:250	Drawn NA	Checked AE	Date 07/02/25

Job No	22087	Dwg No	D204	Rev	2
--------	-------	--------	------	-----	---