


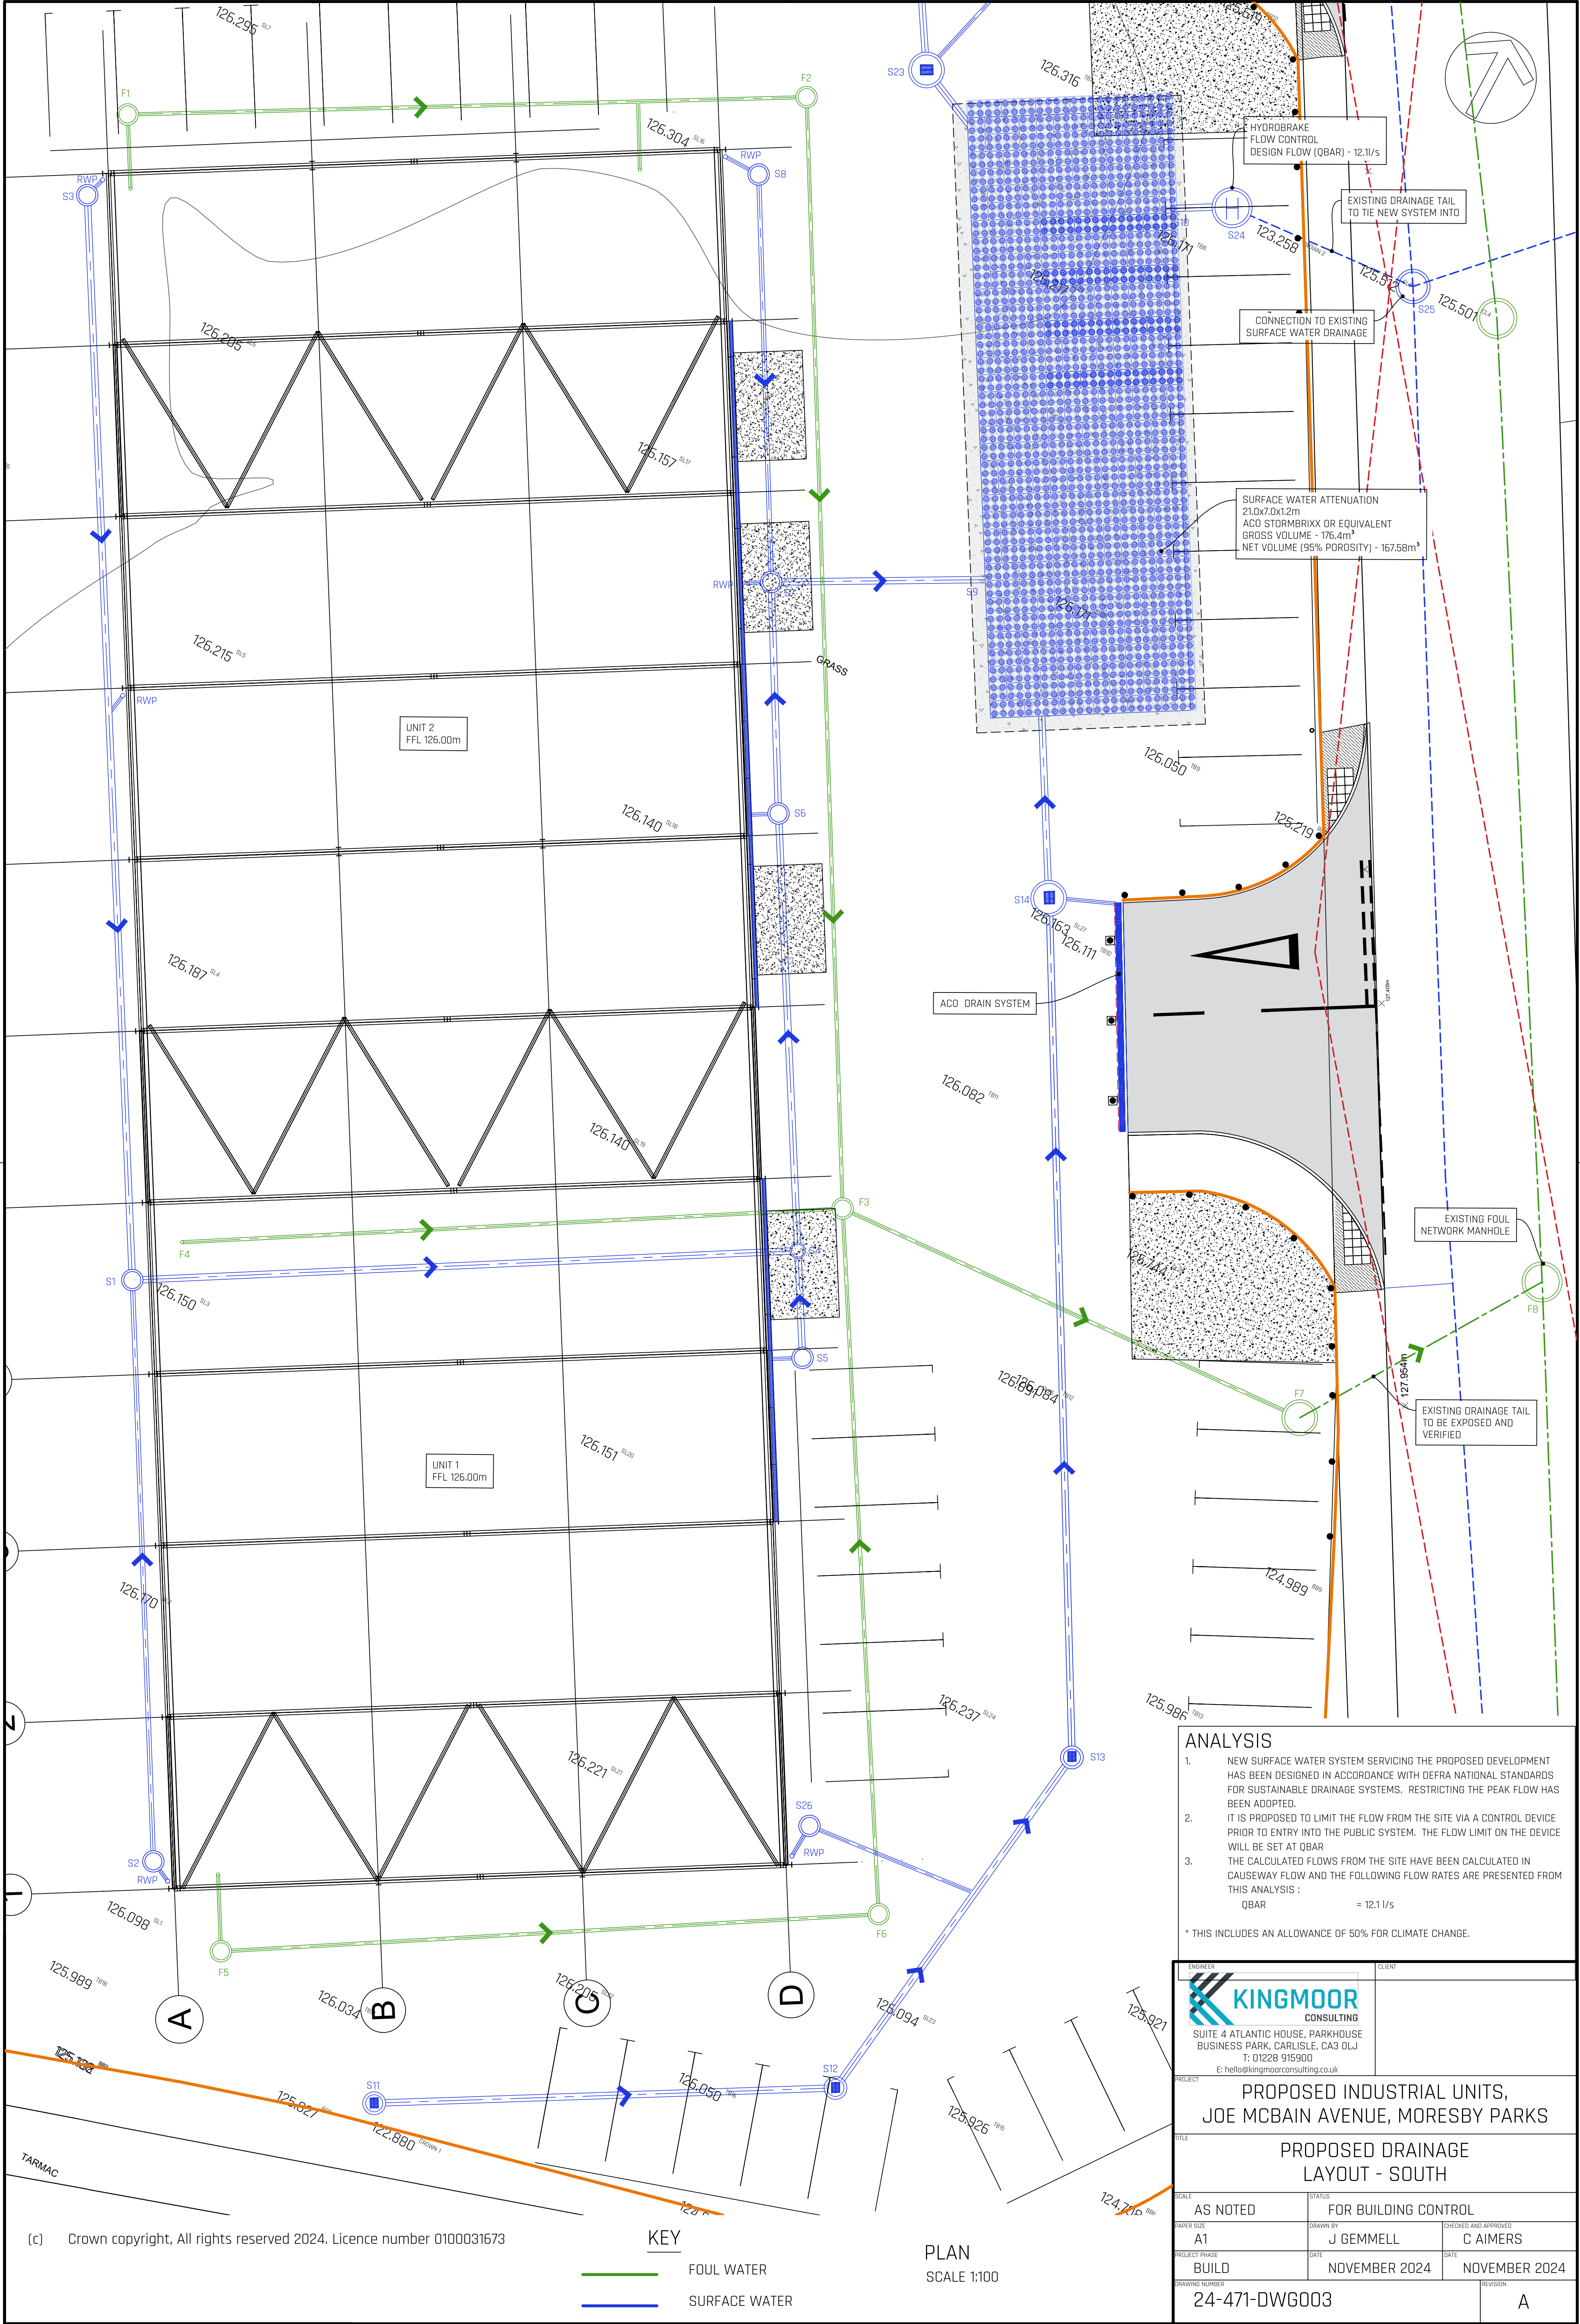

KINGMOOR CONSULTING SUITE 4 ATLANTIC HOUSE, PARKHOUSE BUSINESS PARK, CARLISLE, CA3 0LJ T: 01228 915900 E: hello@kingmoorconsulting.co.uk		CLIENT	
PROJECT PROPOSED INDUSTRIAL UNITS, JOE MCBAIN AVENUE, MORESBY PARKS			
TITLE PROPOSED DRAINAGE LAYOUT - SOUTH			
SCALE AS NOTED	STATUS FOR BUILDING CONTROL	CHECKED AND APPROVED C AIMERS	
PAPER SIZE A1	DRAWN BY J GEMMELL	DATE NOVEMBER 2024	
PROJECT PHASE BUILD	DATE NOVEMBER 2024	REVISION NOVEMBER 2024	
DRAWING NUMBER 24-471-DWG003		REVISION A	