


KEY

- LODGES
- PITCHES
- TOILETS/SHOWER AND SHOP


- GENERAL NOTES
- ALL DIMENSIONS IN MILLIMETERS UNLESS NOTED AND NOT TO BE SCALED FROM DRAWINGS. USE WRITTEN DIMENSIONS ONLY AND CHECK ON SITE BEFORE ORDERING MATERIALS OR STEELWORK.
  - ALL DRAWINGS TO BE READ IN CONJUNCTION WITH DRAWINGS PRODUCED BY OTHERS AND ANY ERRORS TO BE BROUGHT TO THE ATTENTION OF THE ENGINEER PRIOR TO COMMENCEMENT OR INSTALLATION OF THE WORKS.
  - ALL MATERIALS AND WORKMANSHIP TO BE UNDERTAKEN IN ACCORDANCE WITH BEST PRACTICE AND THE RELEVANT CODES INCLUDING BRITISH STANDARDS AND BUILDING REGULATIONS.
  - THIS WORK MAY BE REQUIRED TO COMPLY WITH THE BUILDING SAFETY ACT 2023. IF WORK REQUIRES MORE THAN ONE CONTRACTOR TO UNDERTAKE THE WORKS, THE CLIENT IS REQUIRED TO APPOINT A PRINCIPAL DESIGNER TO COORDINATE DESIGN WORKS, AND ENSURE THAT ALL DESIGN AND WORKS ARE CONSTRUCTED IN ACCORDANCE WITH THE BUILDING REGULATIONS. IT CANNOT BE ASSUMED THAT KINGMOOR CONSULTING LTD ARE BY DEFAULT THE PRINCIPAL DESIGNER UNLESS APPOINTED SPECIFICALLY FOR THIS ROLE.

<b>KINGMOOR CONSULTING</b> SUITE 4 ATLANTIC HOUSE, PARKHOUSE BUSINESS PARK, CARLISLE, CA3 0LJ T: 01228 915900 E: hello@kingmoorconsulting.co.uk		CLIENT	
PROJECT <b>PARTFIELD PARK, DRIGG, HOLMROOK</b>			
TITLE <b>PROPOSED DRAINAGE LAYOUT</b>			
SCALE <b>AS NOTED</b>	STATUS <b>FOR PLANNING CONSENT</b>		
PAPER SIZE <b>A1</b>	DRAWN BY <b>J GEMMELL</b>	CHECKED AND APPROVED <b>C AIMERS</b>	
PROJECT PHASE <b>BUILD</b>	DATE <b>NOVEMBER 2024</b>	DATE <b>NOVEMBER 2024</b>	
DRAWING NUMBER <b>24-429-DWG001</b>			REVISION <b>C</b>



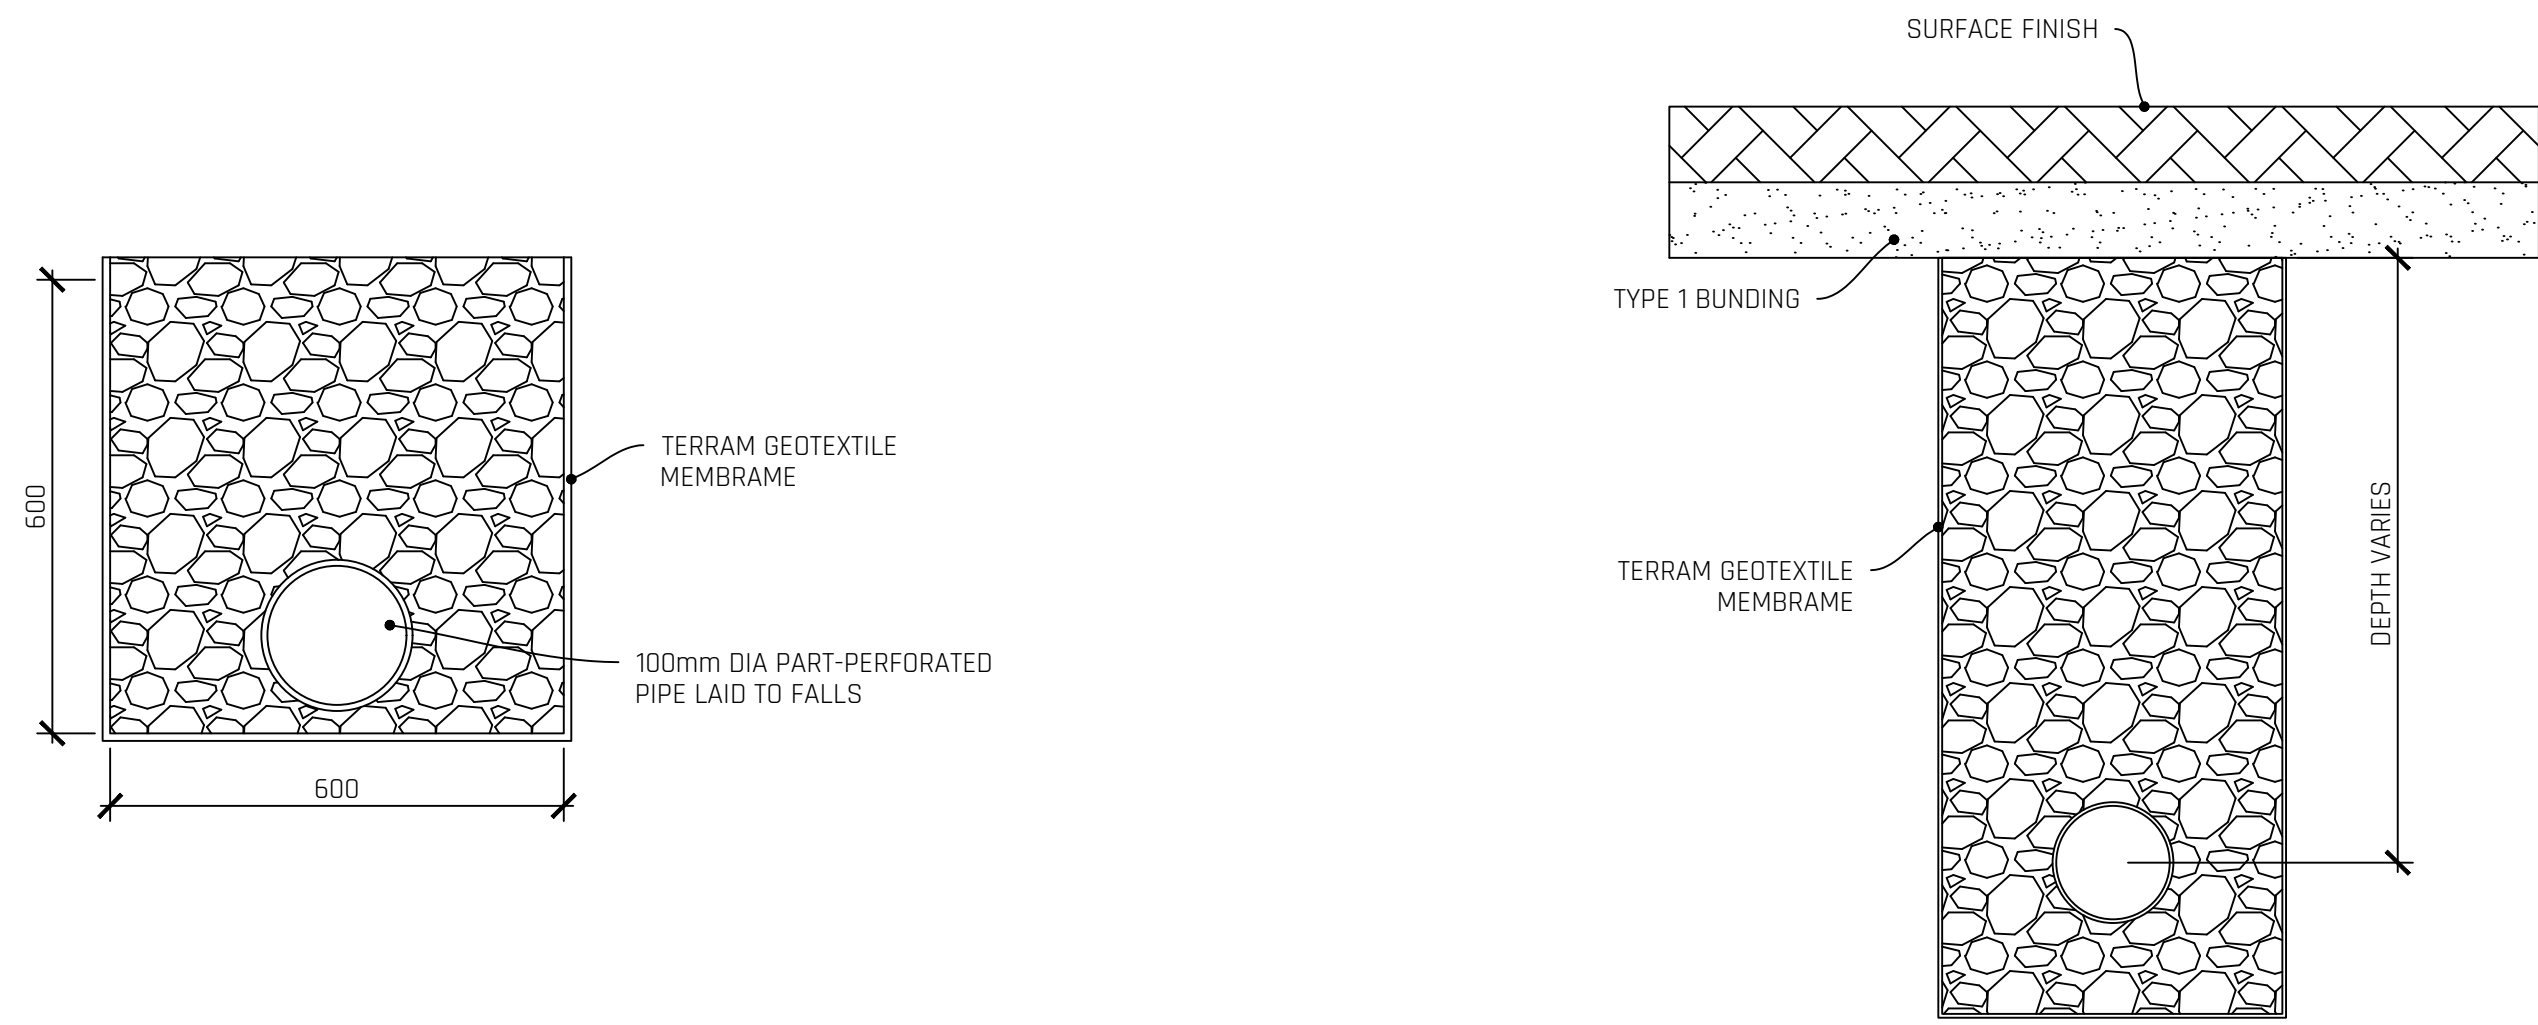


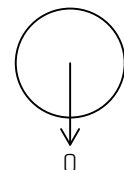
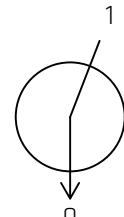
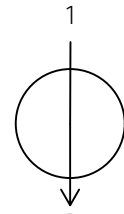
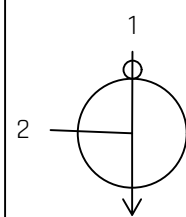
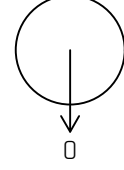
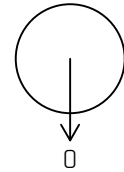
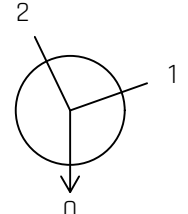
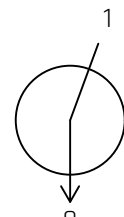
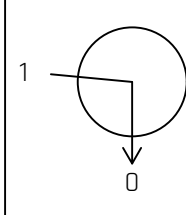
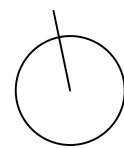
TYPICAL FRENCH DRAIN  
SCALE 1:10

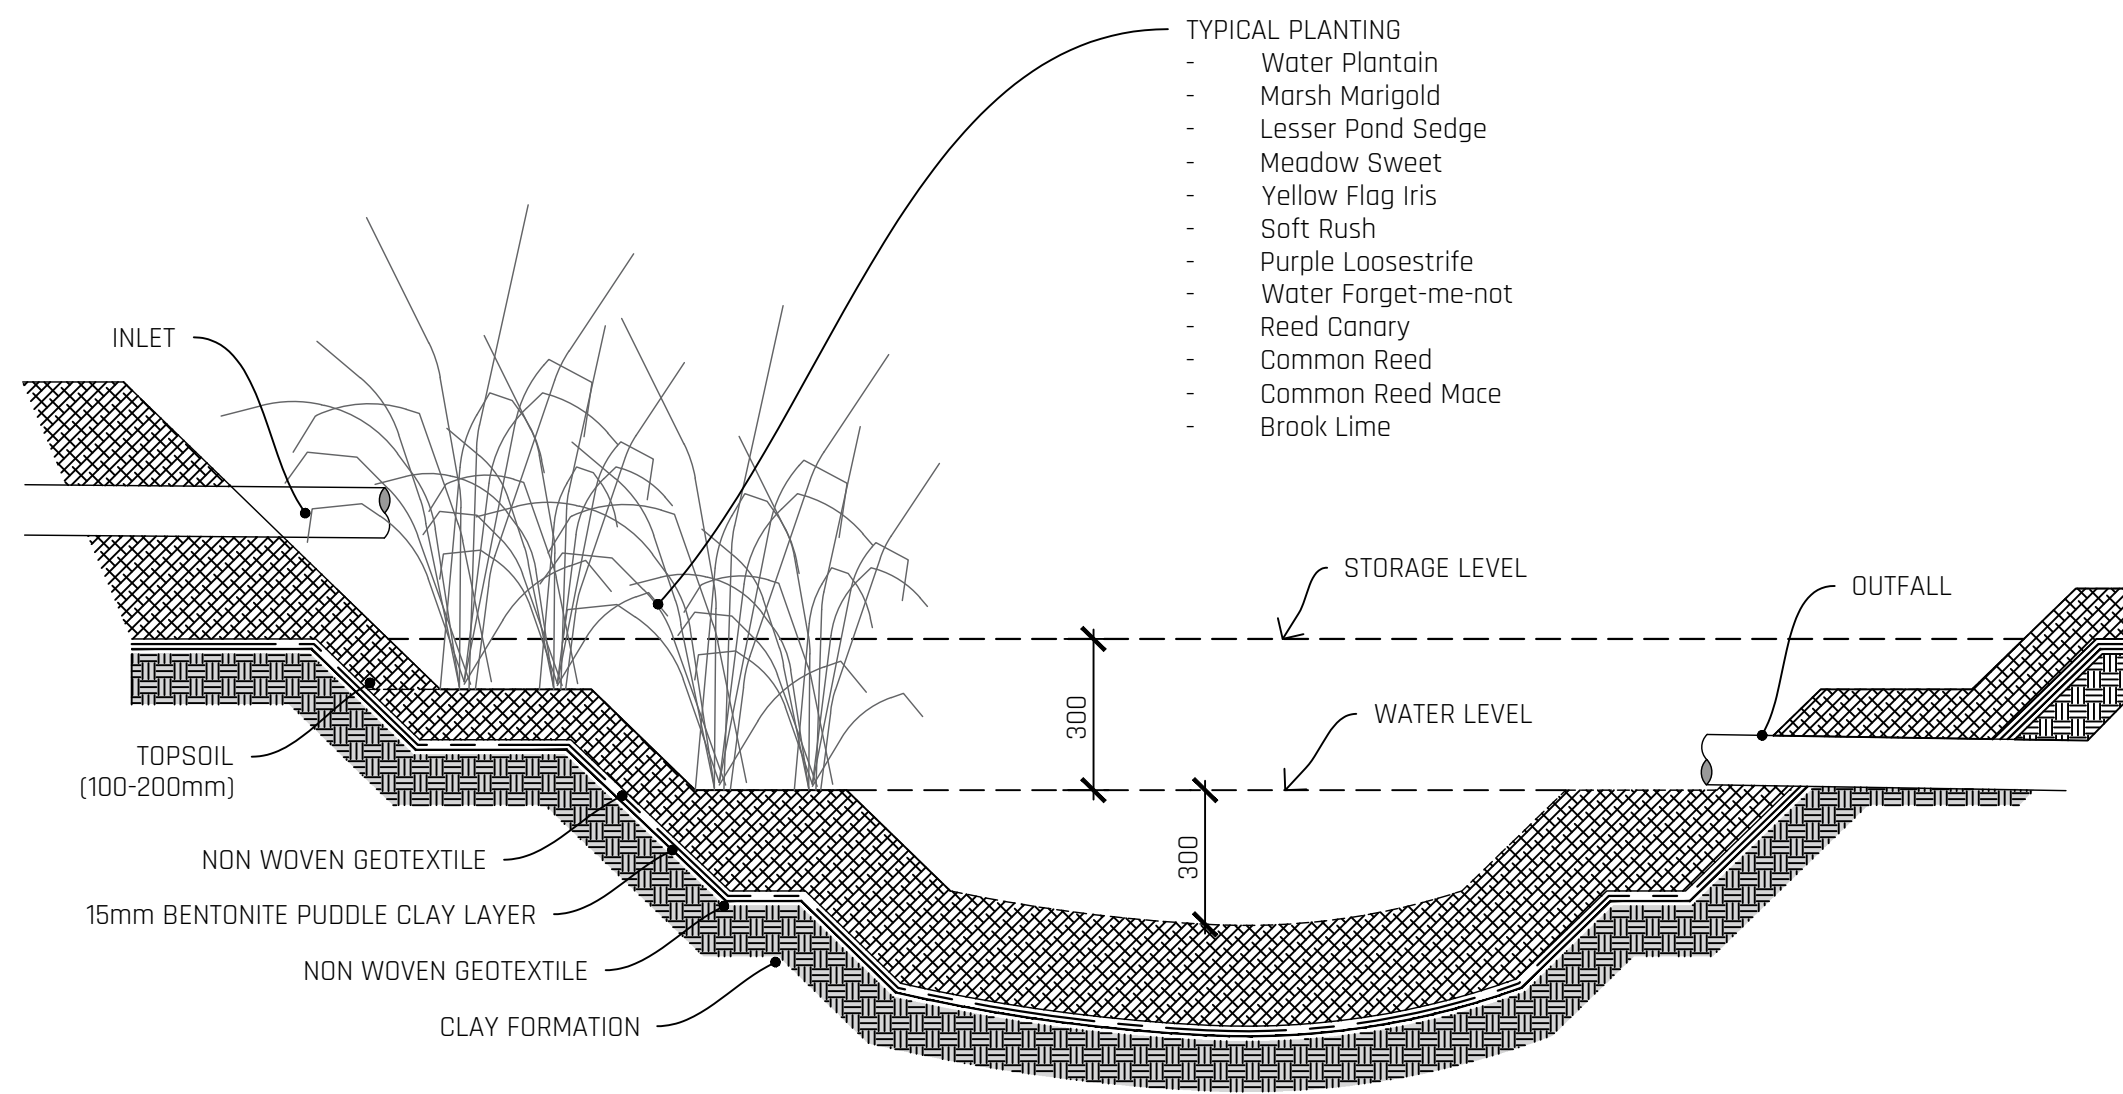

POND DETAIL  
SCALE 1:15

- GENERAL NOTES
- ALL DIMENSIONS IN MILLIMETERS UNLESS NOTED AND NOT TO BE SCALED FROM DRAWINGS. USE WRITTEN DIMENSIONS ONLY AND CHECK ON SITE BEFORE ORDERING MATERIALS OR STEELWORK.
  - ALL DRAWINGS TO BE READ IN CONJUNCTION WITH DRAWINGS PRODUCED BY OTHERS AND ANY ERRORS TO BE BROUGHT TO THE ATTENTION OF THE ENGINEER PRIOR TO COMMENCEMENT OR INSTALLATION OF THE WORKS.
  - ALL MATERIALS AND WORKMANSHIP TO BE UNDERTAKEN IN ACCORDANCE WITH BEST PRACTICE AND THE RELEVANT CODES INCLUDING BRITISH STANDARDS AND BUILDING REGULATIONS.
  - THIS WORK MAY BE REQUIRED TO COMPLY WITH THE BUILDING SAFETY ACT 2023. IF WORK REQUIRES MORE THAN ONE CONTRACTOR TO UNDERTAKE THE WORKS, THE CLIENT IS REQUIRED TO APPOINT A PRINCIPAL DESIGNER TO COORDINATE DESIGN WORKS, AND ENSURE THAT ALL DESIGN AND WORKS ARE CONSTRUCTED IN ACCORDANCE WITH THE BUILDING REGULATIONS. IT CANNOT BE ASSUMED THAT KINGMOOR CONSULTING LTD ARE BY DEFAULT THE PRINCIPAL DESIGNER UNLESS APPOINTED SPECIFICALLY FOR THIS ROLE.

ENGINEER		CLIENT	
<div><div>KINGMOOR CONSULTING</div></div> <div>SUITE 4 ATLANTIC HOUSE, PARKHOUSE BUSINESS PARK, CARLISLE, CA3 0LJ T: 01228 915900 E: hello@kingmoorconsulting.co.uk</div>			
PROJECT			
PARTFIELD PARK, DRIGG, HOLMROOK			
TITLE			
DRAINAGE DETAILS			
SCALE		STATUS	
AS NOTED		FOR PLANNING CONSENT	
PAPER SIZE		DRAWN BY	CHECKED AND APPROVED
A1		J GEMMELL	C AIMERS
PROJECT PHASE		DATE	DATE
BUILD		NOVEMBER 2024	NOVEMBER 2024
DRAWING NUMBER			REVISION
24-429-DWG002			C

Manhole Number	Cover Level	Connections	Pipe				Manhole Size	Types	
Coordinates	Depth To Soffit		Code		Inverts	Diams		Manhole	Cover
S1	19.450		0	1.000	18.550	150	600	4	Unspec
E. 307401.271 N. 500184.384	0.750								
S2	19.000		0	1.001	18.100	150	600	4	Unspec
E. 307398.297 N. 500174.076	0.750								
S3	18.800		0	1.002	18.010	150	600	4	Unspec
E. 307398.943 N. 500166.873	0.640								
S4	18.100		0	1.003	17.058	150	600	4	Unspec
E. 307400.579 N. 500149.427	0.892								
S5	18.100		0	2.000	17.250	100	600	4	Unspec
E. 307389.207 N. 500148.747	0.750								
S6	18.100		0	3.000	17.250	100	600	4	Unspec
E. 307390.054 N. 500131.348	0.750								
S7	18.100		0	1.004	16.863	150	600	4	Unspec
E. 307402.116 N. 500133.873	1.087								
S8	17.600		0	1.005	16.624	150	600	4	Unspec
E. 307420.671 N. 500129.315	0.825								
S9	17.460		0	1.006	16.301	150	600	4	Unspec
E. 307446.385 N. 500132.191	1.009								
S10	17.460		1	1.006	16.254	150	1200	4	Unspec
E. 307447.346 N. 500127.566	1.056								

STORM Network 1									
Pipe Code	Diameter (mm)	Gradient (1:)	Pipe Length	Upstream Manhole			Downstream Manhole		
				Number	Invert	Cover	Number	Invert	Cover
1.000	150	80	10.728	S1	18.55	19.45	S2	18.42	19.00
1.001	150	80	7.232	S2	18.10	19.00	S3	18.01	18.80
1.002	150	70	17.523	S3	18.01	18.80	S4	17.76	18.10
1.003	150	80	15.630	S4	17.06	18.10	S7	16.86	18.10
1.004	150	80	19.107	S7	16.86	18.10	S8	16.62	17.60
1.005	150	80	25.874	S8	16.62	17.60	S9	16.30	17.46
1.006	150	101	4.724	S9	16.30	17.46	S10	16.25	17.46
2.000	100	80	11.392	S5	17.25	18.10	S4	17.11	18.10
3.000	100	80	12.323	S6	17.25	18.10	S7	17.10	18.10


- GENERAL NOTES
1.

ALL DIMENSIONS IN MILLIMETERS UNLESS NOTED AND NOT TO BE SCALED FROM DRAWINGS. USE WRITTEN DIMENSIONS ONLY AND CHECK ON SITE BEFORE ORDERING MATERIALS OR STEELWORK.
2.


ALL DRAWINGS TO BE READ IN CONJUNCTION WITH DRAWINGS PRODUCED BY OTHERS AND ANY ERRORS TO BE BROUGHT TO THE ATTENTION OF THE ENGINEER PRIOR TO COMMENCEMENT OR INSTALLATION OF THE WORKS.
3.

ALL MATERIALS AND WORKMANSHIP TO BE UNDERTAKEN IN ACCORDANCE WITH BEST PRACTICE AND THE RELEVANT CODES INCLUDING BRITISH STANDARDS AND BUILDING REGULATIONS.
4.


THIS WORK MAY BE REQUIRED TO COMPLY WITH THE BUILDING SAFETY ACT 2023. IF WORK REQUIRES MORE THAN ONE CONTRACTOR TO UNDERTAKE THE WORKS, THE CLIENT IS REQUIRED TO APPOINT A PRINCIPAL DESIGNER TO COORDINATE DESIGN WORKS, AND ENSURE THAT ALL DESIGN AND WORKS ARE CONSTRUCTED IN ACCORDANCE WITH THE BUILDING REGULATIONS. IT CANNOT BE ASSUMED THAT KINGMOOR CONSULTING LTD ARE BY DEFAULT THE PRINCIPAL DESIGNER UNLESS APPOINTED SPECIFICALLY FOR THIS ROLE.

ENGINEER		CLIENT	
 SUITE 4 ATLANTIC HOUSE, PARKHOUSE BUSINESS PARK, CARLISLE, CA3 0LJ T: 01228 915900 E: hello@kingmoorconsulting.co.uk			
PROJECT PARTFIELD PARK, DRIGG, HOLMROOK			
TITLE MANHOLE AND PIPE SCHEDULES			
SCALE AS NOTED	STATUS FOR PLANNING CONSENT		
PAPER SIZE A1	DRAWN BY J GEMMELL	CHECKED AND APPROVED C AIMERS	
PROJECT PHASE BUILD	DATE NOVEMBER 2024	DATE NOVEMBER 2024	
DRAWING NUMBER 24-429-DWG003			REVISION C



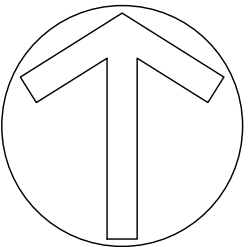


KEY

 

SURFACED AREA




FOOTPATH

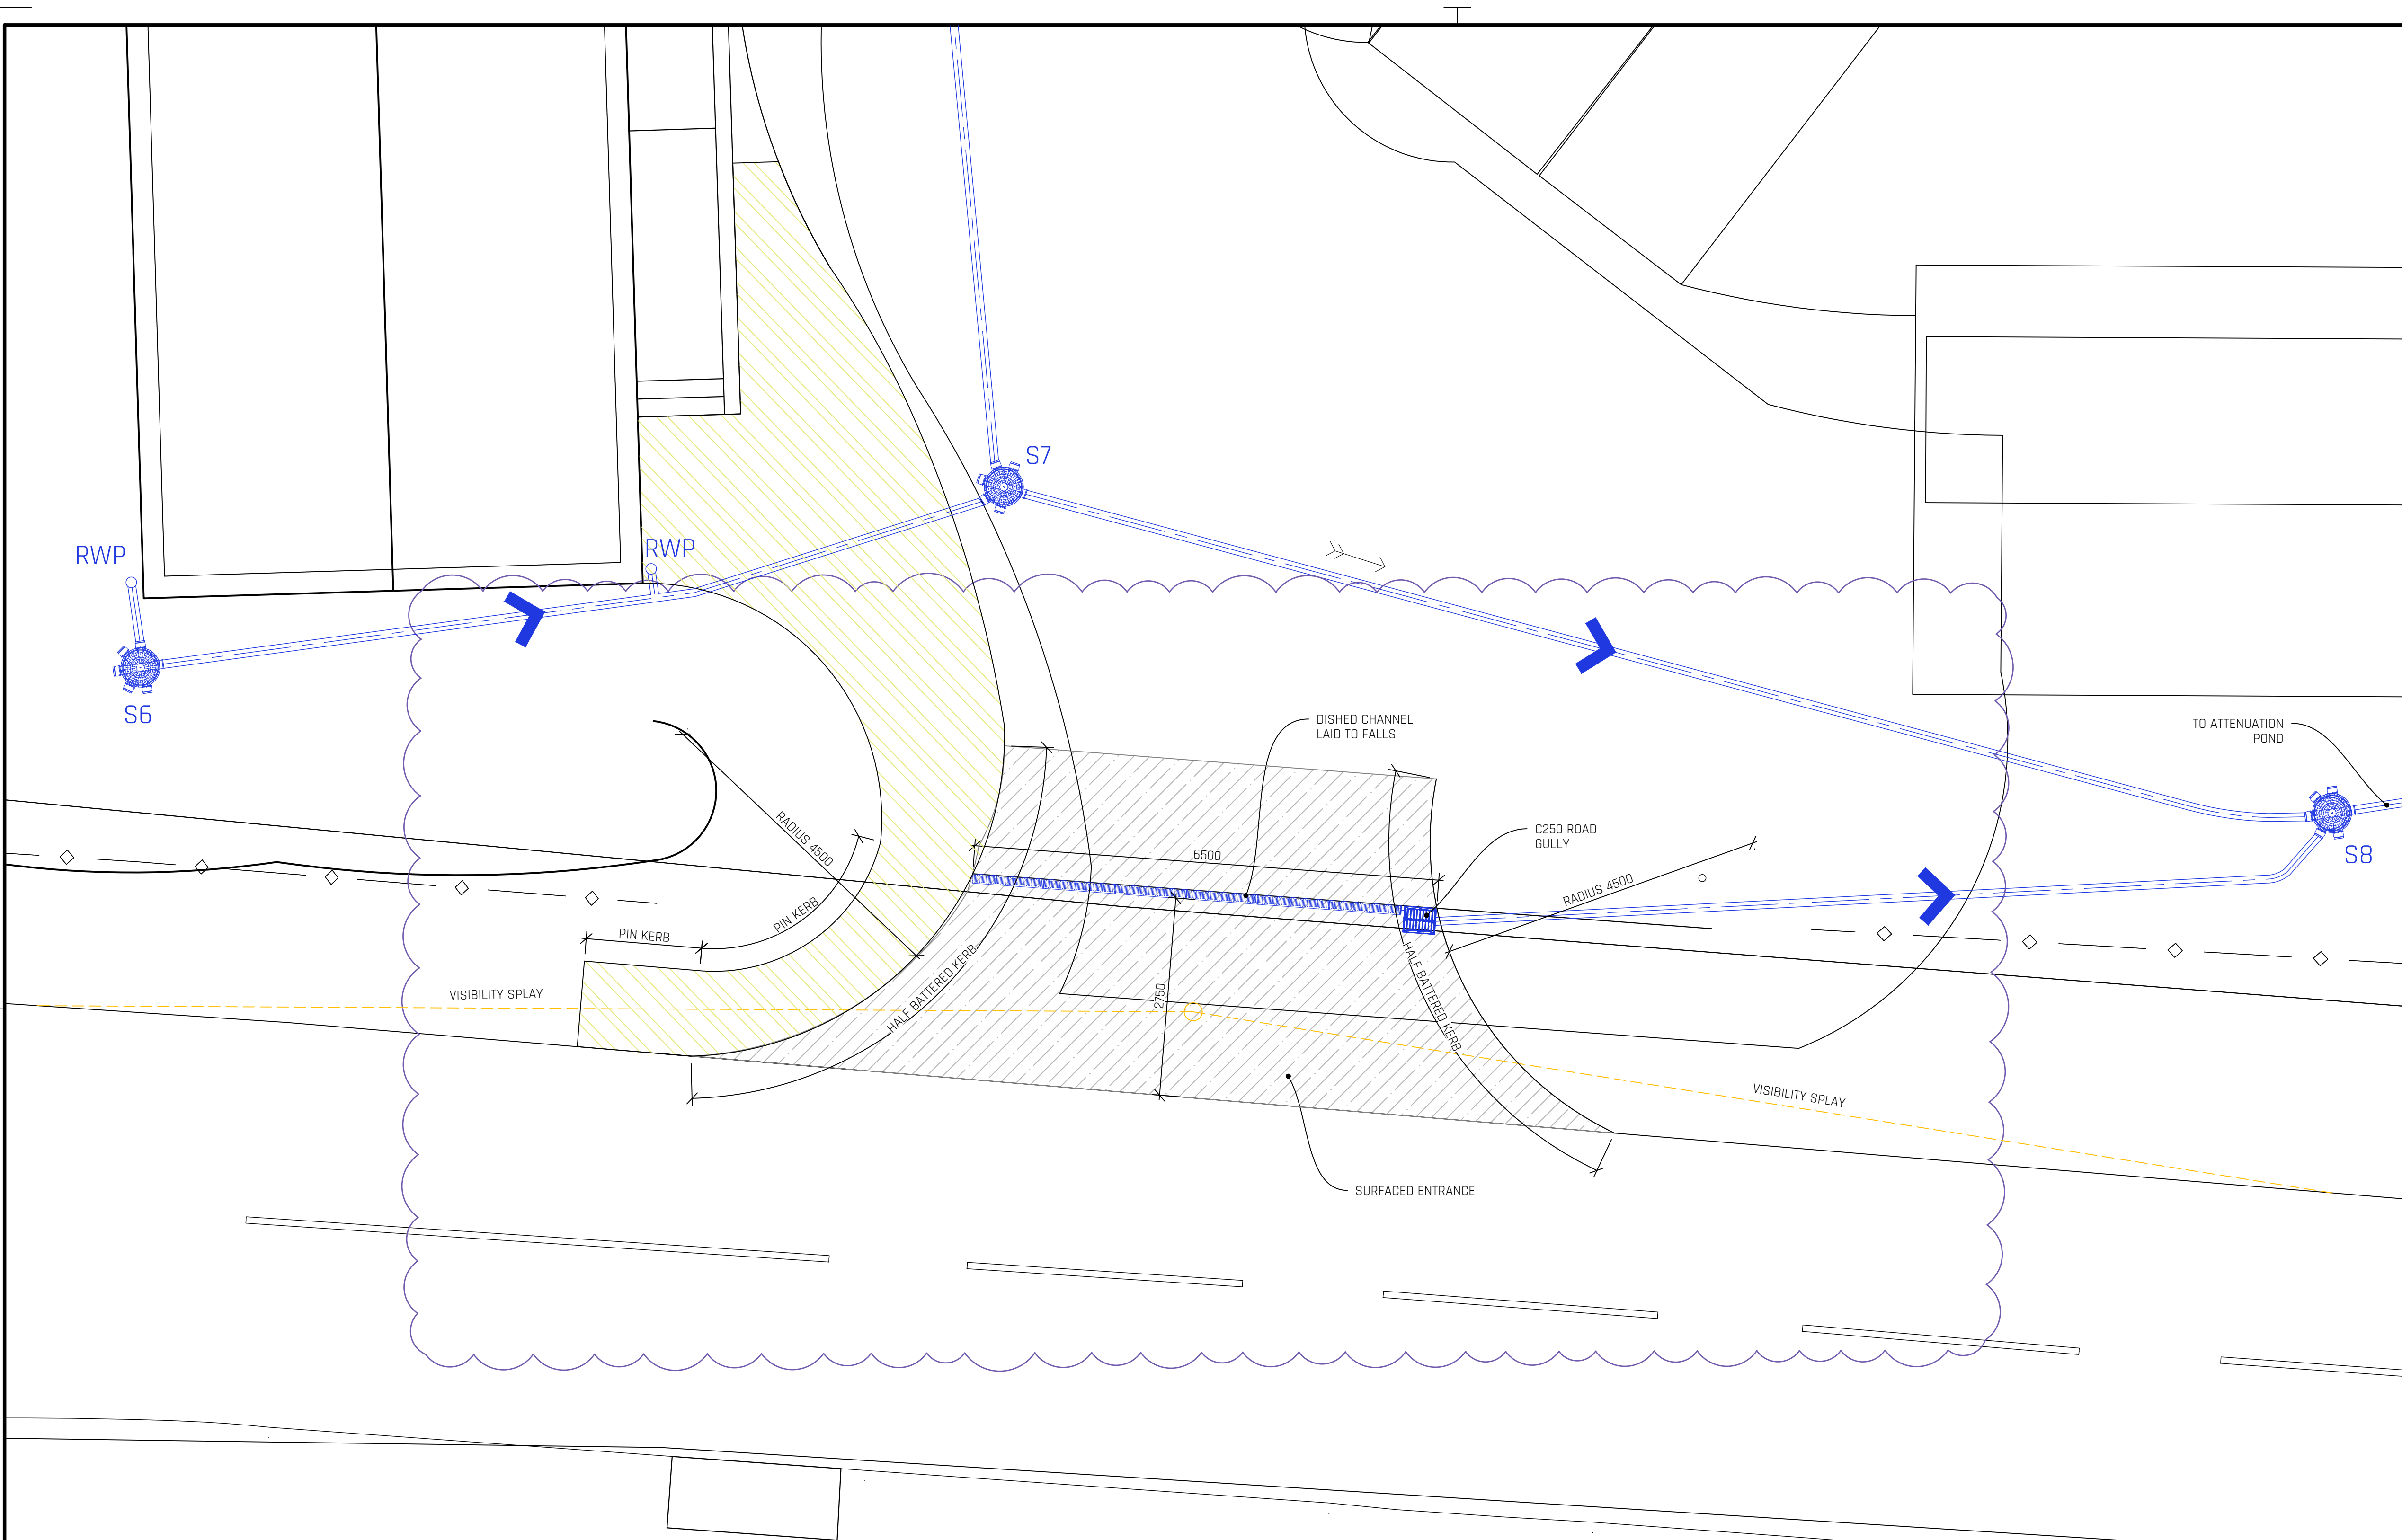

PLAN  
SCALE 1:50

- GENERAL NOTES
1. ALL DIMENSIONS IN MILLIMETERS UNLESS NOTED AND NOT TO BE SCALED FROM DRAWINGS. USE WRITTEN DIMENSIONS ONLY AND CHECK ON SITE BEFORE ORDERING MATERIALS OR STEELWORK.
  2. ALL DRAWINGS TO BE READ IN CONJUNCTION WITH DRAWINGS PRODUCED BY OTHERS AND ANY ERRORS TO BE BROUGHT TO THE ATTENTION OF THE ENGINEER PRIOR TO COMMENCEMENT OR INSTALLATION OF THE WORKS.
  3. ALL MATERIALS AND WORKMANSHIP TO BE UNDERTAKEN IN ACCORDANCE WITH BEST PRACTICE AND THE RELEVANT CODES INCLUDING BRITISH STANDARDS AND BUILDING REGULATIONS.
  4. THIS WORK MAY BE REQUIRED TO COMPLY WITH THE BUILDING SAFETY ACT 2023. IF WORK REQUIRES MORE THAN ONE CONTRACTOR TO UNDERTAKE THE WORKS, THE CLIENT IS REQUIRED TO APPOINT A PRINCIPAL DESIGNER TO COORDINATE DESIGN WORKS, AND ENSURE THAT ALL DESIGN AND WORKS ARE CONSTRUCTED IN ACCORDANCE WITH THE BUILDING REGULATIONS. IT CANNOT BE ASSUMED THAT KINGMOOR CONSULTING LTD ARE BY DEFAULT THE PRINCIPAL DESIGNER UNLESS APPOINTED SPECIFICALLY FOR THIS ROLE.

<div>ENGINEER</div> <div><div>KINGMOOR CONSULTING</div></div> <div>SUITE 4 ATLANTIC HOUSE, PARKHOUSE BUSINESS PARK, CARLISLE, CA3 0LJ T: 01228 915900 E: hello@kingmoorconsulting.co.uk</div>		<div>CLIENT</div>	
PROJECT PARTFIELD PARK, DRIGG, HOLMROOK			
TITLE SITE ENTRANCE			
SCALE AS NOTED		STATUS FOR PLANNING CONSENT	
PAPER SIZE A1		DRAWN BY J GEMMELL	CHECKED AND APPROVED C AIMERS
PROJECT PHASE BUILD		DATE NOVEMBER 2024	DATE NOVEMBER 2024
DRAWING NUMBER 24-429-DWG004			REVISION C